

NEW BUILDING WORKS TO: AUSTRALIAN DRYLANDS LEARNING HUB MELBOURNE

CLIENT: RBGV

DRAWING SCHEDULE

JOB#: 2305

DD001	LOCALITY PLAN - PROPOSED	1:1000
DD050	SITE PLAN - EXISTING CONDITIONS	1:150
DD051	EX GROUND FLOOR PLAN	1:50
DD053	EX ELEVATIONS	1:50
DD054	EX ELEVATIONS	1:50
DD101	SITE PLAN - PROPOSED	1:150
DD103	ROOF PLAN	1:100
DD107	RAMP - PROPOSED	1:50
DD108	RAMP UPPER - PROPOSED	1:50
DD151	LEARNING HUB RCP	1:50
DD152	AMENITIES RCP	1:50
DD201	ELEVATIONS - AMENITIES	1:50
DD202	ELEVATIONS - AMENITIES	1:50
DD203	ELEVATIONS - HUB	1:50
DD204	ELEVATIONS - HUB	1:50
DD302	SECTIONS	1:100
DD401	DOOR & WINDOW SCHEDULE	1:50
DD501	INTERNAL ELEVATIONS	1:50
DD502	INTERNAL ELEVATIONS	1:50
DD503	INTERNAL ELEVATIONS	1:50



PRELIMINARY


REV	ISSUE DATE	BY	REASON FOR ISSUE
00	22.11.24	ST	ISSUED TO DDA
01	5.02.25	ST	ISSUED TO CLIENT

ARCHITECT



SARAH LAKE ARCHITECTS

Level 1 242 Victoria Street
BRUNSWICK VIC 3056
info@sarahlake.com.au
www.sarahlake.com.au

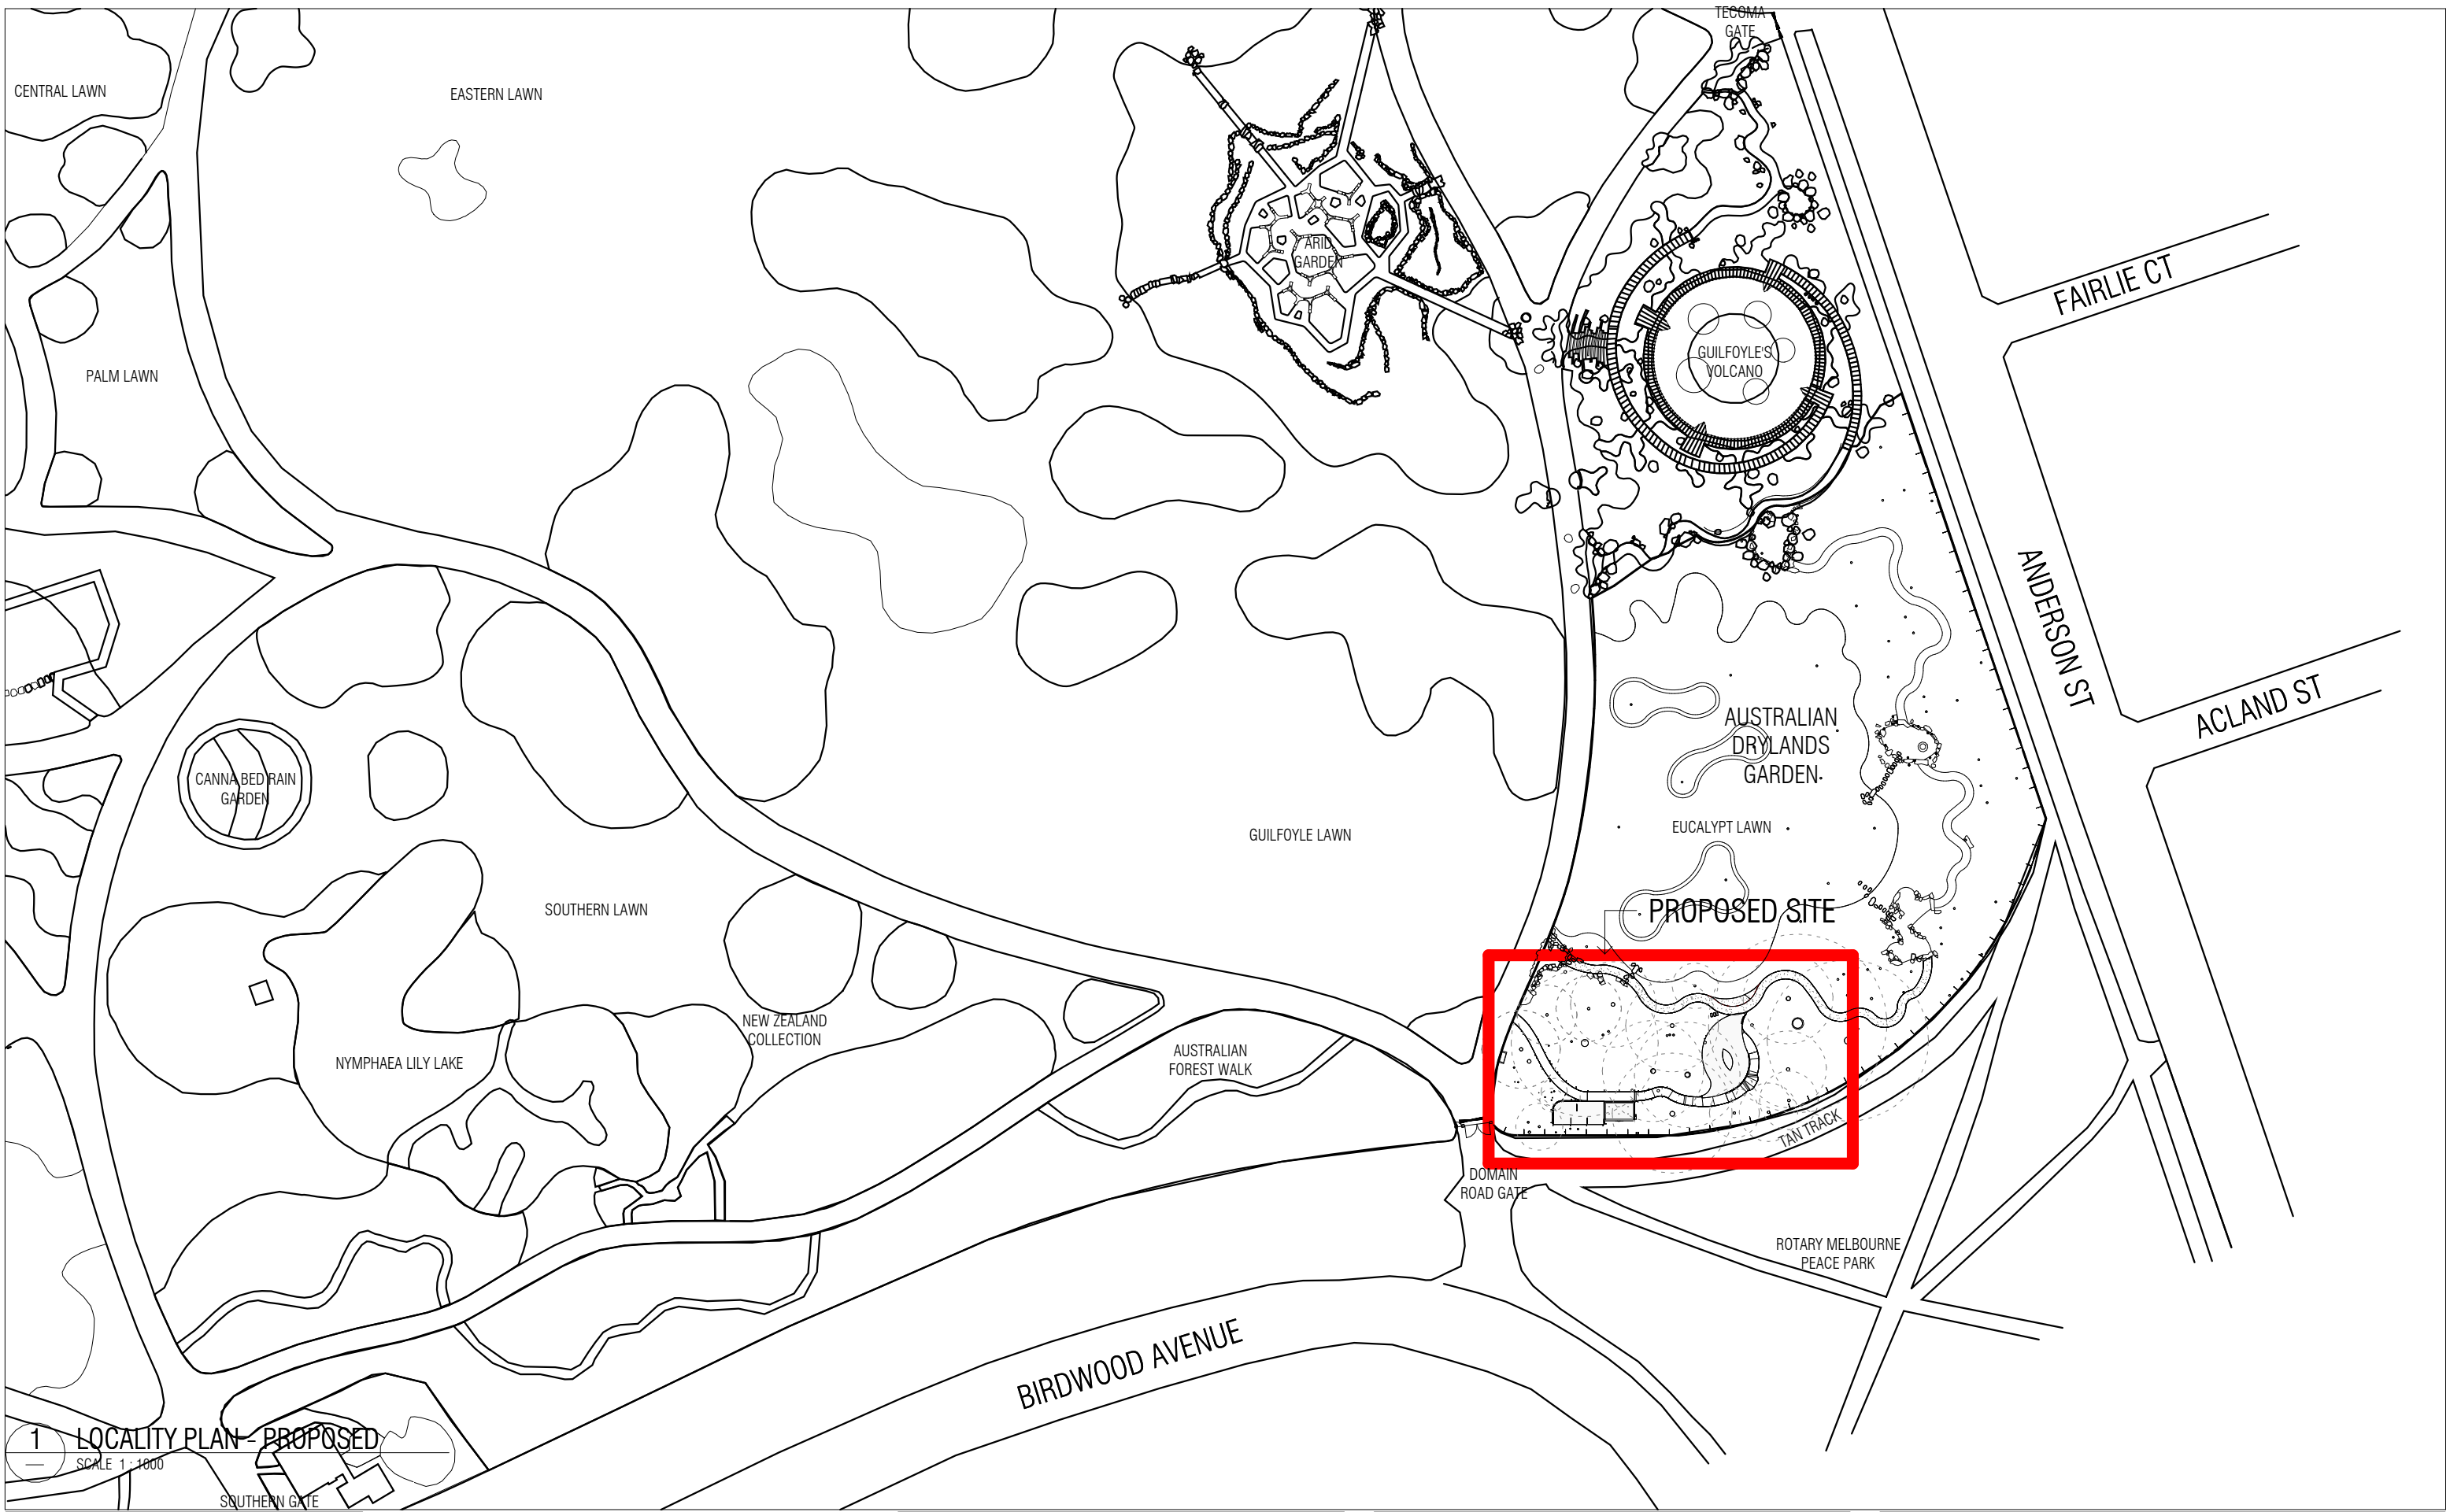

1 LOCALITY PLAN - PROPOSED
SCALE 1 : 1800

PRELIMINARY			
REV	ISSUE DATE	BY	REASON FOR ISSUE
00	22.11.24	ST	ISSUED TO DDA
01	5.02.25	ST	ISSUED TO CLIENT

ARCHITECT



SARAH LAKE ARCHITECTS

Level 1 242 Victoria Street
BRUNSWICK VIC 3056
info@sarahlake.com.au
www.sarahlake.com.au

PROJECT DETAILS

PROJECT: AUSTRALIAN DRYLANDS
LEARNING HUB MELBOURNE

CLIENT: RBGV

ALL WORKS TO BE CARRIED OUT TO AUSTRALIAN STANDARDS AND TO COMPLY WITH
THE BUILDING CODE OF AUSTRALIA
ALL DIMENSIONS TO BE CHECKED ON SITE PRIOR TO WORKS COMMENCING


DRAWING


TITLE: LOCALITY PLAN - PROPOSED
PROPOSED

SCALE: 1 : 1000
DATE: MAY 2023

JOB NUMBER: 2305
DRAWN: ST

DRAWING NO: DD001

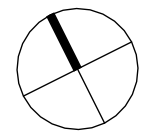

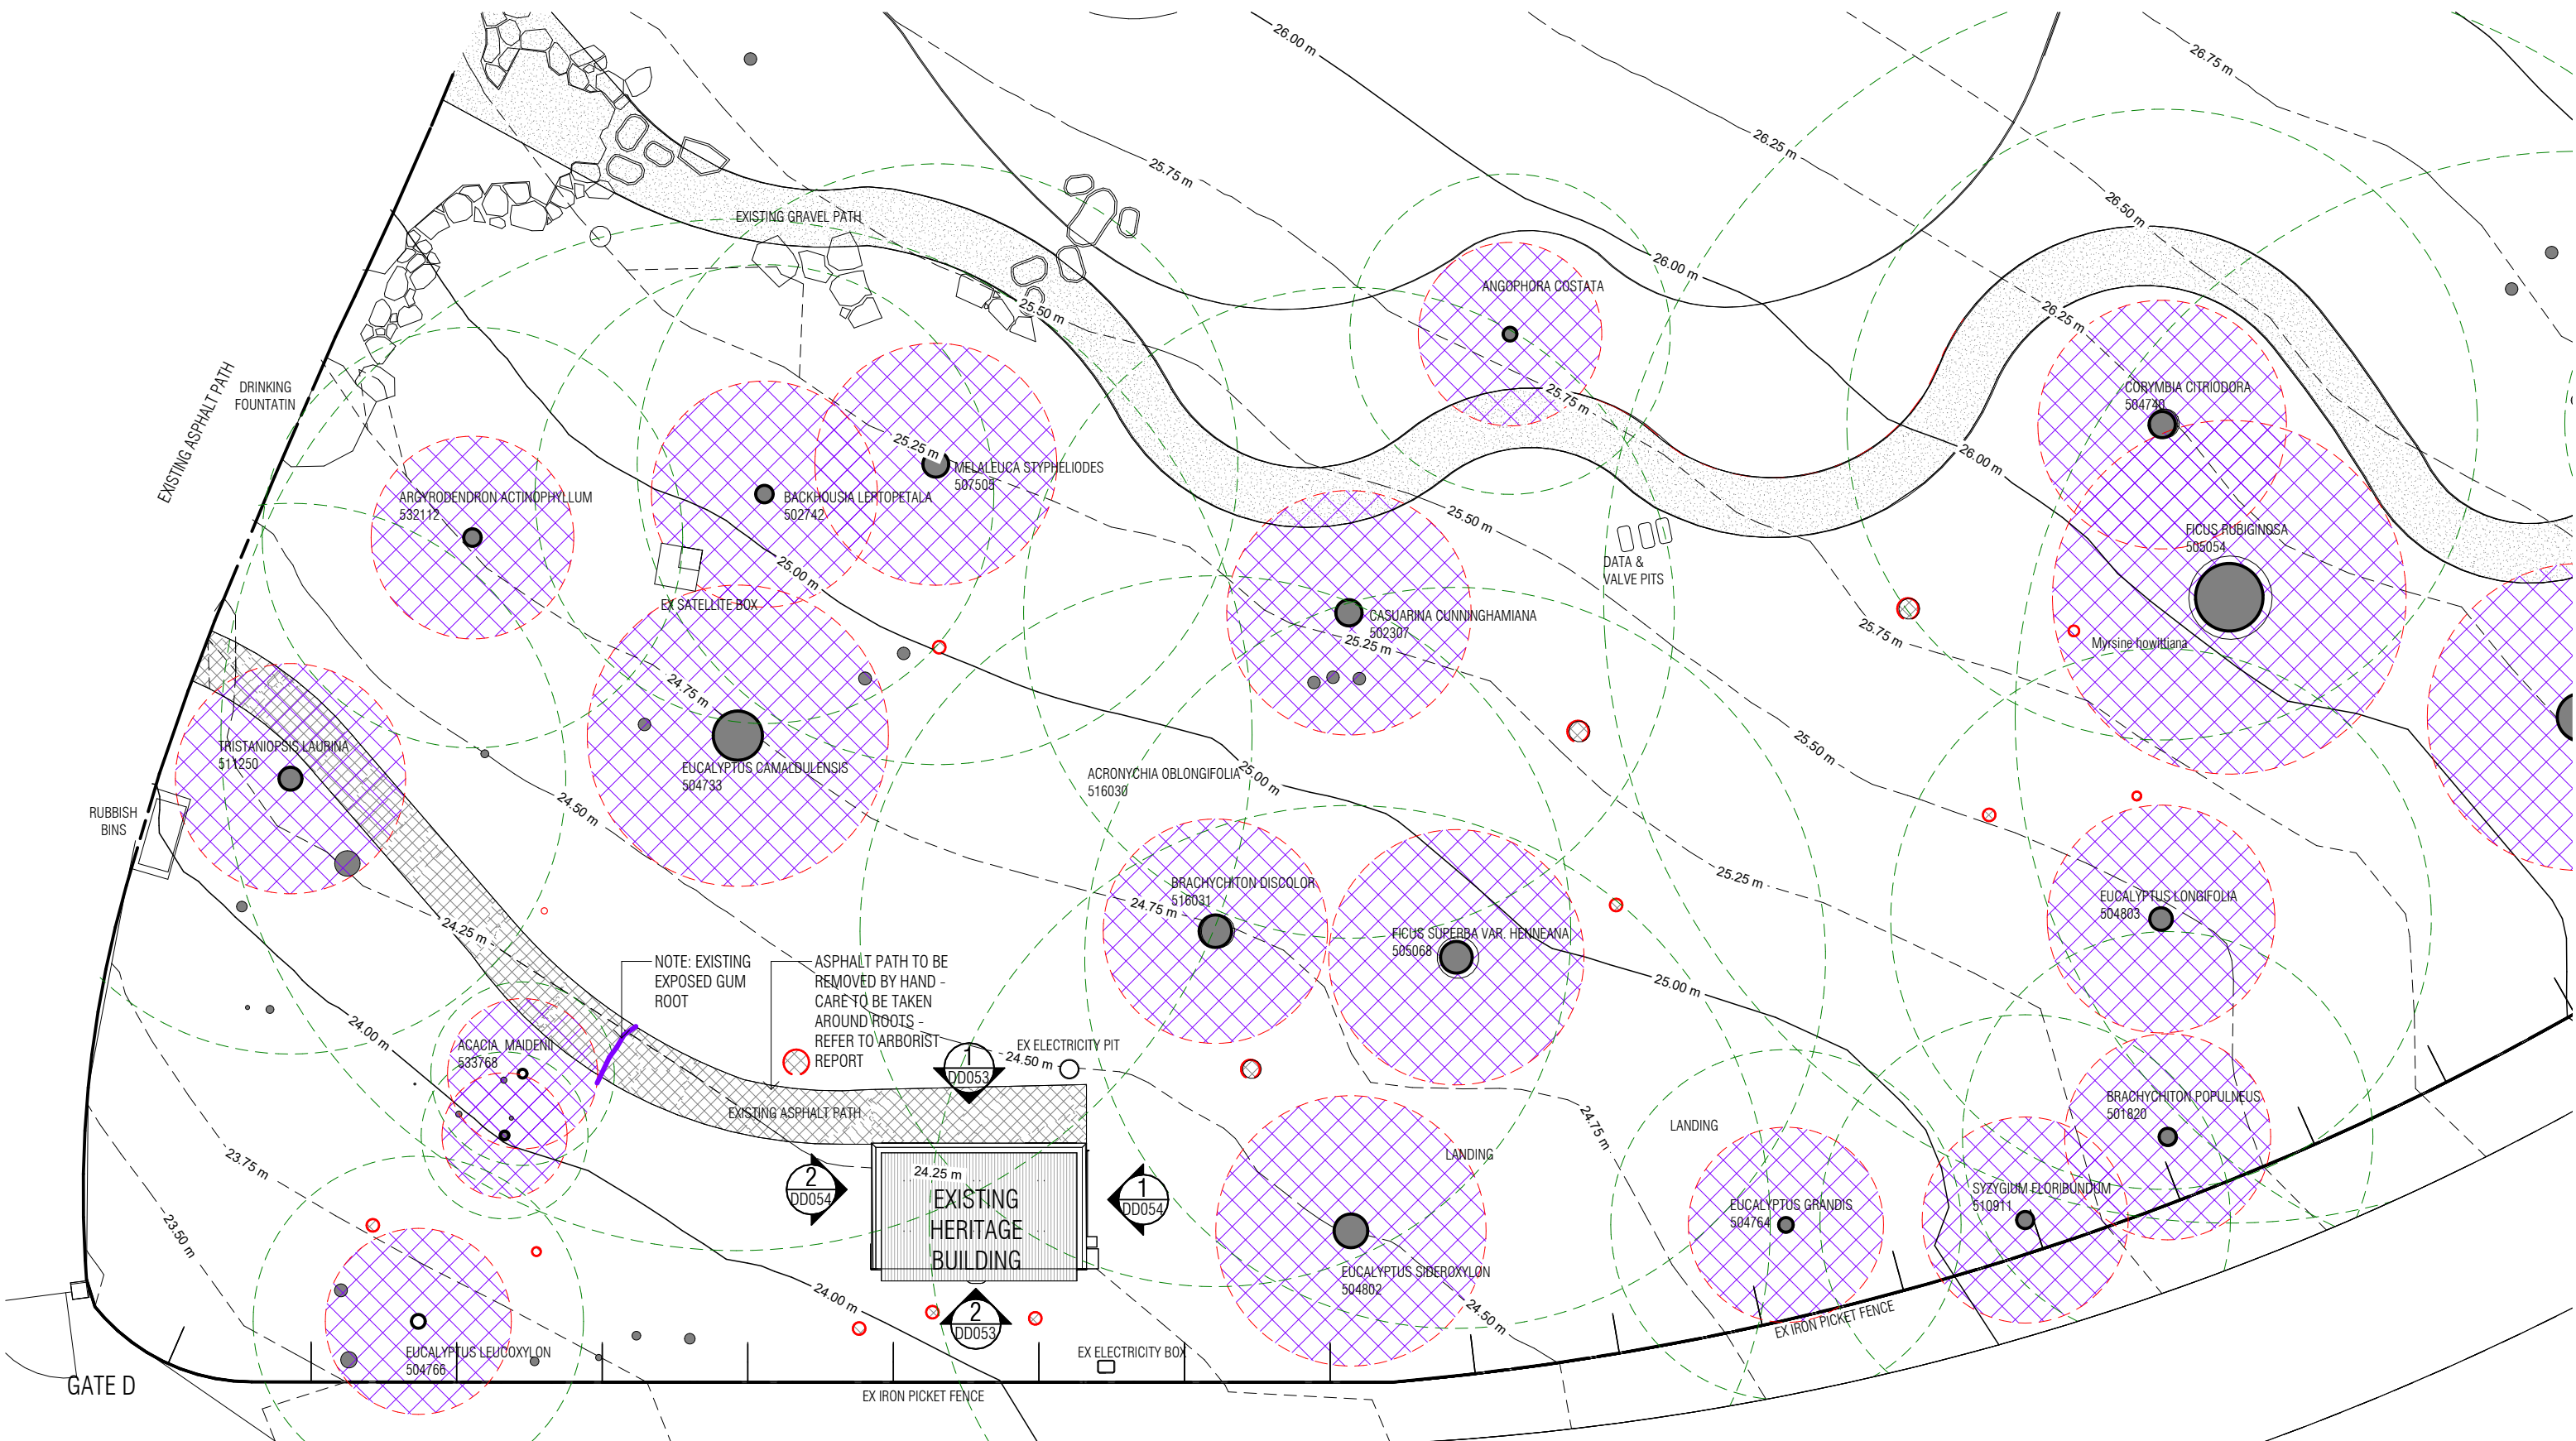

1 SITE - EXISTING
DD053 SCALE 1 : 150

PRELIMINARY			
REV	ISSUE DATE	BY	REASON FOR ISSUE
00	22.11.24	ST	ISSUED TO DDA
01	5.02.25	ST	ISSUED TO CLIENT

- DEMOLITION
- SRZ - STRUCTURAL ROOT ZONE
- TPZ - TREE PROTECTION ZONE

ARCHITECT



SARAH LAKE ARCHITECTS

Level 1 242 Victoria Street
BRUNSWICK VIC 3056
info@sarahlake.com.au
www.sarahlake.com.au

PROJECT DETAILS

PROJECT: AUSTRALIAN DRYLANDS LEARNING HUB MELBOURNE

CLIENT: RBGV

ALL WORKS TO BE CARRIED OUT TO AUSTRALIAN STANDARDS AND TO COMPLY WITH THE BUILDING CODE OF AUSTRALIA
ALL DIMENSIONS TO BE CHECKED ON SITE PRIOR TO WORKS COMMENCING


DRAWING

TITLE: SITE PLAN - EXISTING CONDITIONS PROPOSED


SCALE: As indicated JOB NUMBER: 2305

DATE: MAY 2023 DRAWN: ST

DRAWING NO: DD050

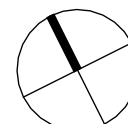

NOTE: TREE REMOVAL TO BE UNDERTAKEN BY RBGV BEFORE WORKS COMMENCE. DRAWINGS TO BE READ IN CONJUNCTION WITH TREE MANAGEMENT PLAN AND EXPOSED ROOTS. TREE MANAGEMNET PLAN TO INCLUDE PROTECTION/BARRIERS AROUND SRZ'S

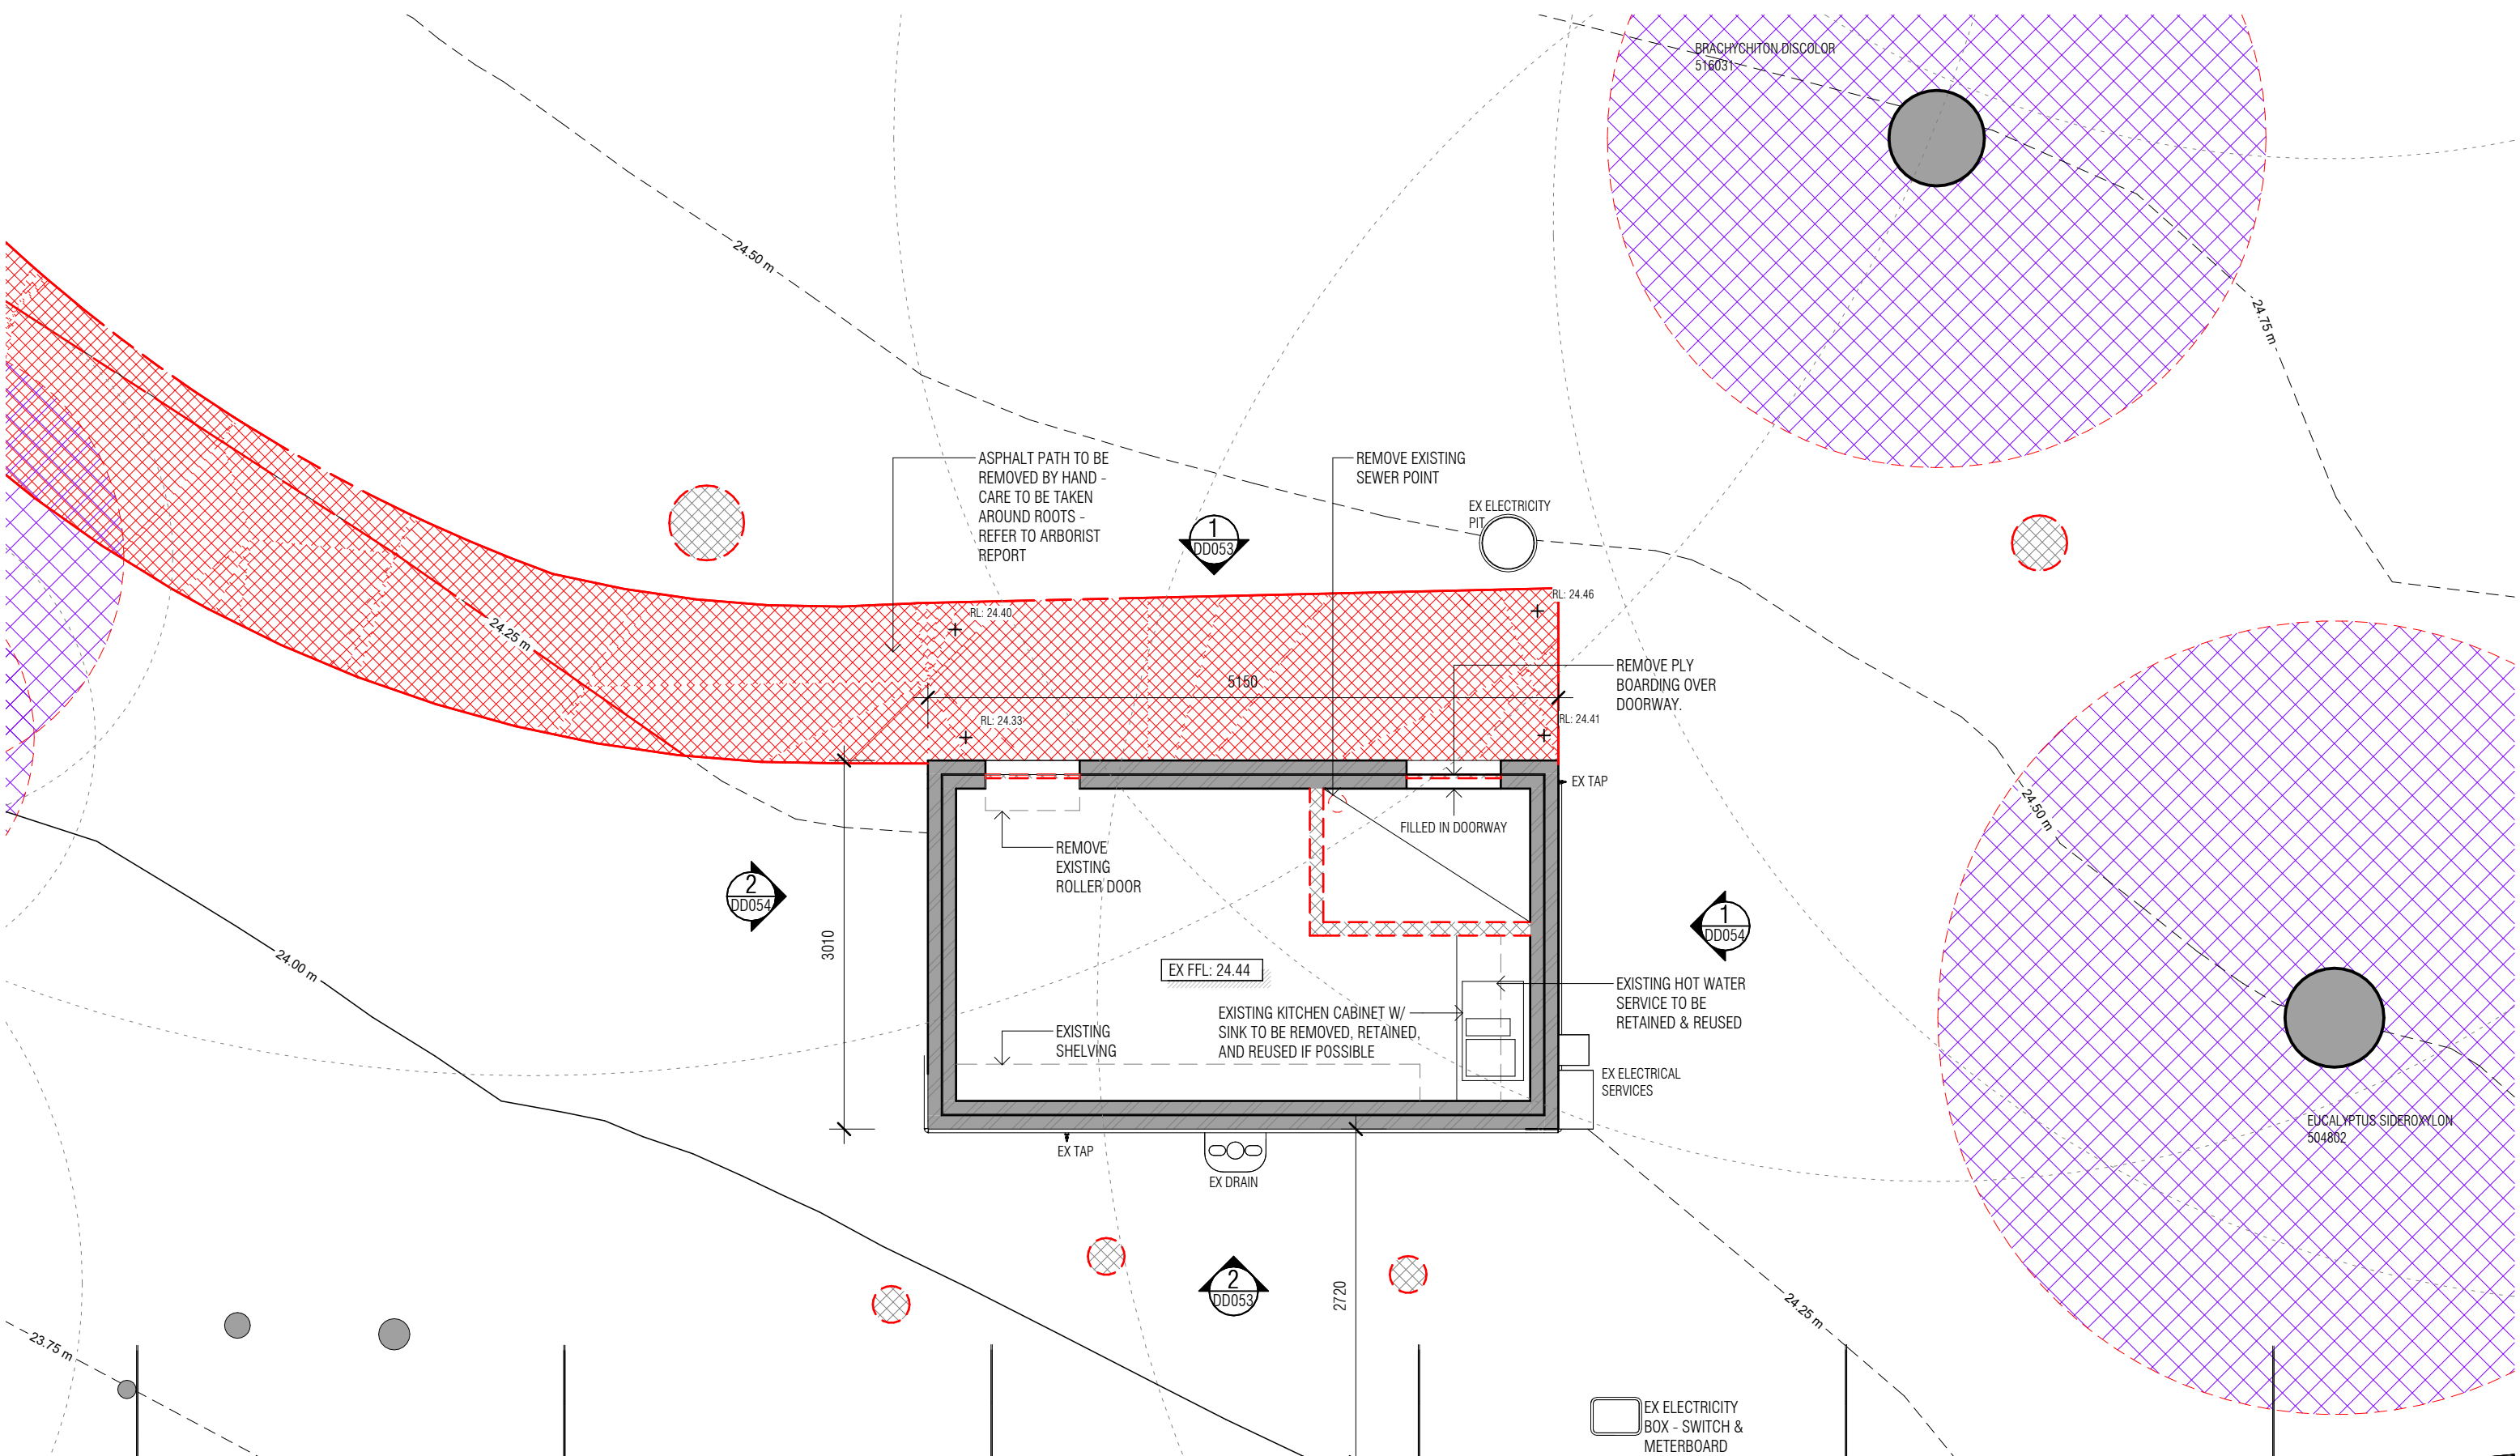

1 GROUND FLOOR PLAN - EXISTING
DD053 SCALE 1 : 50

PRELIMINARY			
REV	ISSUE DATE	BY	REASON FOR ISSUE
00	22.11.24	ST	ISSUED TO DDA
01	5.02.25	ST	ISSUED TO CLIENT

- DEMOLITION
- SRZ - STRUCTURAL ROOT ZONE
- TPZ - TREE PROTECTION ZONE

ARCHITECT



SARAH LAKE ARCHITECTS
*Level 1 242 Victoria Street
BRUNSWICK VIC 3056
info@sarahlake.com.au
www.sarahlake.com.au*

PROJECT DETAILS

PROJECT: AUSTRALIAN DRYLANDS
LEARNING HUB MELBOURNE

CLIENT: RBGV

ALL WORKS TO BE CARRIED OUT TO AUSTRALIAN STANDARDS AND TO COMPLY WITH
THE BUILDING CODE OF AUSTRALIA
ALL DIMENSIONS TO BE CHECKED ON SITE PRIOR TO WORKS COMMENCING

DRAWING

TITLE: EX GROUND FLOOR PLAN
PROPOSED


SCALE: 1 : 50

JOB NUMBER: 2305


DATE: MAY 2023

DRAWN: ST


DRAWING NO: DD051

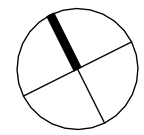

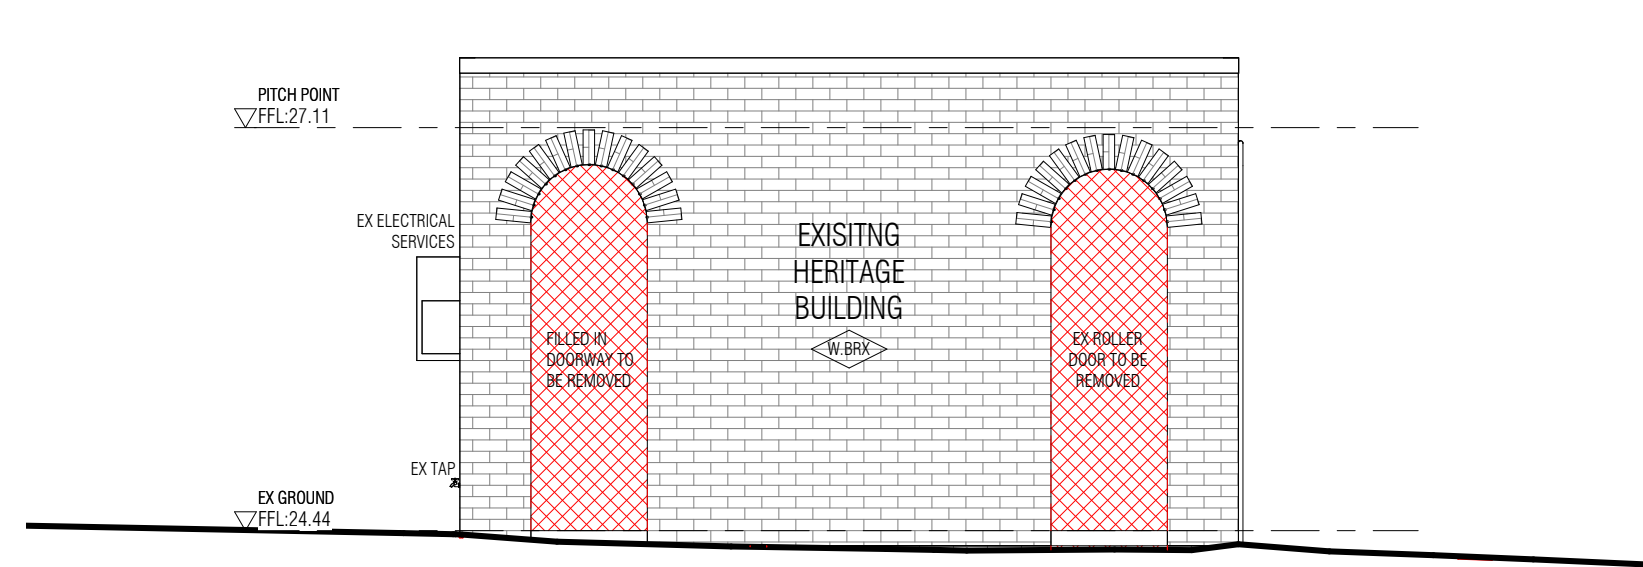


1 NORTH - EXISTING
DD050 SCALE 1 : 50

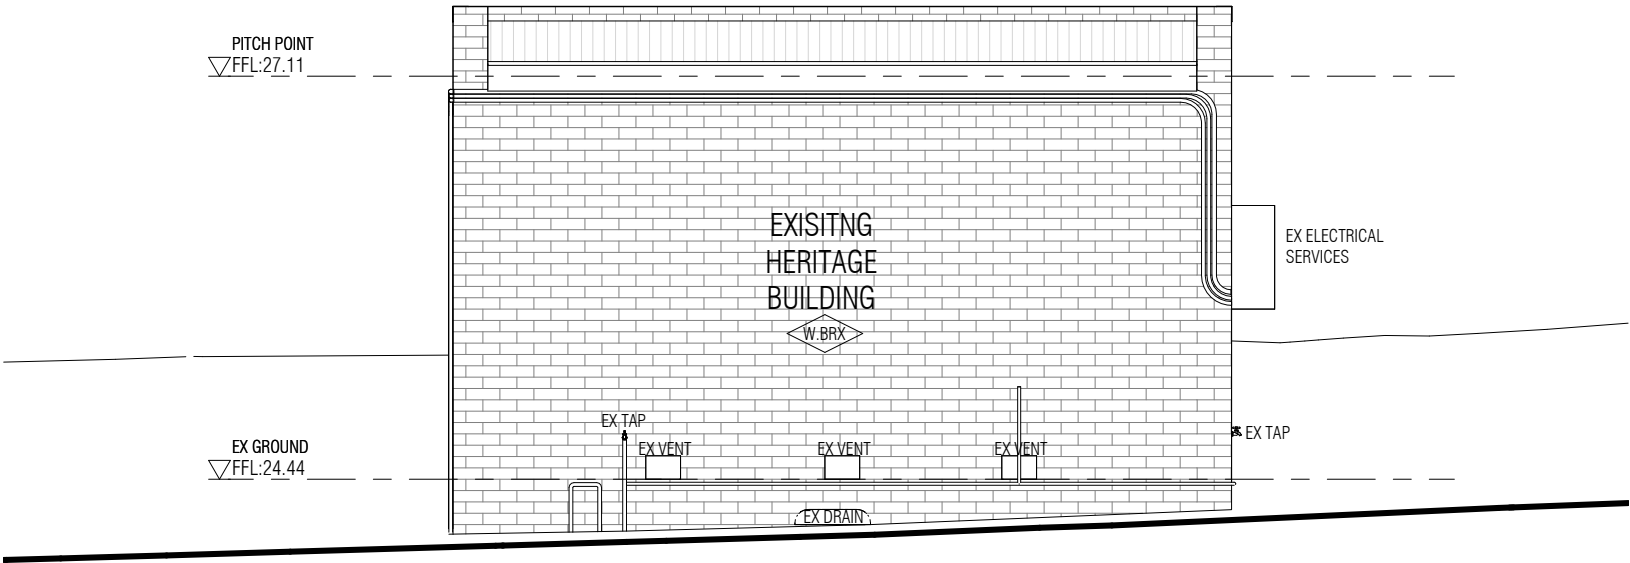


2 SOUTH - EXISTING
DD050 SCALE 1 : 50



PRELIMINARY			
REV	ISSUE DATE	BY	REASON FOR ISSUE
00	22.11.24	ST	ISSUED TO DDA
01	5.02.25	ST	ISSUED TO CLIENT

-  DEMOLITION
-  SRZ - STRUCTURAL ROOT ZONE
-  TPZ - TREE PROTECTION ZONE

ARCHITECT



SARAH LAKE ARCHITECTS

Level 1 242 Victoria Street
BRUNSWICK VIC 3056
info@sarahlake.com.au
www.sarahlake.com.au

PROJECT DETAILS

PROJECT: AUSTRALIAN DRYLANDS
LEARNING HUB MELBOURNE

CLIENT: RBGV

ALL WORKS TO BE CARRIED OUT TO AUSTRALIAN STANDARDS AND TO COMPLY WITH
THE BUILDING CODE OF AUSTRALIA
ALL DIMENSIONS TO BE CHECKED ON SITE PRIOR TO WORKS COMMENCING

DRAWING

TITLE: EX ELEVATIONS
PROPOSED

SCALE: As indicated JOB NUMBER: 2305


DATE: MAY 2023 DRAWN: ST

DRAWING NO: DD053

1

EAST - EXISTING


DD050SCALE 1 : 50

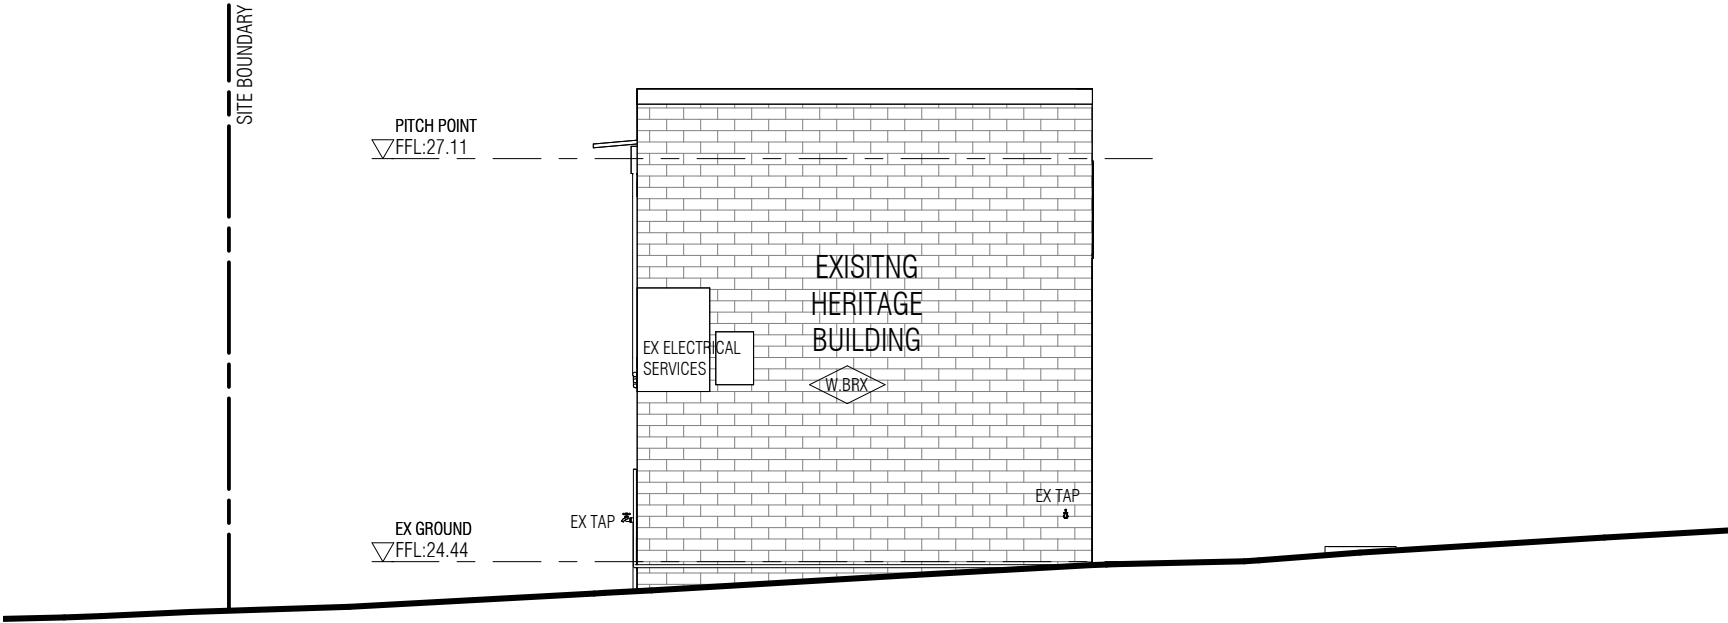

2

WEST - EXISTING

DD050SCALE 1 : 50

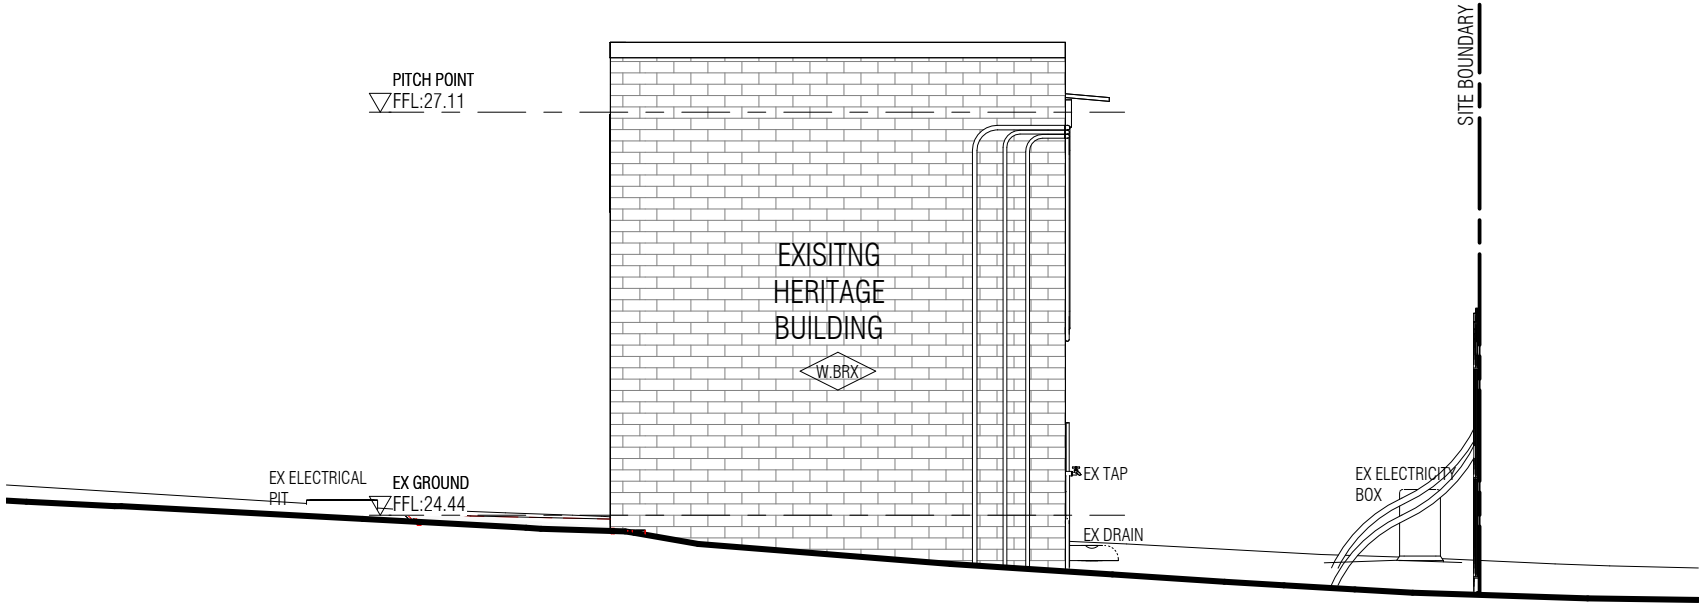

PRELIMINARY			
REV	ISSUE DATE	BY	REASON FOR ISSUE
00	5.02.25	ST	ISSUED TO CLIENT

- DEMOLITION
- SRZ - STRUCTURAL ROOT ZONE
- TPZ - TREE PROTECTION ZONE

ARCHITECT

SARAH LAKE ARCHITECTS

Level 1 242 Victoria Street
BRUNSWICK VIC 3056
info@sarahlake.com.au
www.sarahlake.com.au

PROJECT DETAILS

PROJECT: AUSTRALIAN DRYLANDS
LEARNING HUB MELBOURNE

CLIENT: RBGV


ALL WORKS TO BE CARRIED OUT TO AUSTRALIAN STANDARDS AND TO COMPLY WITH
THE BUILDING CODE OF AUSTRALIA
ALL DIMENSIONS TO BE CHECKED ON SITE PRIOR TO WORKS COMMENCING

DRAWING

TITLE: EX ELEVATIONS
PROPOSED

SCALE: As indicatedJOB NUMBER: 2305

DATE: MAY 2023DRAWN: STDRAWING NO: DD054

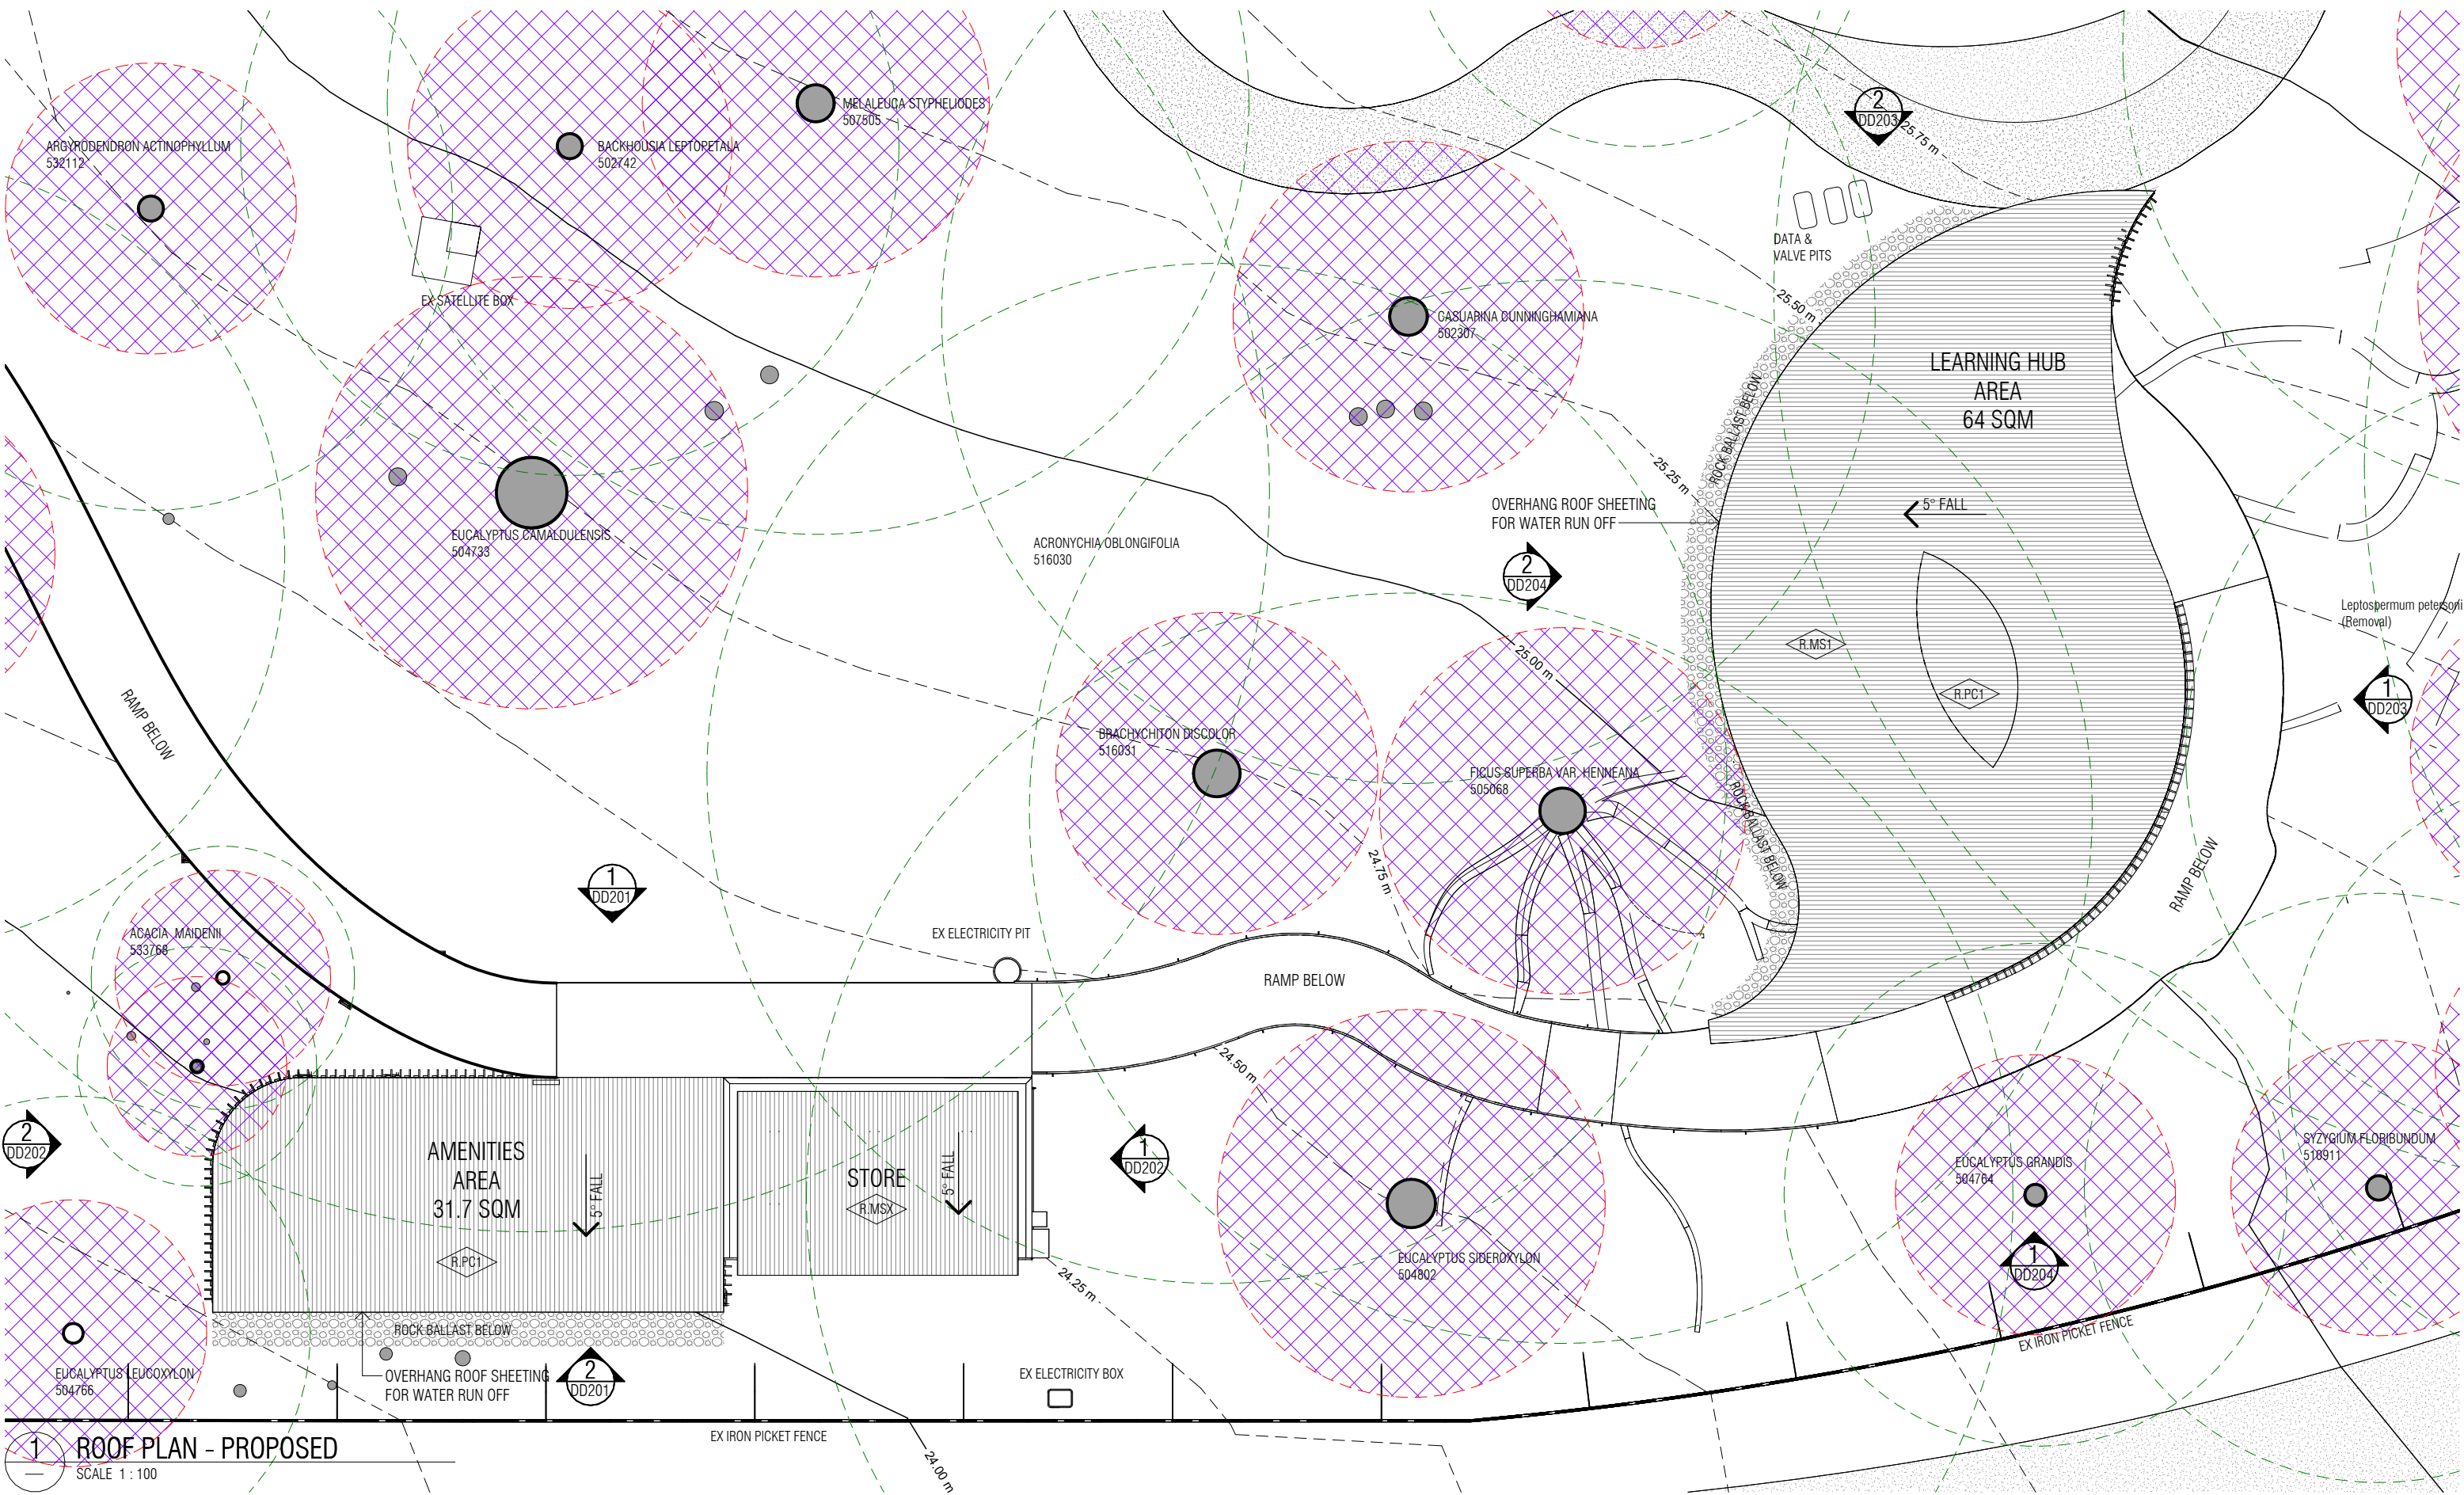

1 ROOF PLAN - PROPOSED
SCALE 1 : 100

PRELIMINARY			
REV	ISSUE DATE	BY	REASON FOR ISSUE
00	30.10.24	ST	ISSUED TO ENGINEER
01	5.02.25	ST	ISSUED TO CLIENT

LEGEND:

X.XX

DOOR, OR BALUSTRADE TAG

X.XX

WINDOW TAG

X.XX

MATERIAL & FINISHES TAG

EXISTING WALLS

PROPOSED MASONRY WALLS

PROPOSED LIGHTWEIGHT WALLS

SRZ - STRUCTURAL ROOT ZONE

TPZ - TREE PROTECTION ZONE

NOTE: EXISTING FITTINGS AND FINISHES ARE LABELED 'EX' OR 'X' AT THE END OF A TAG CODE.

ARCHITECT

SARAH LAKE ARCHITECTS

Level 1 242 Victoria Street
BRUNSWICK VIC 3056
info@sarahlake.com.au
www.sarahlake.com.au

PROJECT DETAILS

PROJECT: AUSTRALIAN DRYLANDS LEARNING HUB MELBOURNE

CLIENT: RBGV

ALL WORKS TO BE CARRIED OUT TO AUSTRALIAN STANDARDS AND TO COMPLY WITH THE BUILDING CODE OF AUSTRALIA. ALL DIMENSIONS TO BE CHECKED ON SITE PRIOR TO WORKS COMMENCING

DRAWING

TITLE: ROOF PLAN PROPOSED



SCALE: 1 : 100

DATE: MAY 2023

JOB NUMBER: 2305

DRAWN: ST

DRAWING NO: DD103

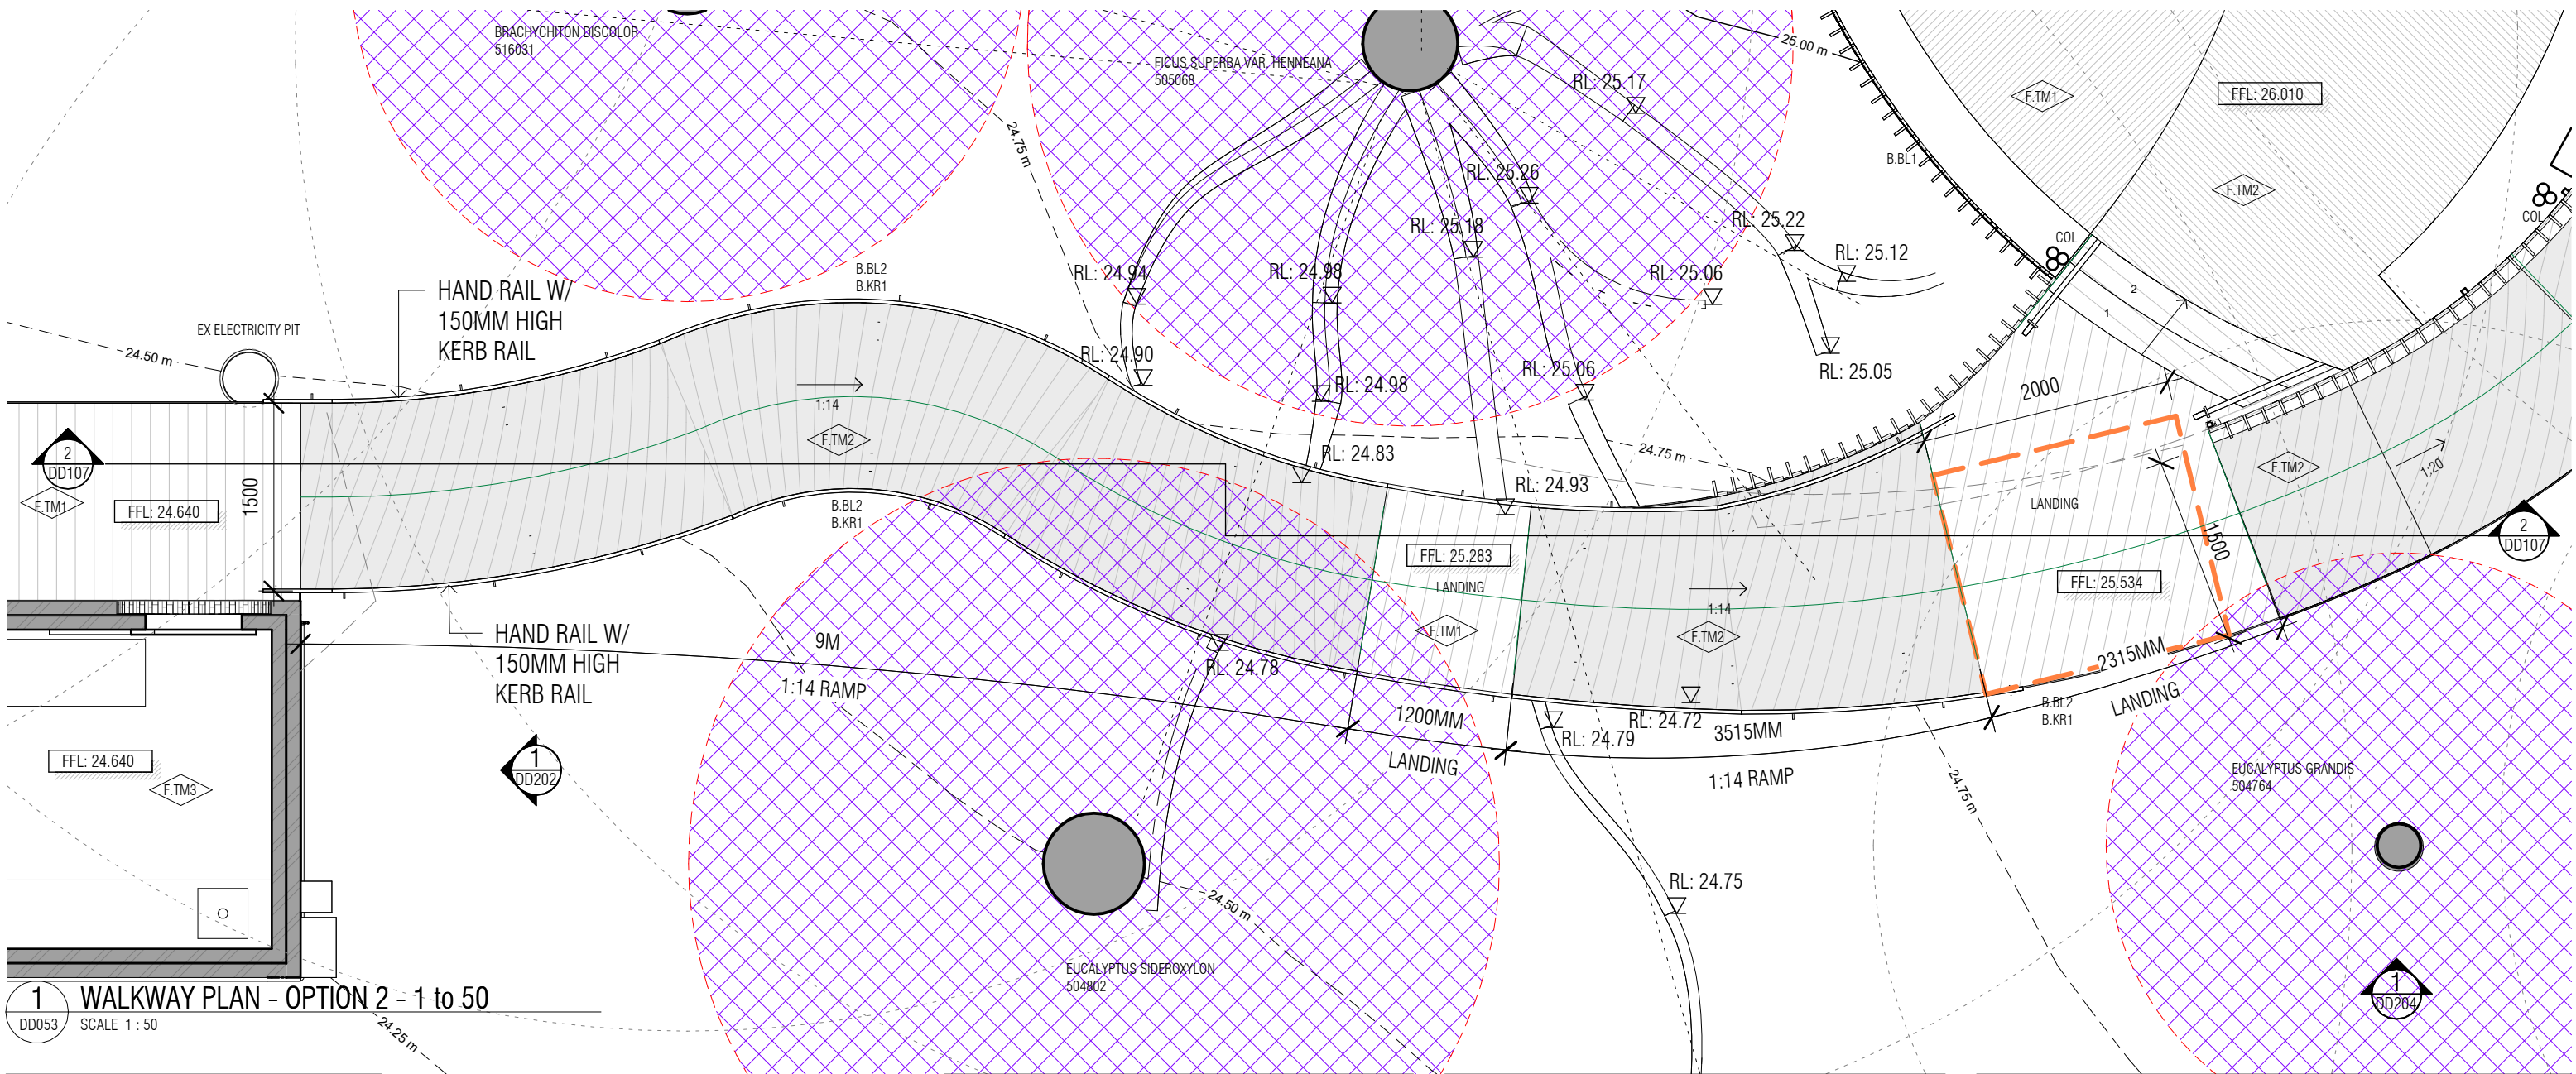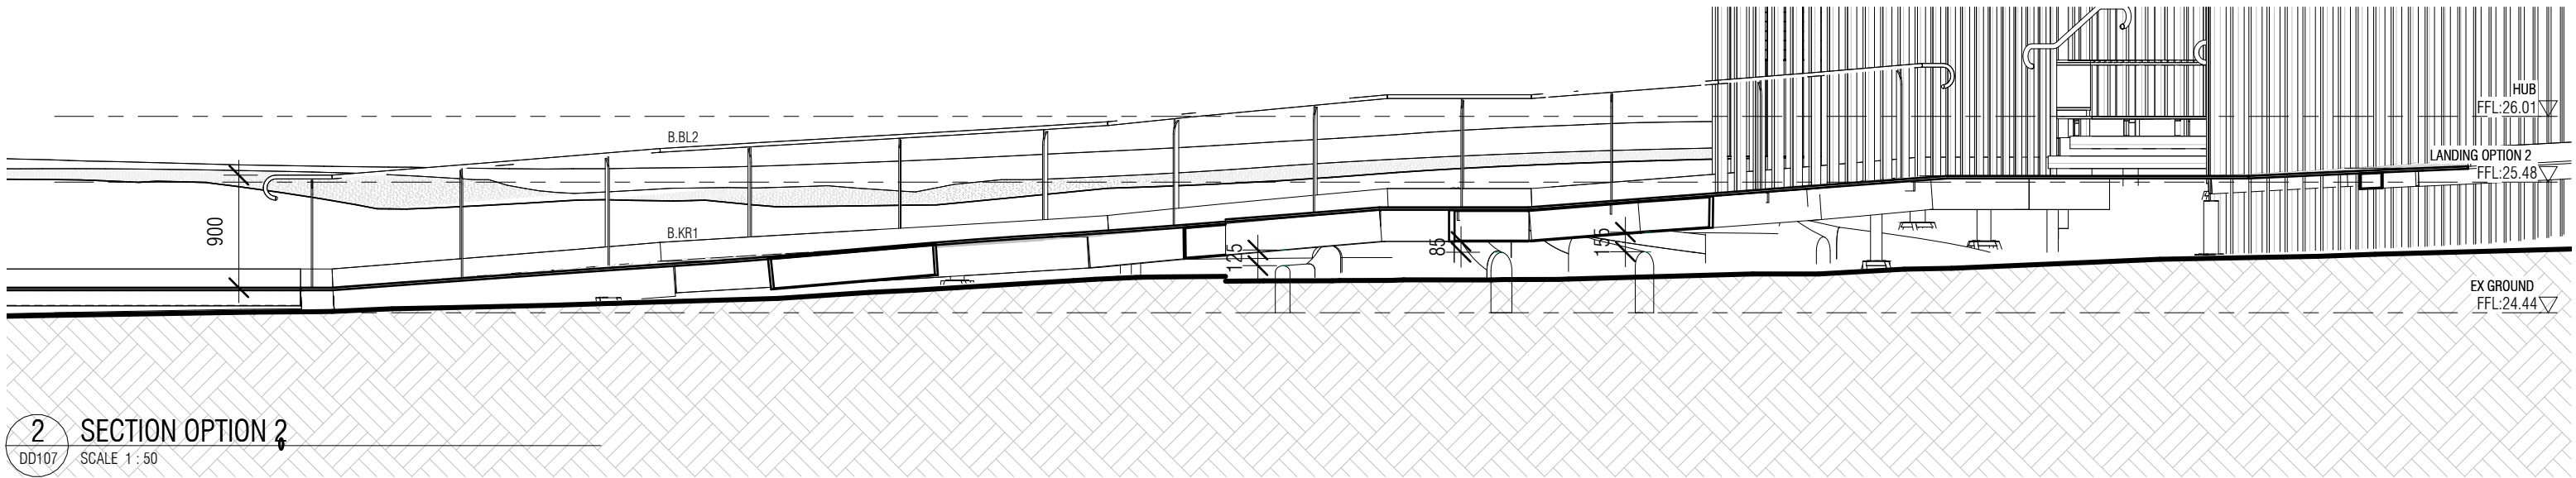

PRELIMINARY

REV	ISSUE DATE	BY	REASON FOR ISSUE
00	10.01.25	ST	ISSUED TO CLIENT
01	5.02.25	ST	ISSUED TO CLIENT

LEGEND:

X.XX	DOOR, OR BALUSTRADE TAG
X.XX	WINDOW TAG
X.XX	MATERIAL & FINISHES TAG

EXISTING WALLS
PROPOSED MASONRY WALLS
PROPOSED LIGHTWEIGHT WALLS

SRZ - STRUCTURAL ROOT ZONE
TPZ - TREE PROTECTION ZONE

NOTE: EXISTING FITTINGS AND FINISHES ARE LABELED 'EX' OR 'X' AT THE END OF A TAG CODE.

ARCHITECT



SARAH LAKE ARCHITECTS

Level 1 242 Victoria Street
BRUNSWICK VIC 3056
info@sarahlake.com.au
www.sarahlake.com.au

PROJECT DETAILS

PROJECT: AUSTRALIAN DRYLANDS
LEARNING HUB MELBOURNE

CLIENT: RBGV

ALL WORKS TO BE CARRIED OUT TO AUSTRALIAN STANDARDS AND TO COMPLY WITH
THE BUILDING CODE OF AUSTRALIA
ALL DIMENSIONS TO BE CHECKED ON SITE PRIOR TO WORKS COMMENCING

DRAWING

TITLE: RAMP - PROPOSED
PROPOSED

SCALE: JOB NUMBER:


1:50 2305

DATE: DRAWN:

MAY 2023 ST

DRAWING NO:

DD107

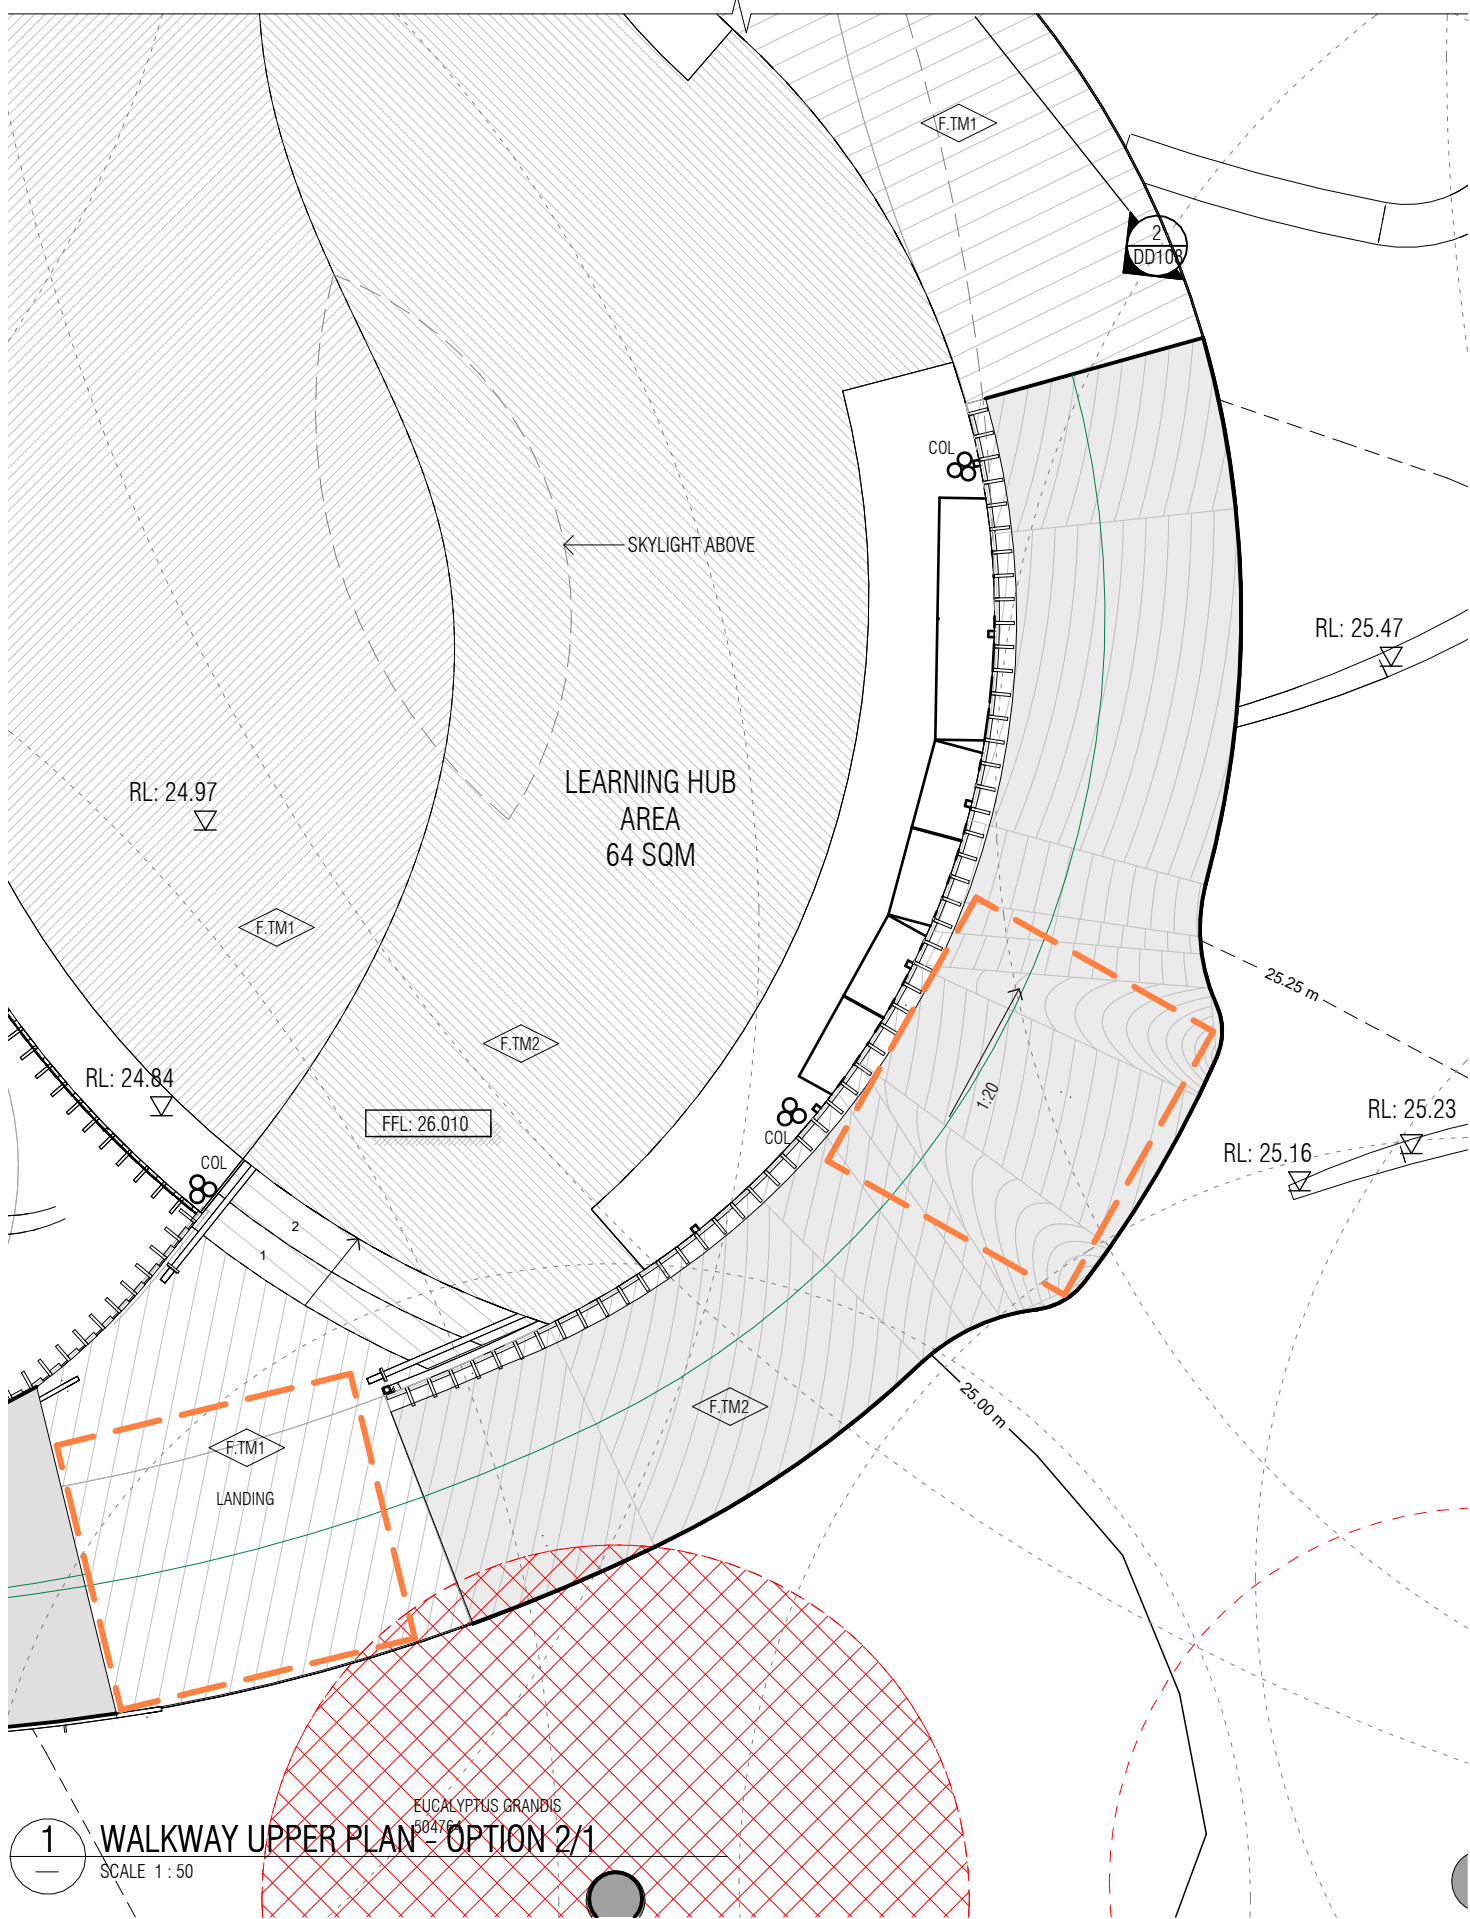

1 WALKWAY UPPER PLAN - OPTION 2/1
SCALE 1 : 50

PRELIMINARY			
REV	ISSUE DATE	BY	REASON FOR ISSUE
00	10.01.25	ST	ISSUED TO CLIENT
01	5.02.25	ST	ISSUED TO CLIENT

LEGEND:

X.XX

DOOR, OR BALUSTRADE TAG

X.XX

WINDOW TAG

X.XX

MATERIAL & FINISHES TAG

EXISTING WALLS


PROPOSED MASONRY WALLS

PROPOSED LIGHTWEIGHT WALLS


SRZ - STRUCTURAL ROOT ZONE

TPZ - TREE PROTECTION ZONE

NOTE: EXISTING FITTINGS AND FINISHES ARE LABELED 'EX' OR 'X' AT THE END OF A TAG CODE.

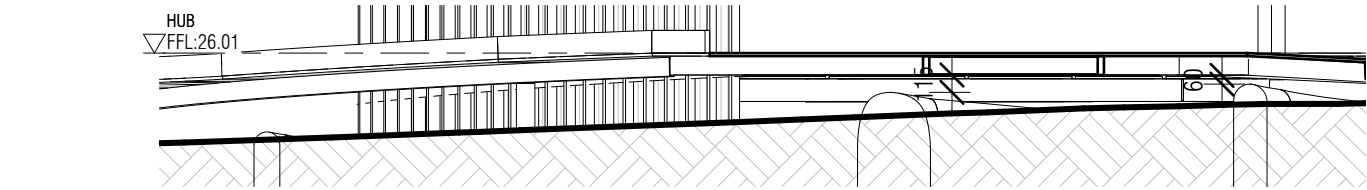

2 SECTION UPPER - OPTION 2
SCALE 1 : 50

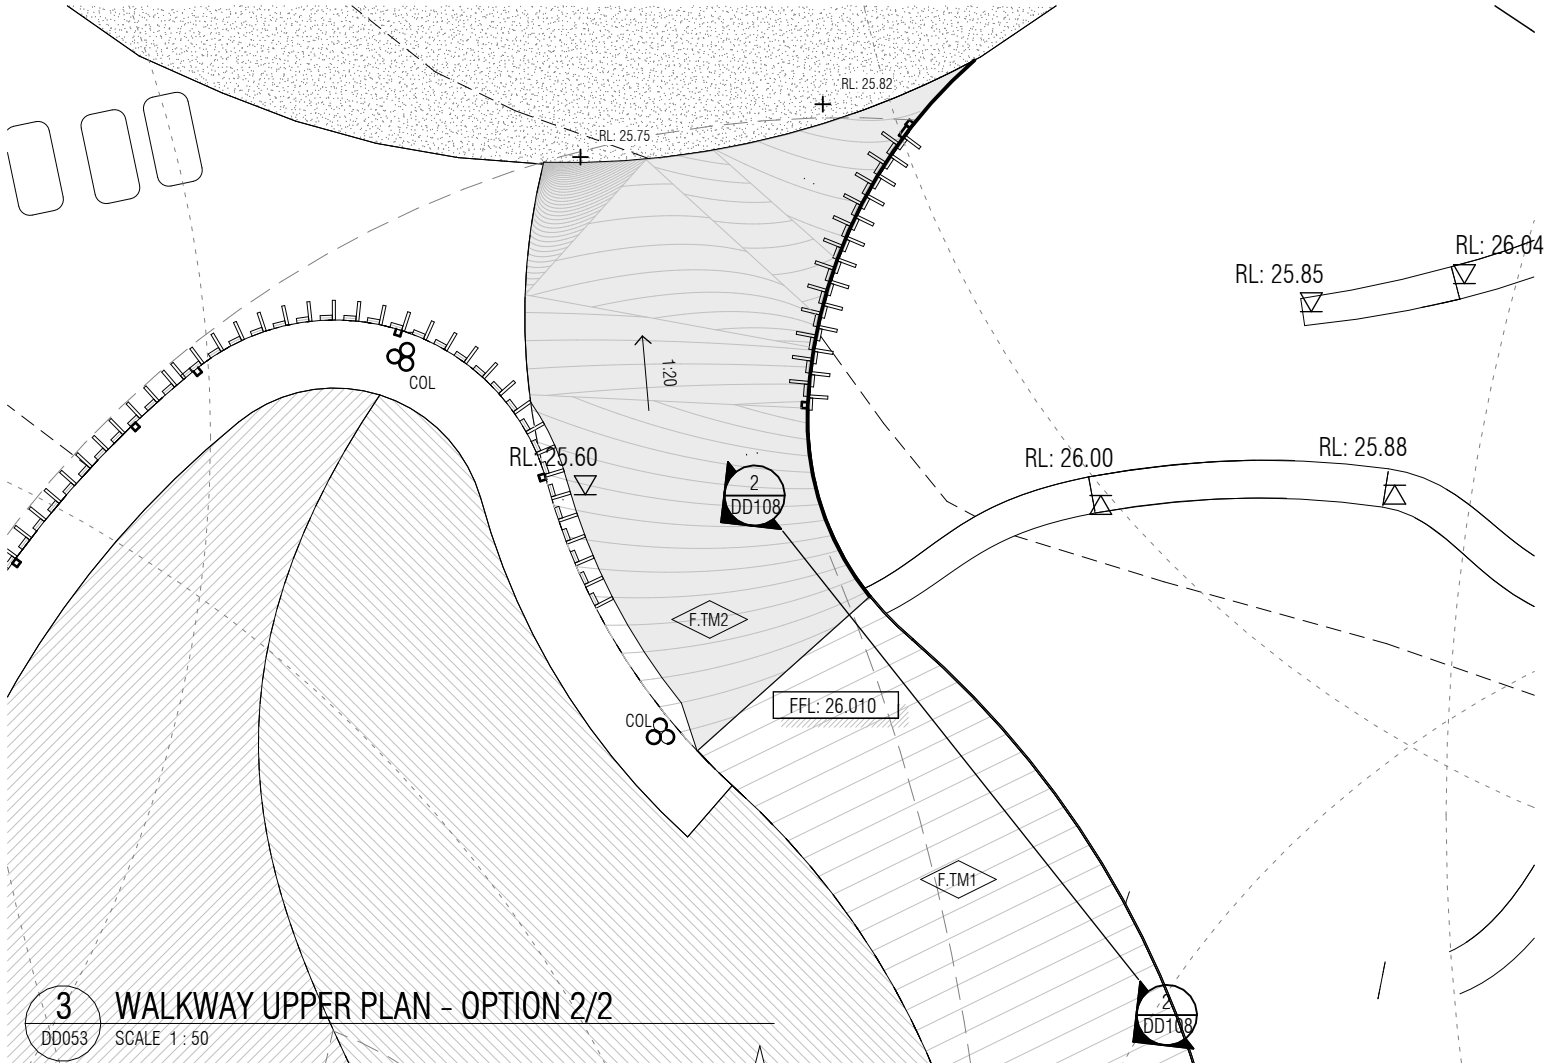

3 WALKWAY UPPER PLAN - OPTION 2/2
SCALE 1 : 50

ARCHITECT

SARAH LAKE ARCHITECTS

Level 1 242 Victoria Street
BRUNSWICK VIC 3056
info@sarahlake.com.au
www.sarahlake.com.au

PROJECT DETAILS

PROJECT: AUSTRALIAN DRYLANDS
LEARNING HUB MELBOURNE

CLIENT: RBGV

ALL WORKS TO BE CARRIED OUT TO AUSTRALIAN STANDARDS AND TO COMPLY WITH
THE BUILDING CODE OF AUSTRALIA
ALL DIMENSIONS TO BE CHECKED ON SITE PRIOR TO WORKS COMMENCING


DRAWING

TITLE: RAMP UPPER - PROPOSED
PROPOSED

SCALE: 1 : 50
DATE: MAY 2023

JOB NUMBER: 2305
DRAWN: ST

DRAWING NO: DD108

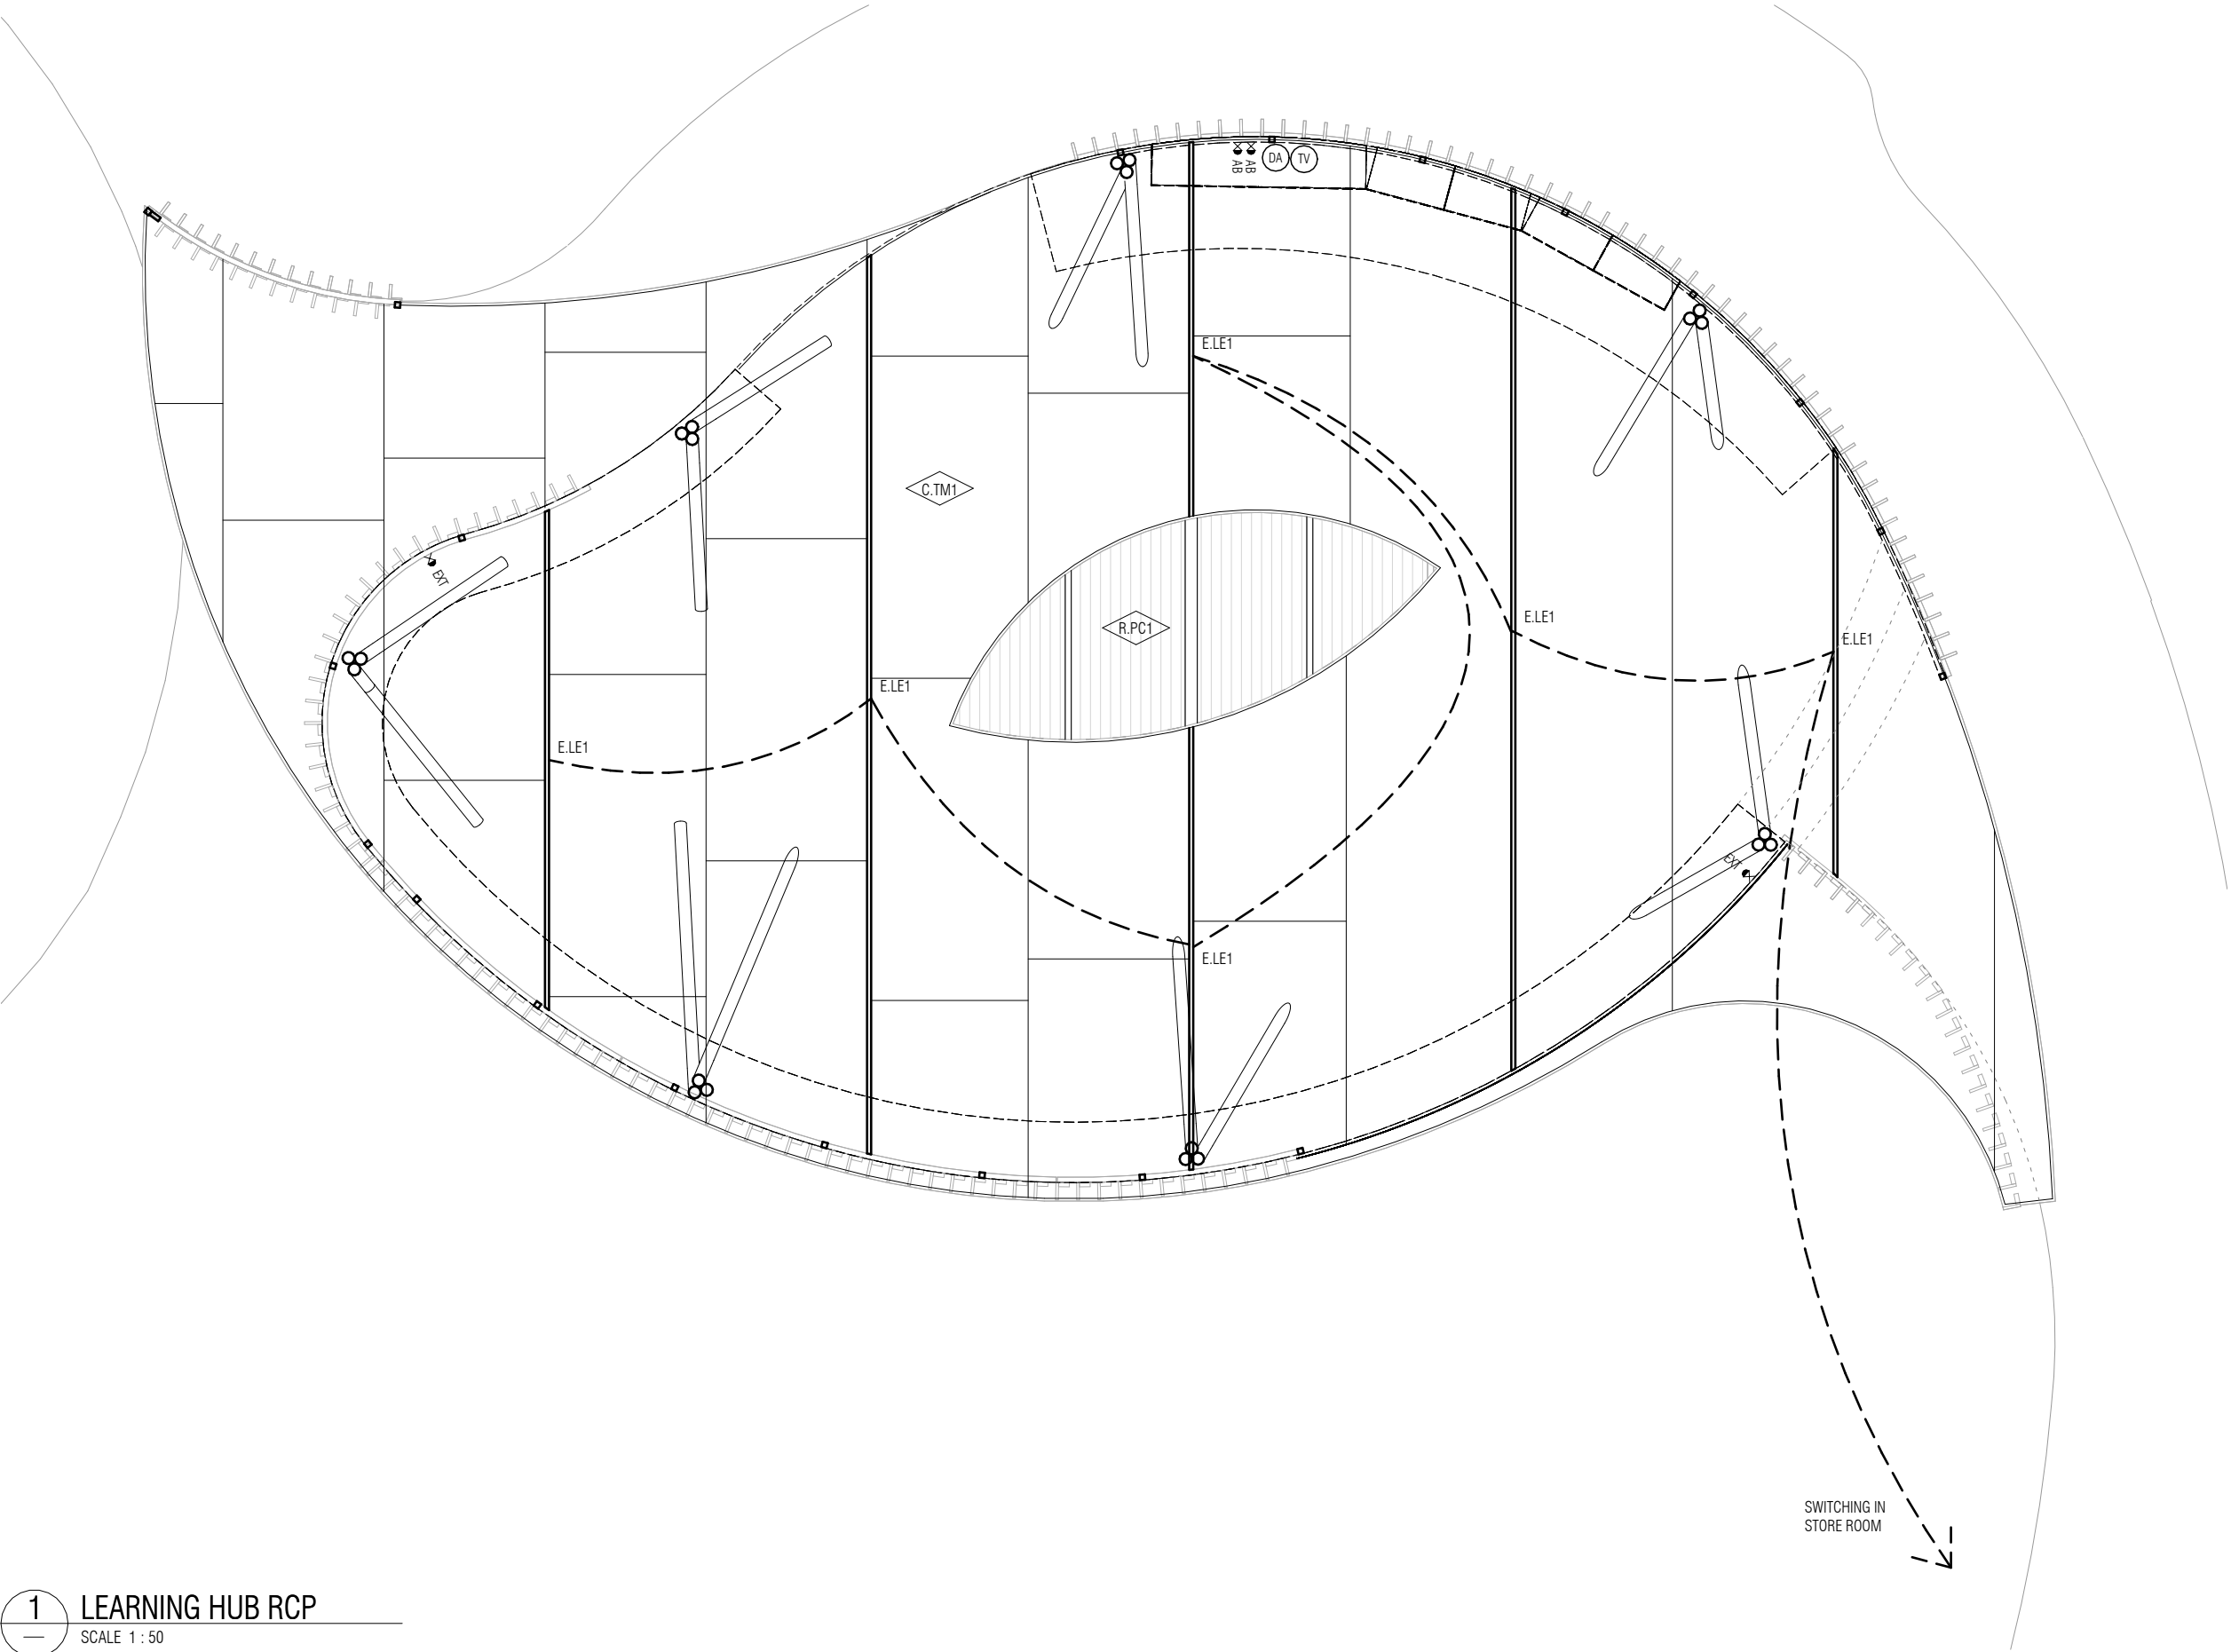

NOTES

1. REFER TO ELECTRICAL & APPLIANCES SCHEDULE FOR FITTING DETAILS
2. CONFIRM WITH GARDENS REGARDING CONNECTION TO UNDERGROUND POWER.
3. ALLOW TO CONNECT AND INSTALL ALL APPLIANCES. REFER TO ELECTRICAL SCHEDULE FOR DETAILS
4. CONFIRM LOCATION OF ALL FITTINGS ON SITE PRIOR TO INSTALLATION
5. SERVICES ENGINEER TO CONFIRM WITH GARDENS AND COUNCIL ANY LIGHT POLLUTION REQUIREMENTS.
6. BUILDER TO SALVAGE EXISTING LIGHT FITTINGS, SWITCHES FOR REUSE.
7. BUILDER TO PATCH AND MAKE GOOD CEILINGS WHERE ALTERED AS PART OF RENOVATION OR CHANGES TO FITTINGS.

LEGEND

- E.SL - SPOT LIGHT WITH SENSOR
- E.DL - DOWNLIGHT
- E.SM - SURFACE MOUNTED LIGHT
- TELEVISION POINT
- DATA POINT
- SMOKE DETECTOR, HARD WIRED TO COMPLY WITH AS3786-2014
ALL DETECTORS TO BE INTERLINKED
- E.LE - LINEAR LIGHT FITTING
- SWITCH, CLIPSAL SERIES
- SWITCH WITH DIMMER, CLIPSAL SERIES
(FLUORESCENTS REQUIRE DIMABLE BALLAST)
- EXHAUST FAN TO BE DUCTED TO OUTSIDE AIR
WITH BACKDRAUGHT PREVENTION
- METER BOARD
- SWITCHBOARD - UPGRADE REQUIRED
FOR INCREASED LOAD.
- DOUBLE GPO (HEIGHT)
EXT - EXTERNAL WEATHER PROOF
UB - UNDERBENCH
AB - ABOVE BENCH
E.USB - USB PORTS
ALLOW FOR CONCEALED GPOS FOR ALL APPLIANCES
GENERALLY CLIPSAL 2000 SERIES

1 LEARNING HUB RCP

SCALE 1 : 50

REV	ISSUE DATE	BY	REASON FOR ISSUE
00	5.02.25	ST	ISSUED TO CLIENT

ARCHITECT

SARAH LAKE ARCHITECTS

Level 1 242 Victoria Street
BRUNSWICK VIC 3056
info@sarahlake.com.au
www.sarahlake.com.au

PROJECT DETAILS

PROJECT: **AUSTRALIAN DRYLANDS
LEARNING HUB MELBOURNE**

CLIENT: **RBGV**

ALL WORKS TO BE CARRIED OUT TO AUSTRALIAN STANDARDS AND TO COMPLY WITH
THE BUILDING CODE OF AUSTRALIA
ALL DIMENSIONS TO BE CHECKED ON SITE PRIOR TO WORKS COMMENCING


DRAWING

TITLE: **LEARNING HUB RCP
PROPOSED**

SCALE: **1 : 50** JOB NUMBER: **2305**

DATE: **MAY 2023** DRAWN: **ST**

DRAWING NO: **DD151**

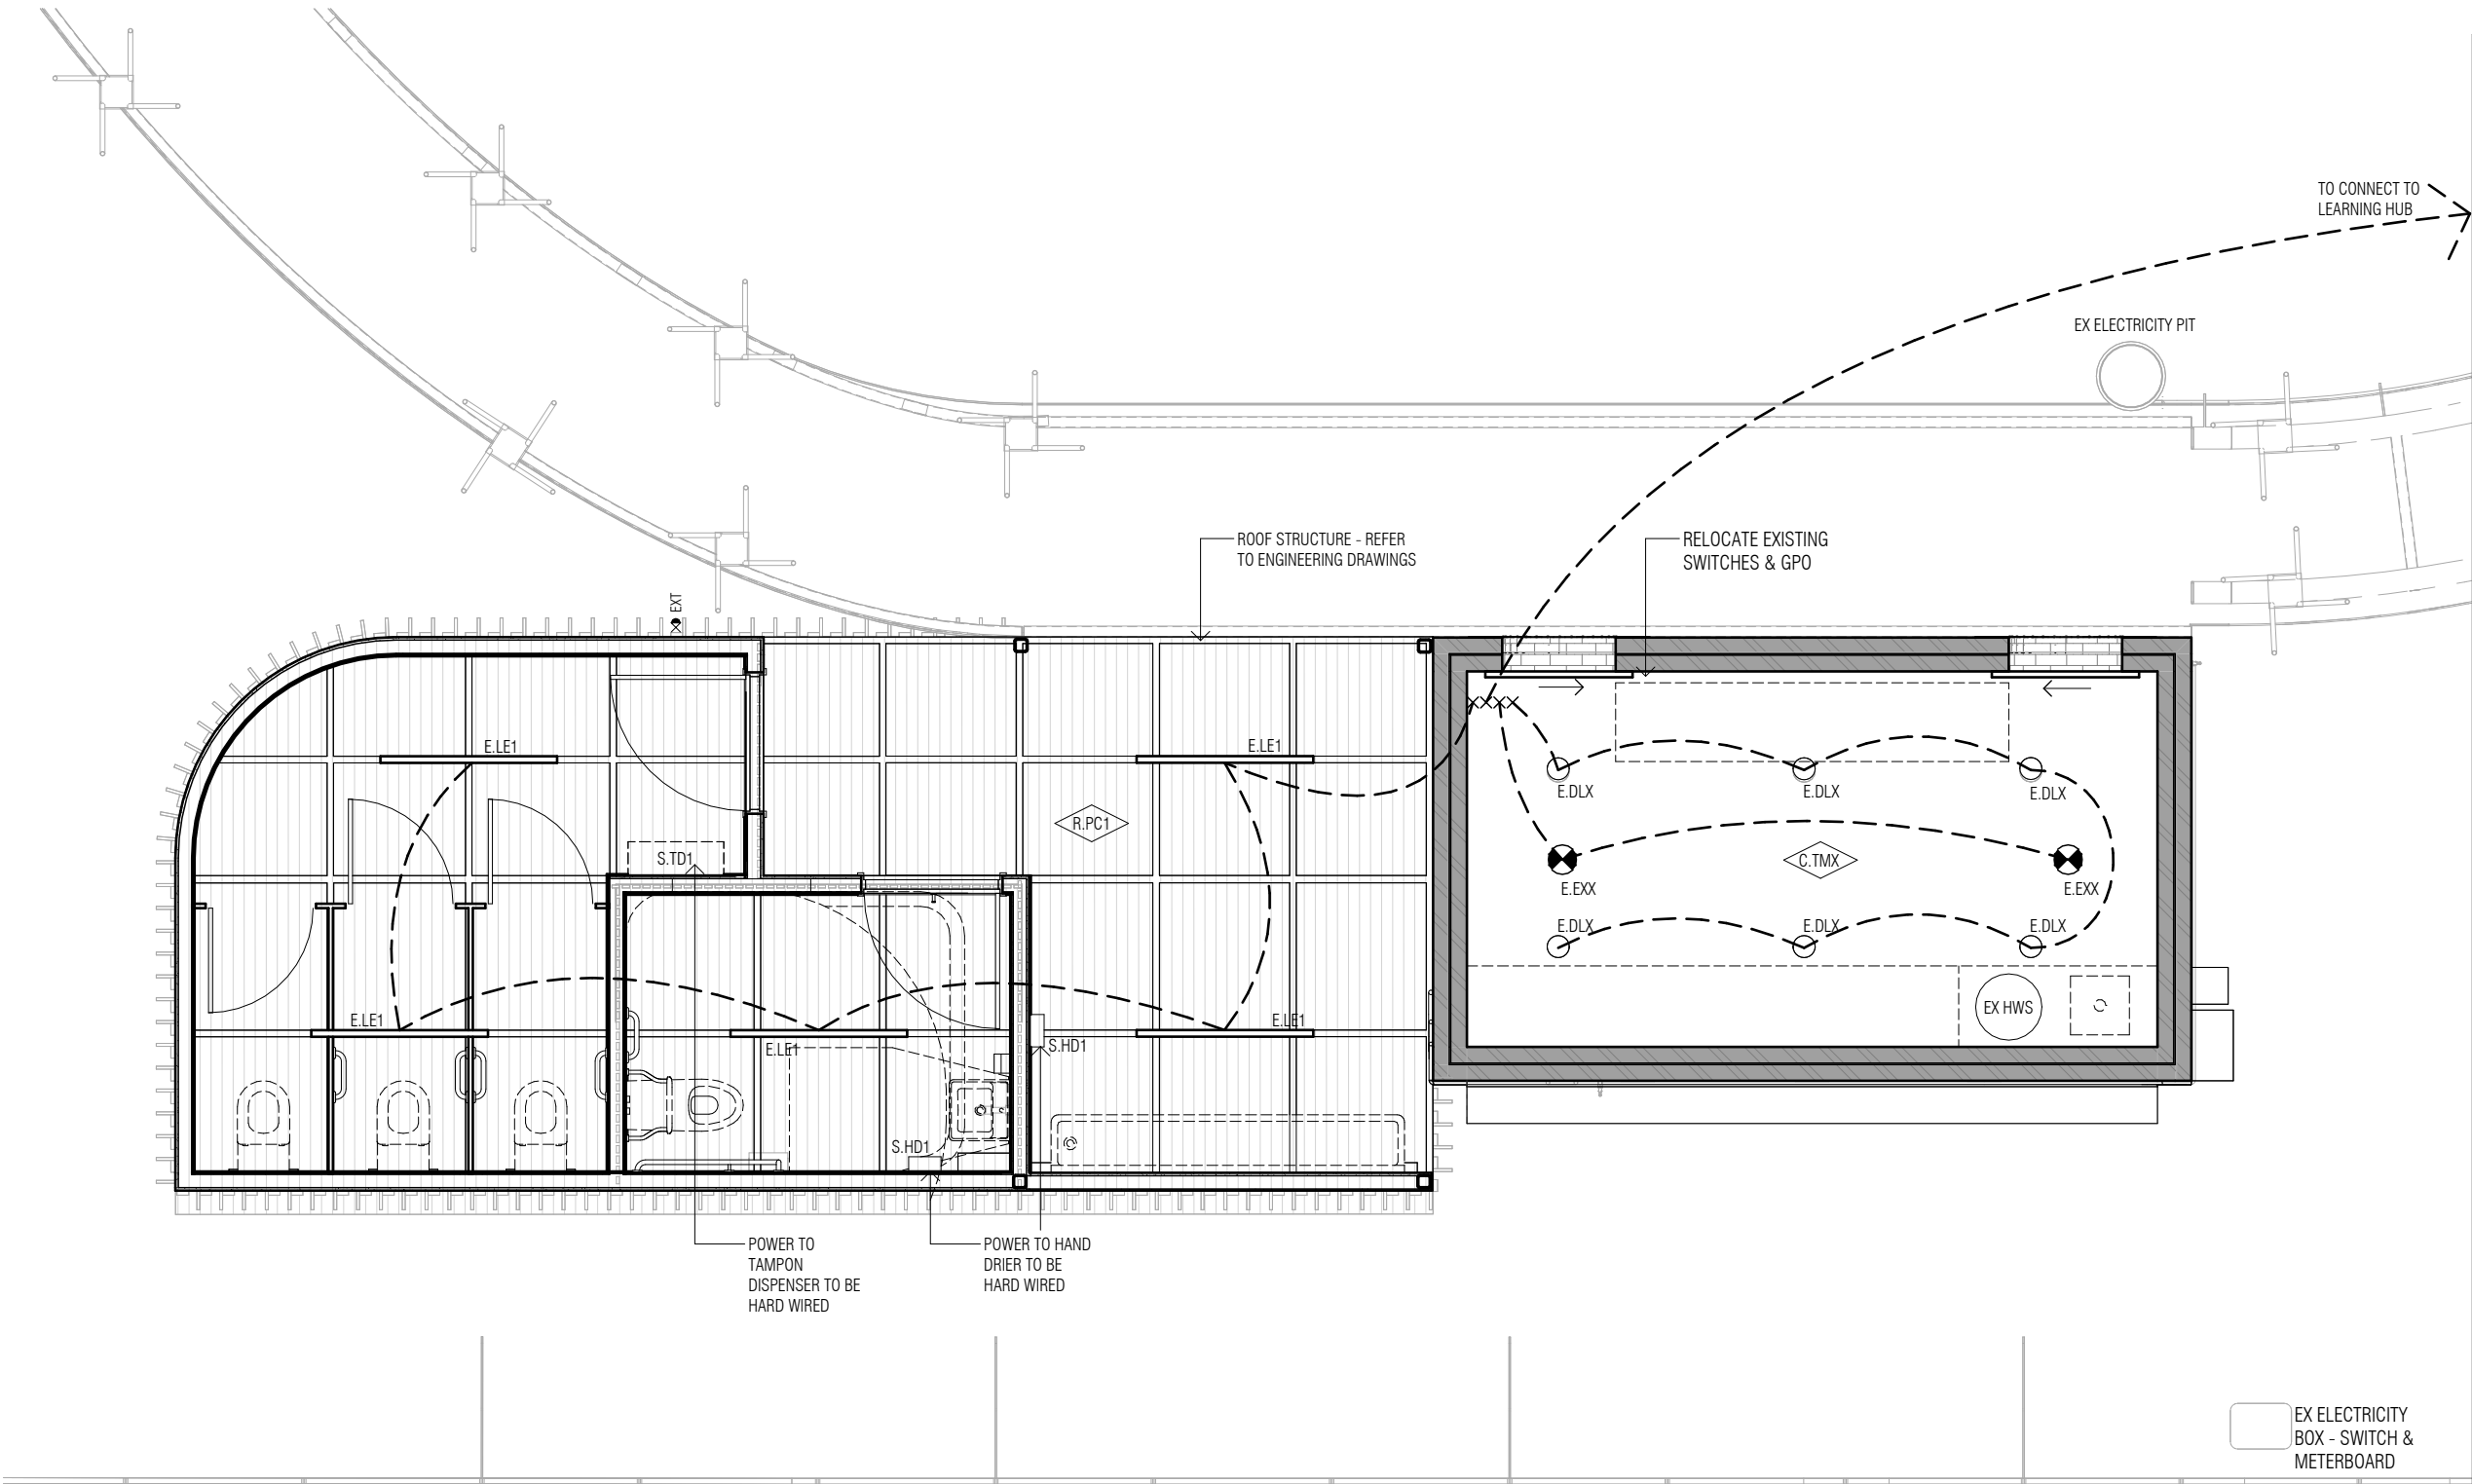

- NOTES
1. REFER TO ELECTRICAL & APPLIANCES SCHEDULE FOR FITTING DETAILS
 2. CONFIRM WITH GARDENS REGARDING CONNECTION TO UNDERGROUND POWER.
 3. ALLOW TO CONNECT AND INSTALL ALL APPLIANCES. REFER TO ELECTRICAL SCHEDULE FOR DETAILS
 4. CONFIRM LOCATION OF ALL FITTINGS ON SITE PRIOR TO INSTALLATION
 5. SERVICES ENGINEER TO CONFIRM WITH GARDENS AND COUNCIL ANY LIGHT POLLUTION REQUIREMENTS.
 6. BUILDER TO SALVAGE EXISTING LIGHT FITTINGS, SWITCHES FOR REUSE.
 7. BUILDER TO PATCH AND MAKE GOOD CEILINGS WHERE ALTERED AS PART OF RENOVATION OR CHANGES TO FITTINGS.

- LEGEND
- E.SL - SPOT LIGHT WITH SENSOR
 - E.DL - DOWNLIGHT
 - E.SM - SURFACE MOUNTED LIGHT
 - TELEVISION POINT
 - DATA POINT
 - SMOKE DETECTOR, HARD WIRED TO COMPLY WITH AS3786-2014 ALL DETECTORS TO BE INTERLINKED
 - E.LE - LINEAR LIGHT FITTING
 - SWITCH, CLIPSAL SERIES
 - SWITCH WITH DIMMER, CLIPSAL SERIES (FLUORESCENTS REQUIRE DIMABLE BALLAST)
 - EXHAUST FAN TO BE DUCTED TO OUTSIDE AIR WITH BACKDRAUGHT PREVENTION
 - METER BOARD
 - SWITCHBOARD - UPGRADE REQUIRED FOR INCREASED LOAD.
 - DOUBLE GPO (HEIGHT)
 - EXT - EXTERNAL WEATHER PROOF
 - UB - UNDERBENCH
 - AB - ABOVE BENCH
 - E.USB - USB PORTS
 - ALLOW FOR CONCEALED GPOS FOR ALL APPLIANCES
 - GENERALLY CLIPSAL 2000 SERIES

1 AMENITIES RCP

PRELIMINARY

REV	ISSUE DATE	BY	REASON FOR ISSUE
00	5.02.25	ST	ISSUED TO CLIENT

ARCHITECT



SARAH LAKE ARCHITECTS

Level 1 242 Victoria Street
BRUNSWICK VIC 3056
info@sarahlake.com.au
www.sarahlake.com.au

PROJECT DETAILS

PROJECT: AUSTRALIAN DRYLANDS
LEARNING HUB MELBOURNE

CLIENT: RBGV

ALL WORKS TO BE CARRIED OUT TO AUSTRALIAN STANDARDS AND TO COMPLY WITH
THE BUILDING CODE OF AUSTRALIA
ALL DIMENSIONS TO BE CHECKED ON SITE PRIOR TO WORKS COMMENCING

DRAWING

TITLE: AMENITIES RCP
PROPOSED

SCALE:

1 : 50

DATE:

MAY 2023

JOB NUMBER:


2305

DRAWN:


ST

DRAWING NO:

DD152

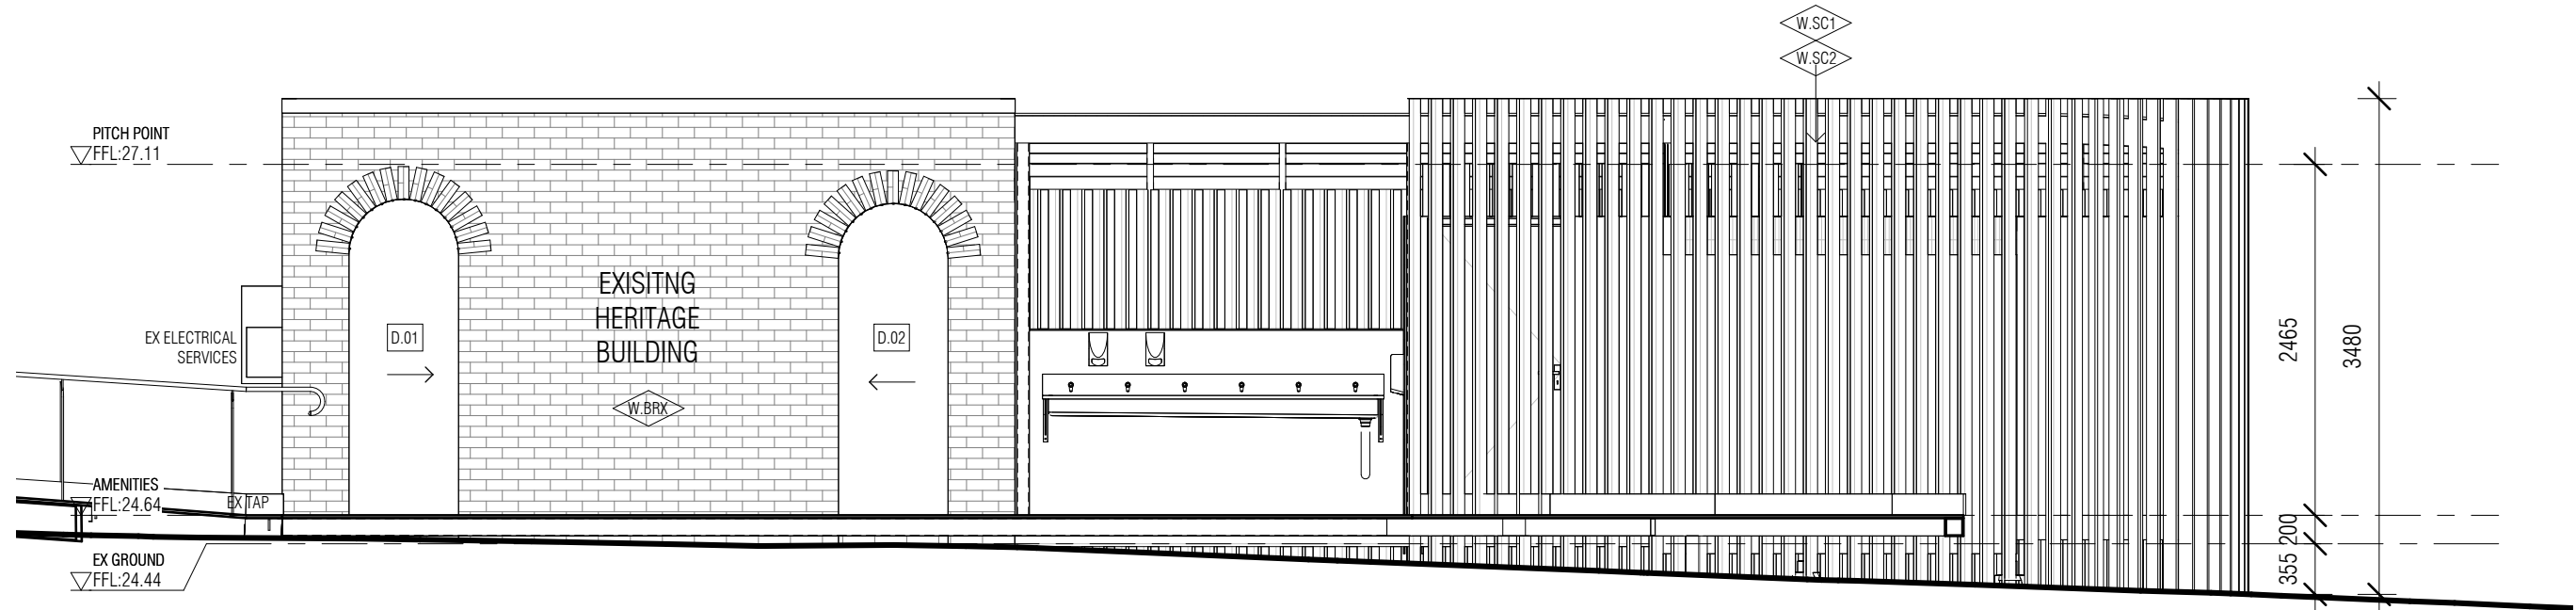

1 AMENITIES - NORTH
DD101 SCALE 1 : 50

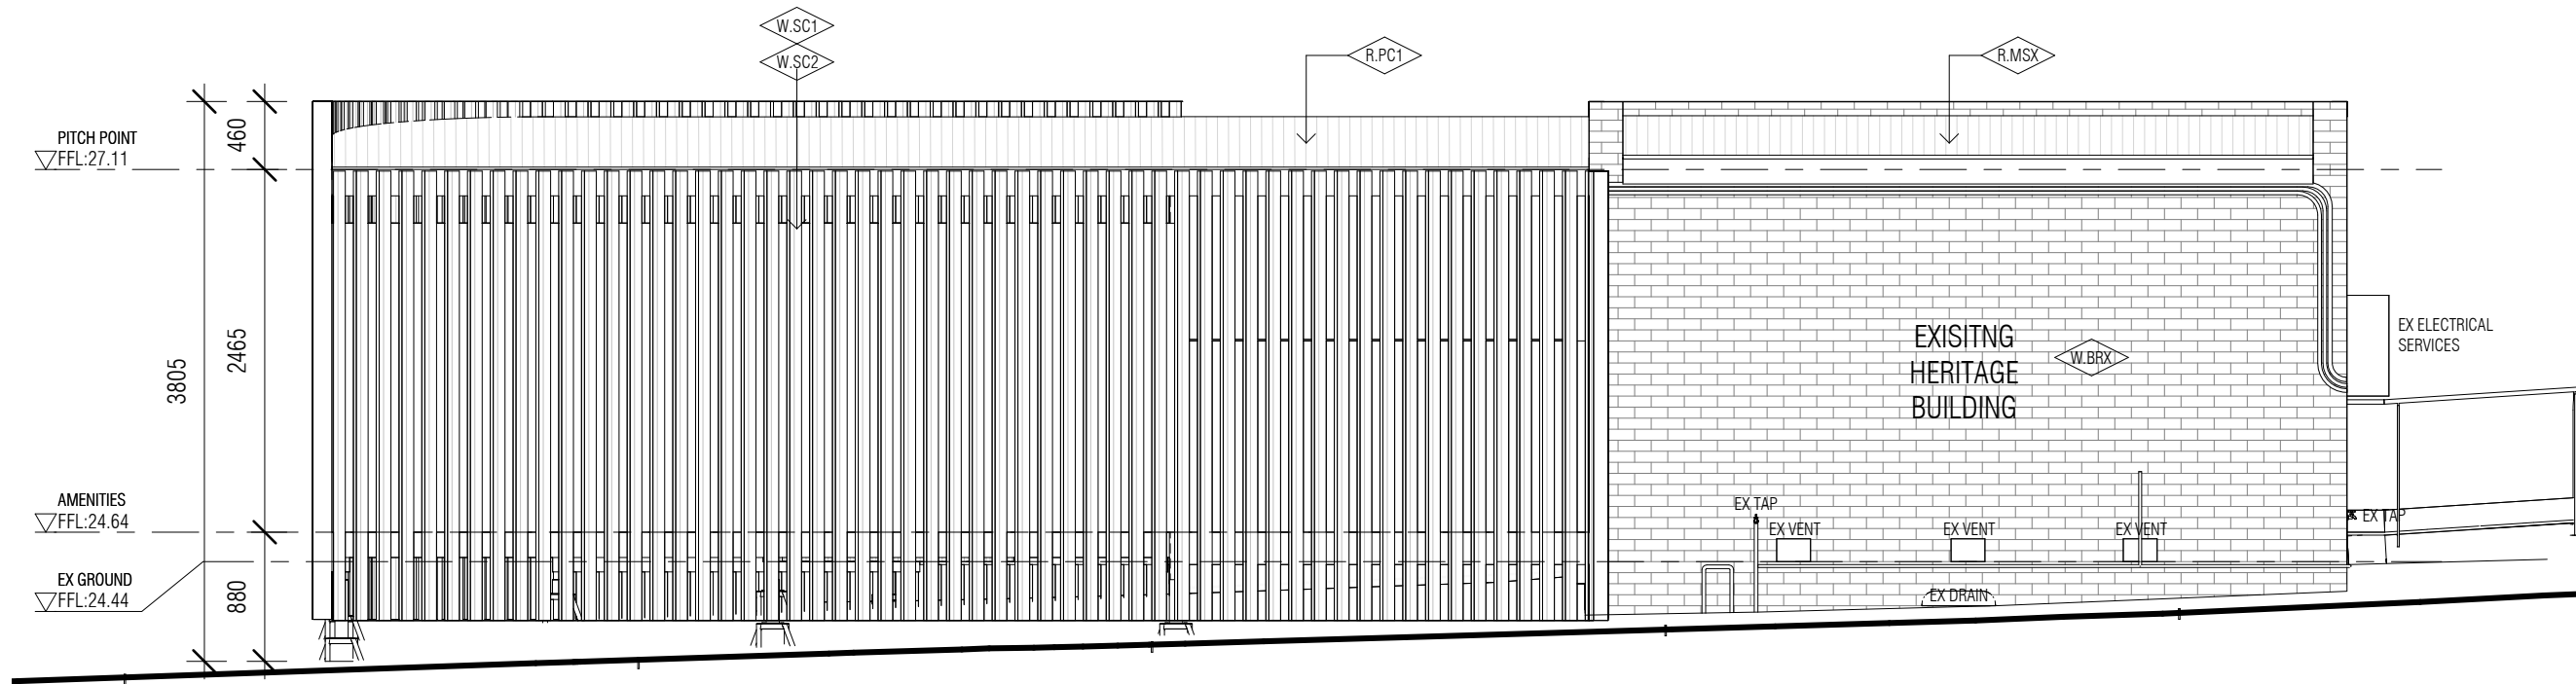

2 AMENITIES - SOUTH
DD101 SCALE 1 : 50

PRELIMINARY			
REV	ISSUE DATE	BY	REASON FOR ISSUE
00	22.11.24	ST	ISSUED TO DDA
01	5.02.25	ST	ISSUED TO CLIENT

ARCHITECT



SARAH LAKE ARCHITECTS

Level 1 242 Victoria Street
BRUNSWICK VIC 3056
info@sarahlake.com.au
www.sarahlake.com.au

PROJECT DETAILS

PROJECT: AUSTRALIAN DRYLANDS
LEARNING HUB MELBOURNE

CLIENT: RBGV

ALL WORKS TO BE CARRIED OUT TO AUSTRALIAN STANDARDS AND TO COMPLY WITH
THE BUILDING CODE OF AUSTRALIA
ALL DIMENSIONS TO BE CHECKED ON SITE PRIOR TO WORKS COMMENCING

DRAWING

TITLE: ELEVATIONS - AMENITIES
PROPOSED


SCALE: 1 : 50

JOB NUMBER: 2305


DATE: MAY 2023

DRAWN: ST

DRAWING NO: DD201

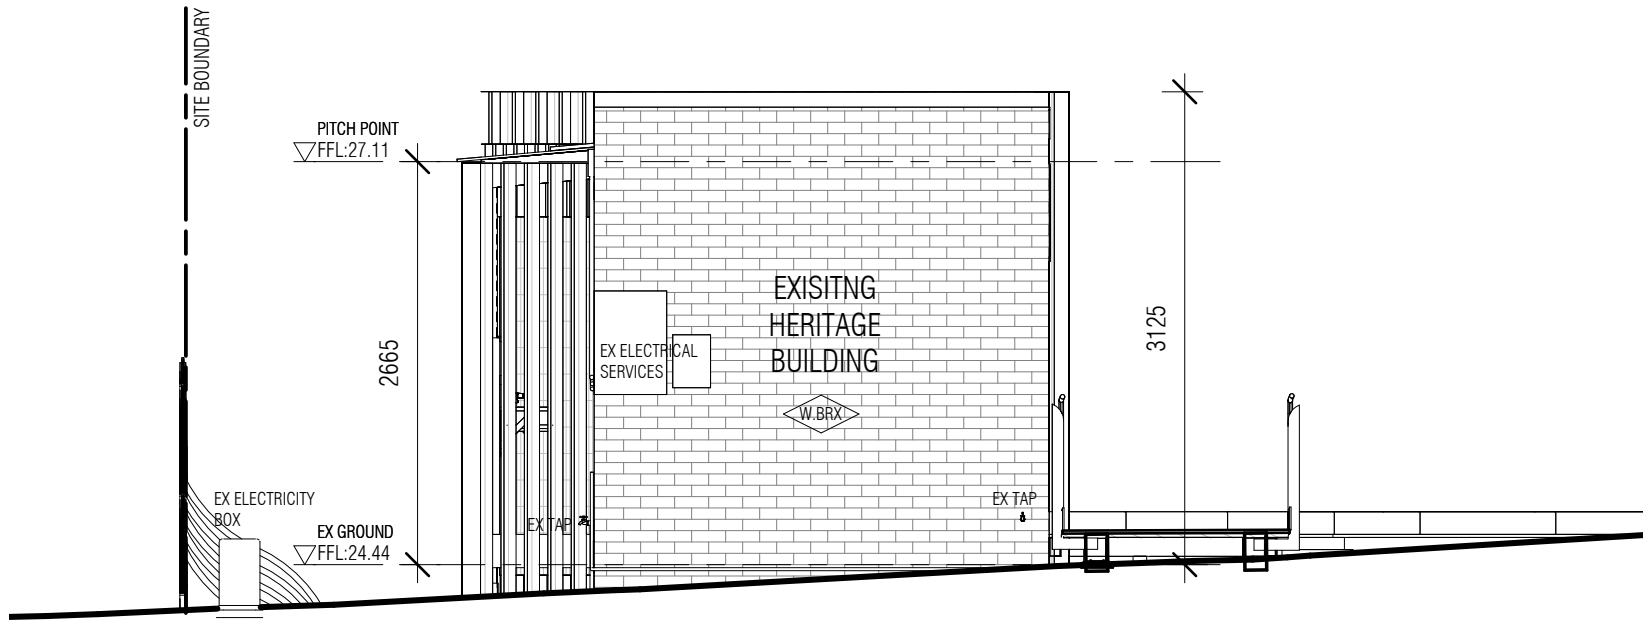

1 AMENITIES - EAST
DD101 SCALE 1 : 50

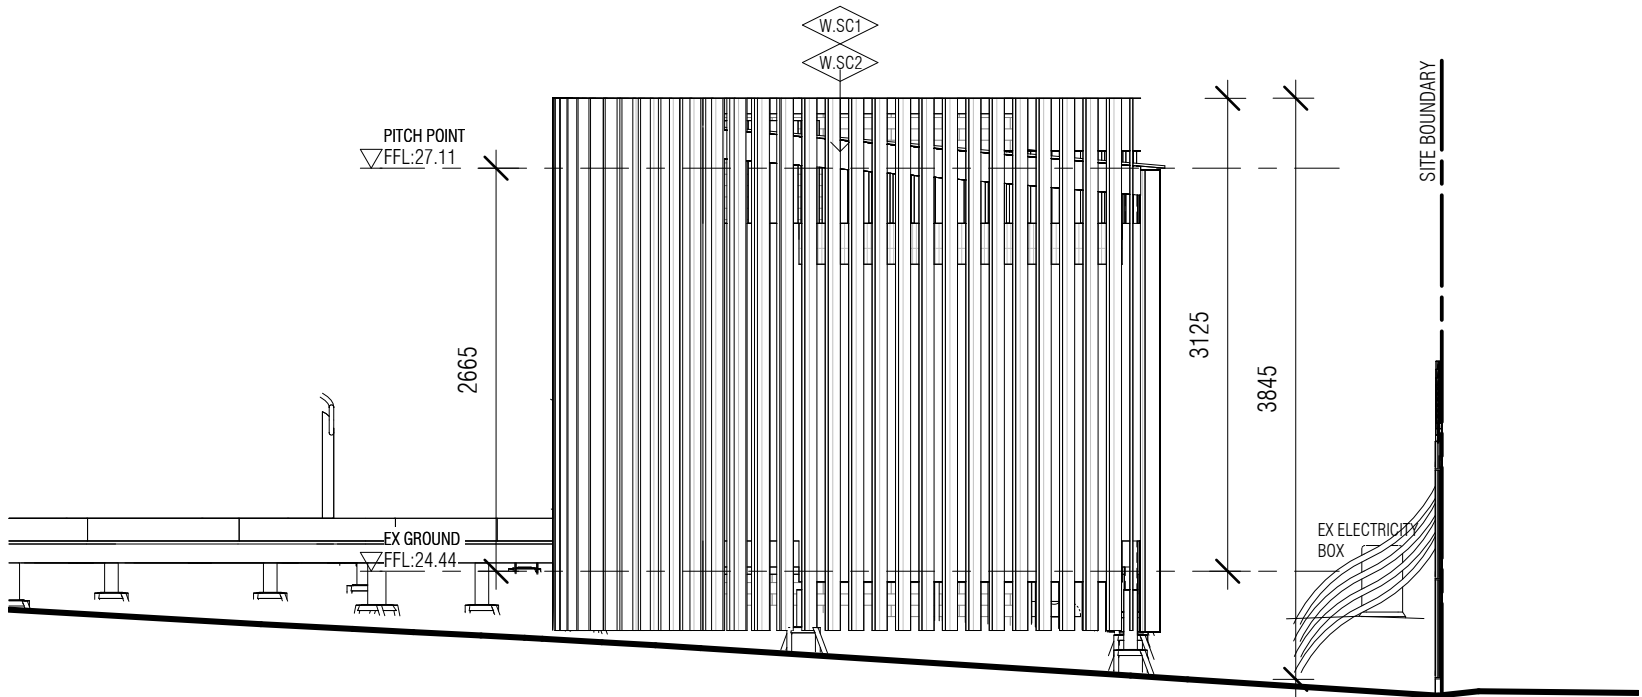

2 AMENITIES - WEST
DD101 SCALE 1 : 50

PRELIMINARY			
REV	ISSUE DATE	BY	REASON FOR ISSUE
00	22.11.24	ST	ISSUED TO DDA
01	5.02.25	ST	ISSUED TO CLIENT

ARCHITECT



SARAH LAKE ARCHITECTS

Level 1 242 Victoria Street
BRUNSWICK VIC 3056
info@sarahlake.com.au
www.sarahlake.com.au

PROJECT DETAILS

PROJECT: AUSTRALIAN DRYLANDS
LEARNING HUB MELBOURNE

CLIENT: RBGV

ALL WORKS TO BE CARRIED OUT TO AUSTRALIAN STANDARDS AND TO COMPLY WITH
THE BUILDING CODE OF AUSTRALIA
ALL DIMENSIONS TO BE CHECKED ON SITE PRIOR TO WORKS COMMENCING

DRAWING

TITLE: ELEVATIONS - AMENITIES
PROPOSED


SCALE: 1 : 50

JOB NUMBER: 2305


DATE: MAY 2023

DRAWN: ST

DRAWING NO: DD202

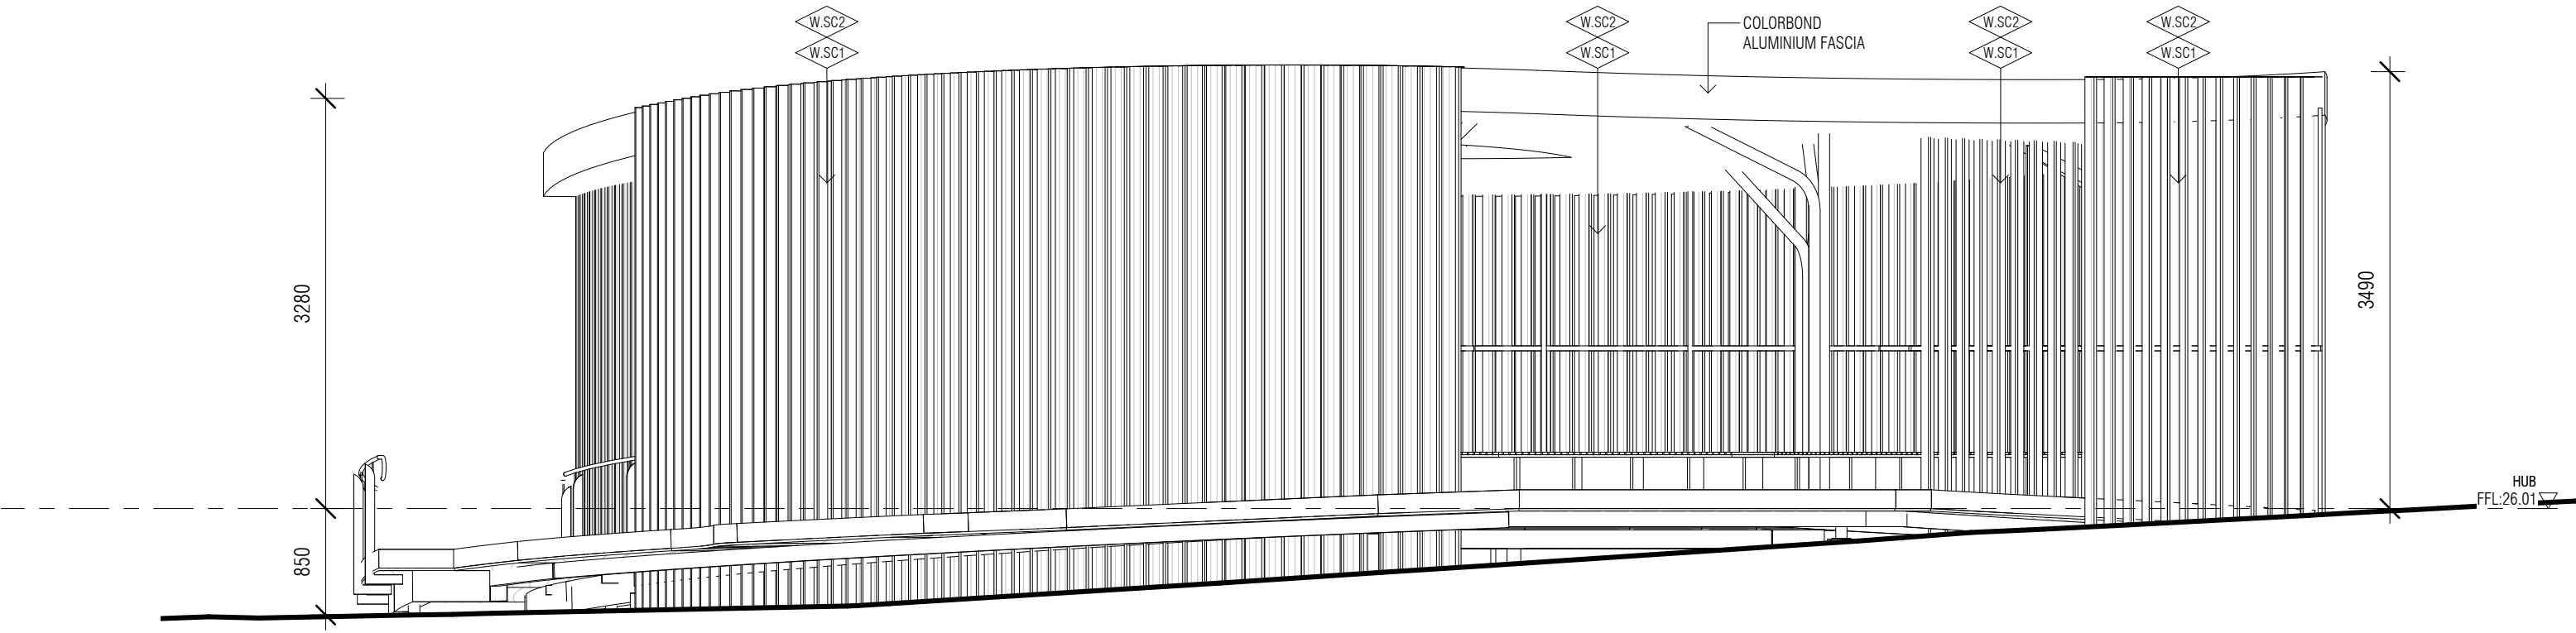

1 HUB - EAST
DD101 SCALE 1 : 50

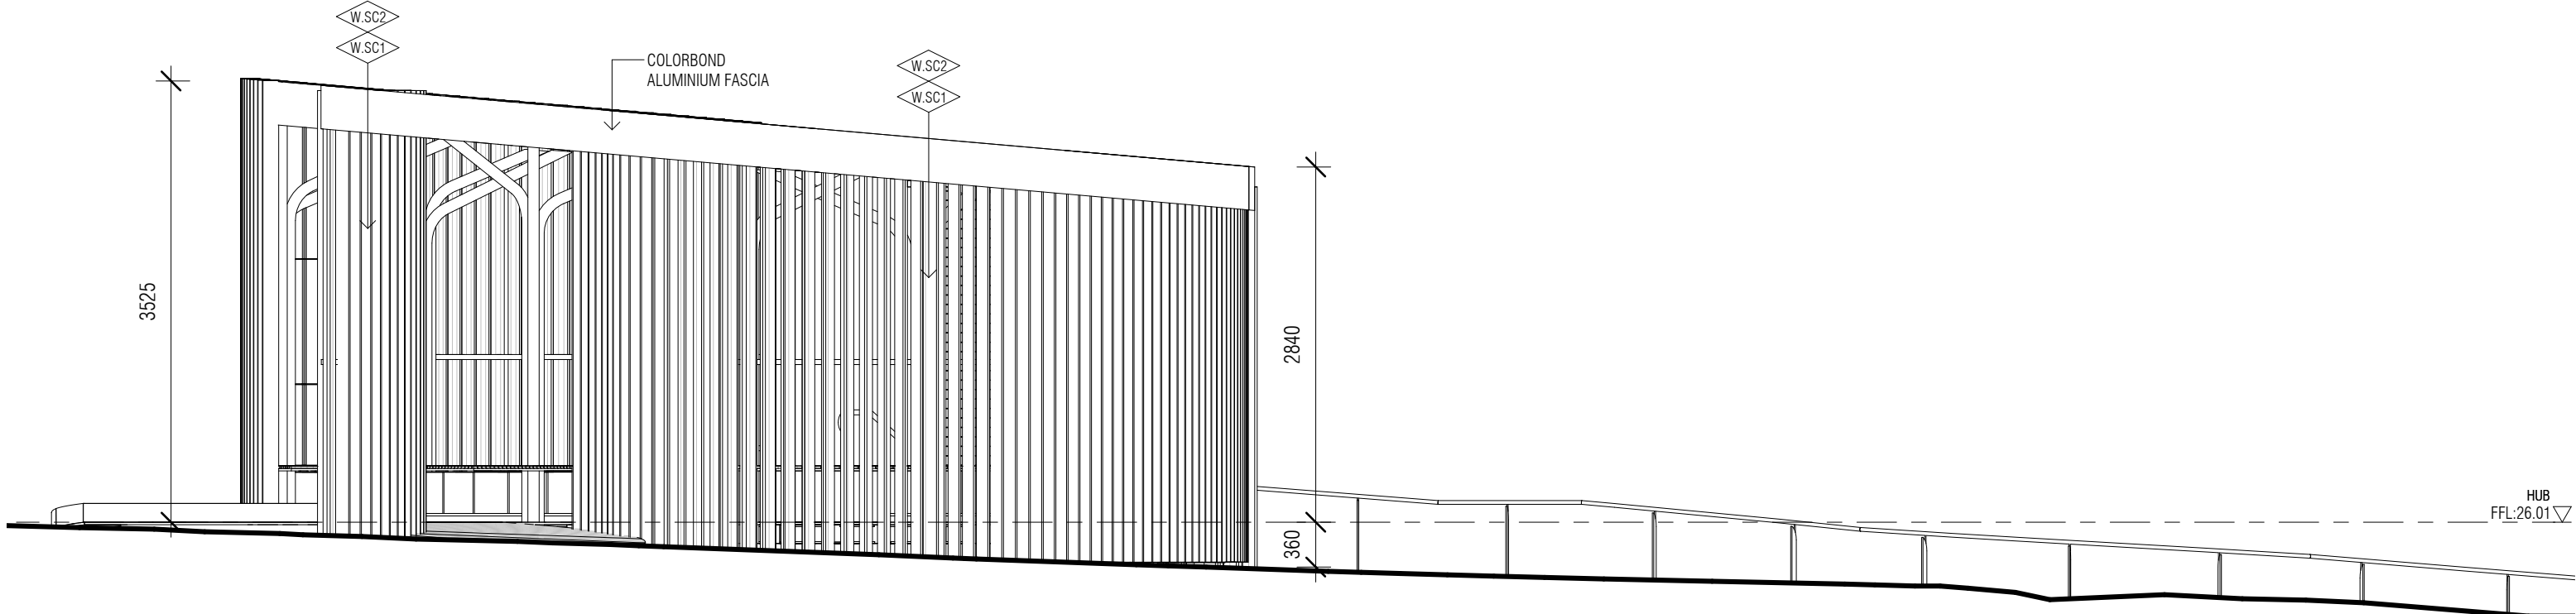

2 HUB - NORTH
DD101 SCALE 1 : 50

PRELIMINARY			
REV	ISSUE DATE	BY	REASON FOR ISSUE
00	5.02.25	ST	ISSUED TO CLIENT

ARCHITECT



SARAH LAKE ARCHITECTS

Level 1 242 Victoria Street
BRUNSWICK VIC 3056
info@sarahlake.com.au
www.sarahlake.com.au

PROJECT DETAILS

PROJECT: AUSTRALIAN DRYLANDS
LEARNING HUB MELBOURNE

CLIENT: RBGV

ALL WORKS TO BE CARRIED OUT TO AUSTRALIAN STANDARDS AND TO COMPLY WITH
THE BUILDING CODE OF AUSTRALIA
ALL DIMENSIONS TO BE CHECKED ON SITE PRIOR TO WORKS COMMENCING

DRAWING

TITLE: ELEVATIONS - HUB
PROPOSED


SCALE: 1 : 50


JOB NUMBER: 2305

DATE: MAY 2023


DRAWN: ST

DRAWING NO: DD203

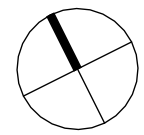

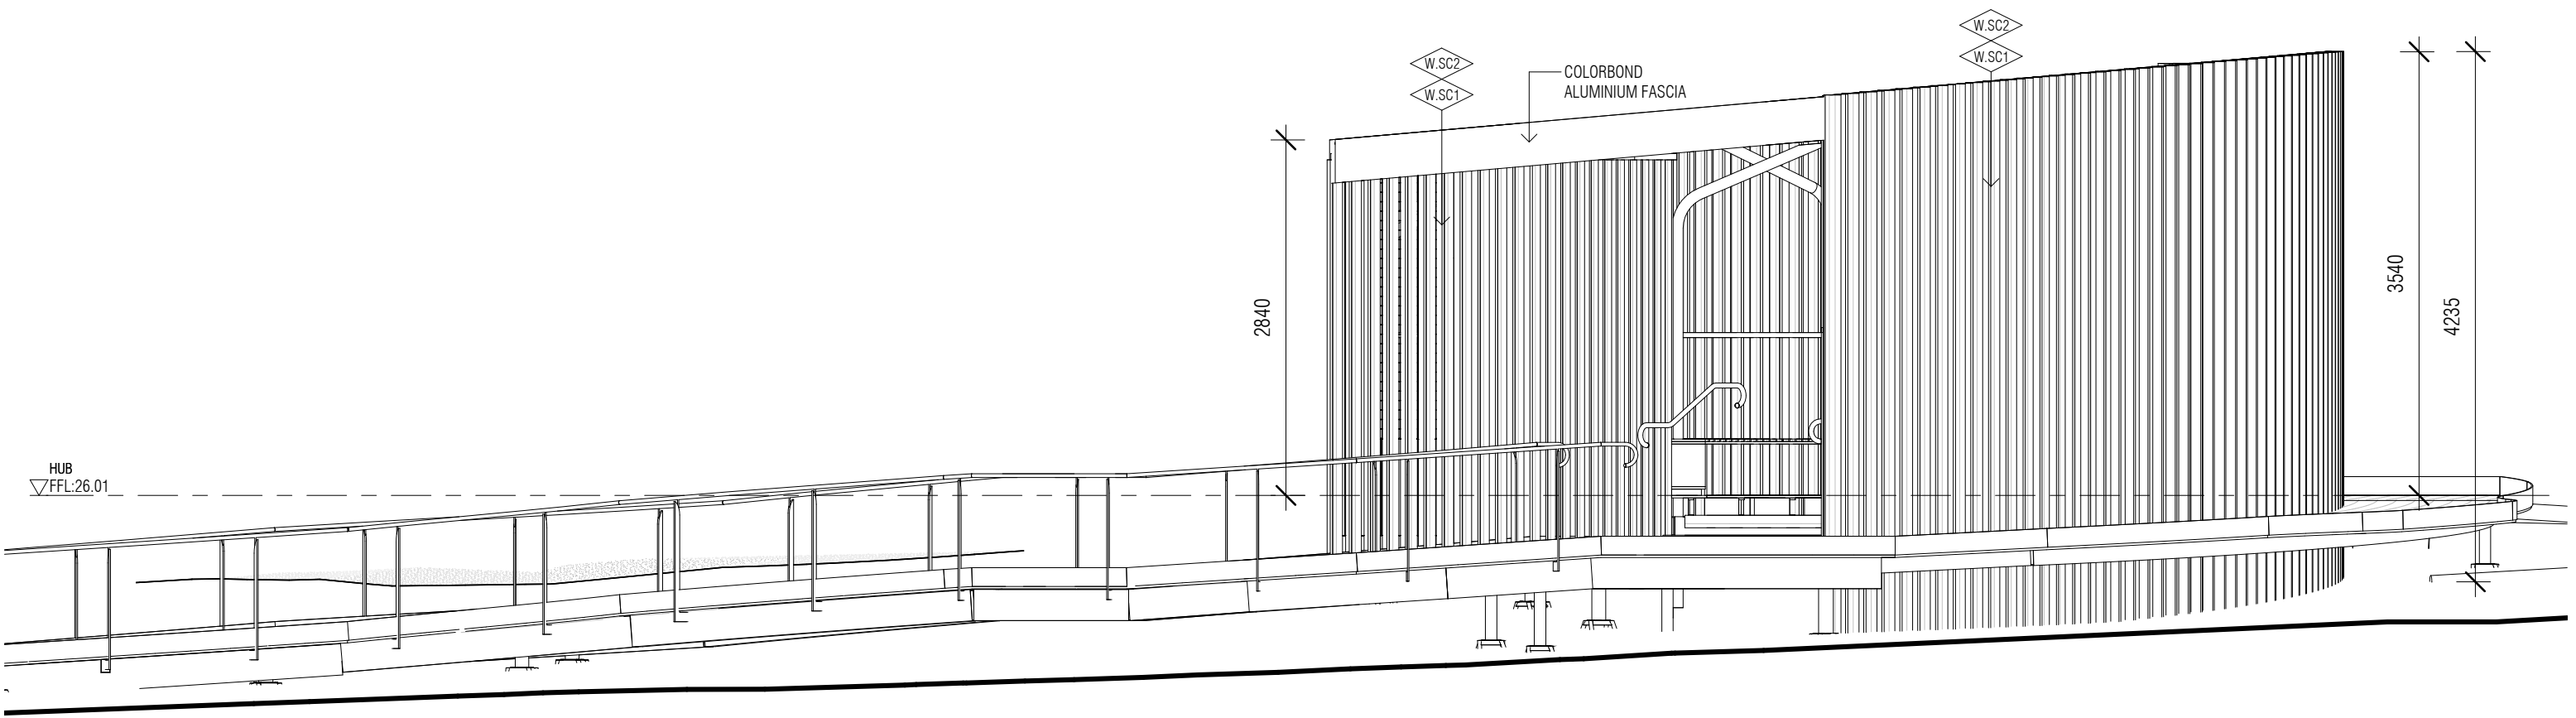

1 HUB - SOUTH
DD051 SCALE 1 : 50

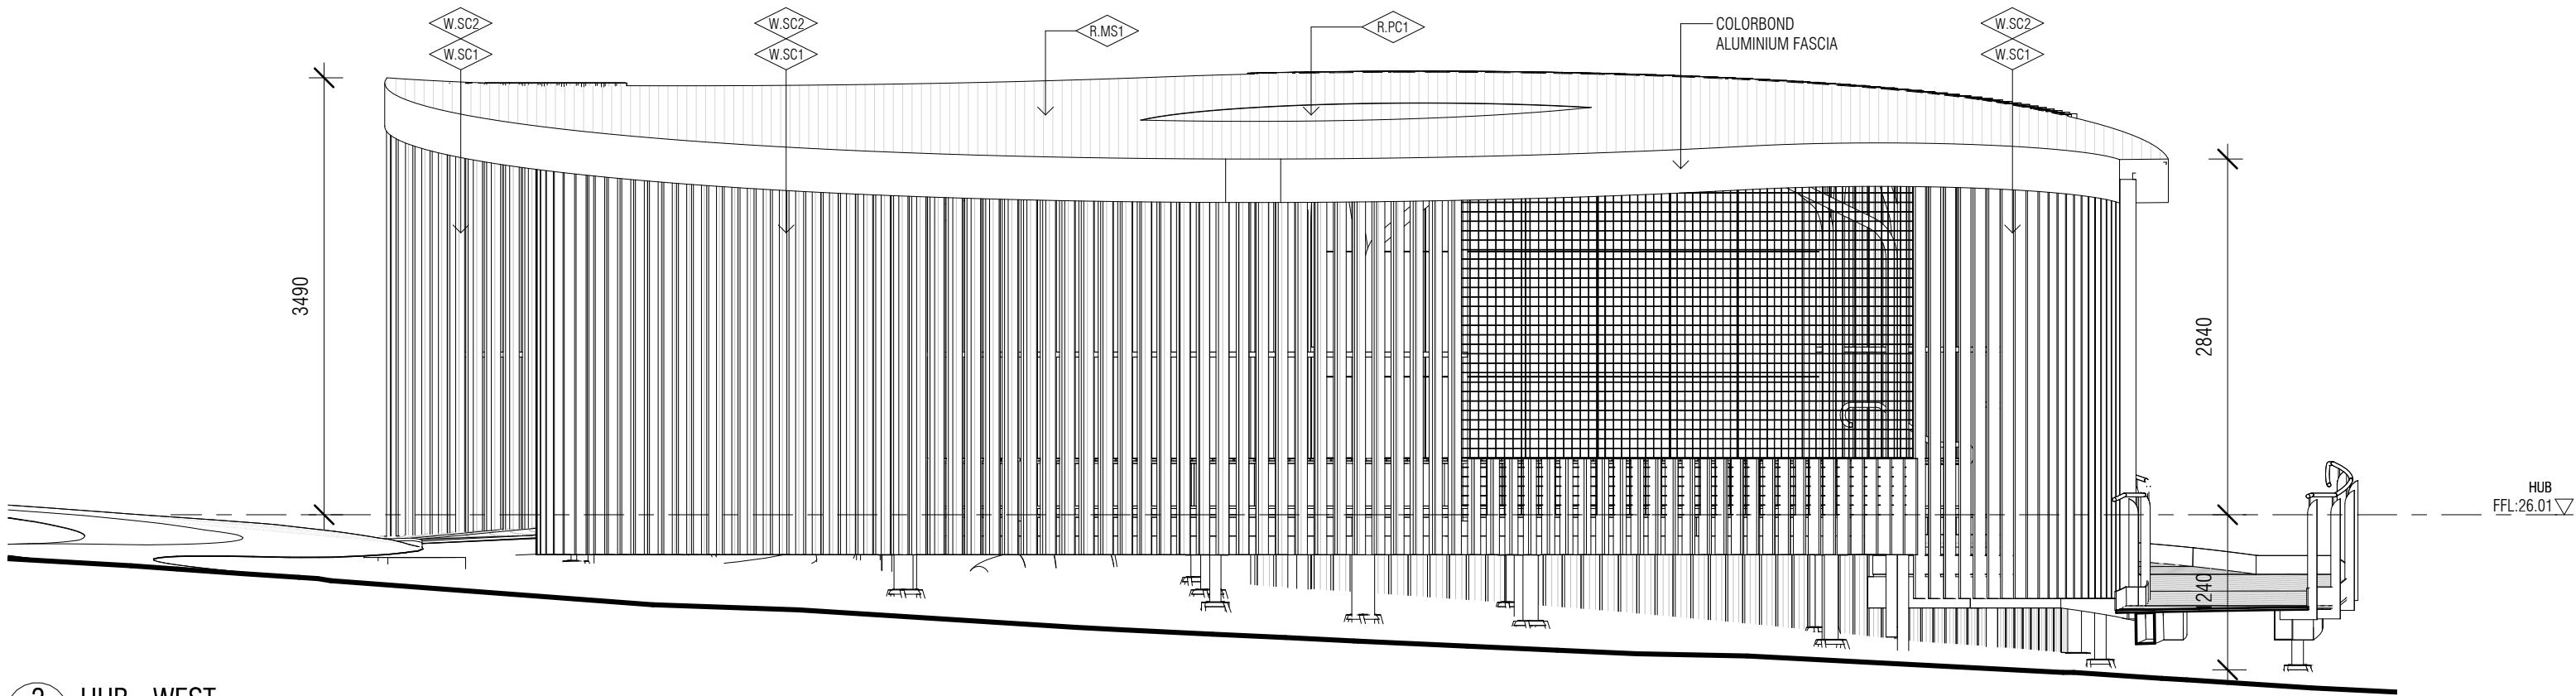

2 HUB - WEST
DD101 SCALE 1 : 50

PRELIMINARY			
REV	ISSUE DATE	BY	REASON FOR ISSUE
00	5.02.25	ST	ISSUED TO CLIENT

ARCHITECT



SARAH LAKE ARCHITECTS

Level 1 242 Victoria Street
BRUNSWICK VIC 3056
info@sarahlake.com.au
www.sarahlake.com.au

PROJECT DETAILS

PROJECT: AUSTRALIAN DRYLANDS
LEARNING HUB MELBOURNE

CLIENT: RBGV

ALL WORKS TO BE CARRIED OUT TO AUSTRALIAN STANDARDS AND TO COMPLY WITH
THE BUILDING CODE OF AUSTRALIA
ALL DIMENSIONS TO BE CHECKED ON SITE PRIOR TO WORKS COMMENCING

DRAWING

TITLE: ELEVATIONS - HUB
PROPOSED


SCALE: 1 : 50

JOB NUMBER: 2305


DATE: MAY 2023

DRAWN: ST


DRAWING NO: DD204

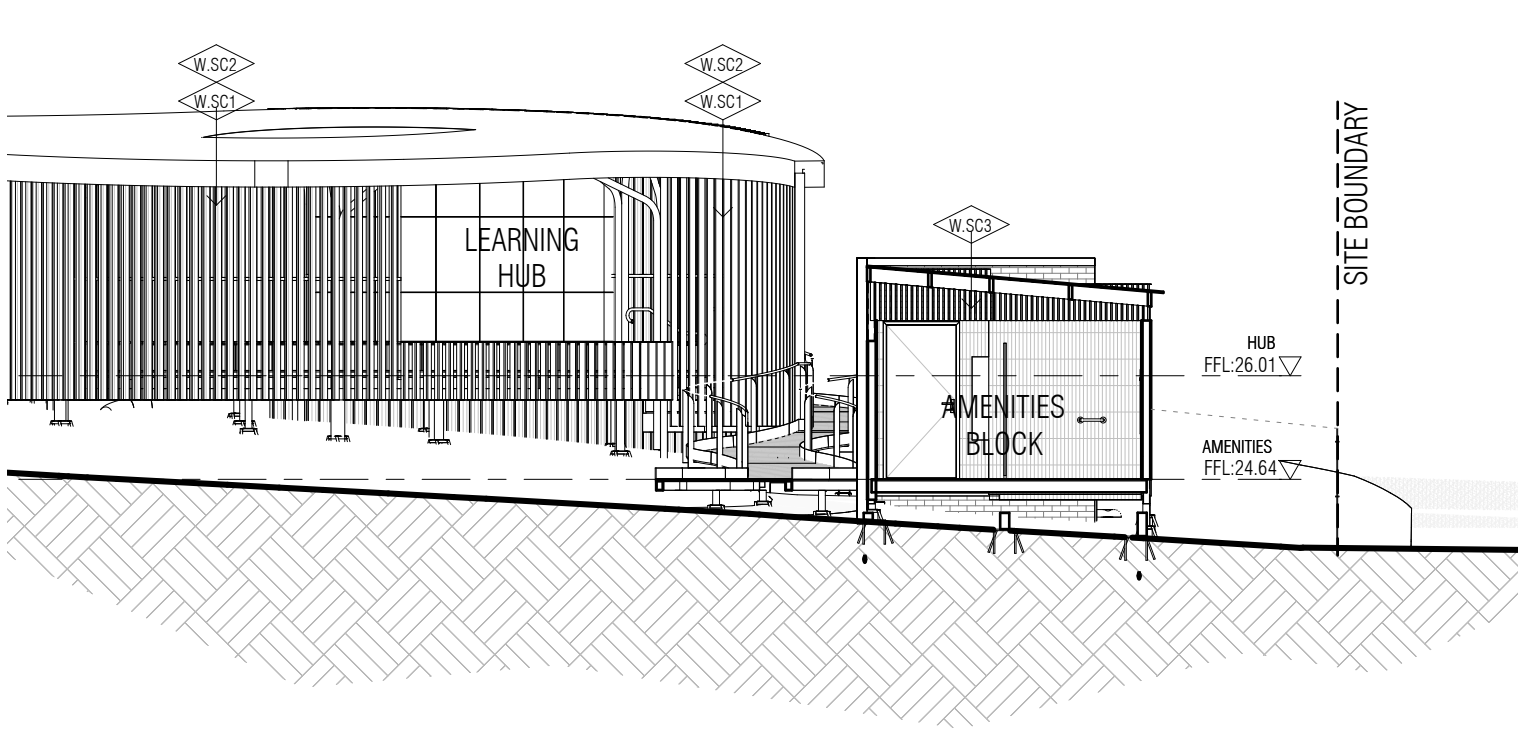

1 SECTION 3
DD101 SCALE 1 : 100

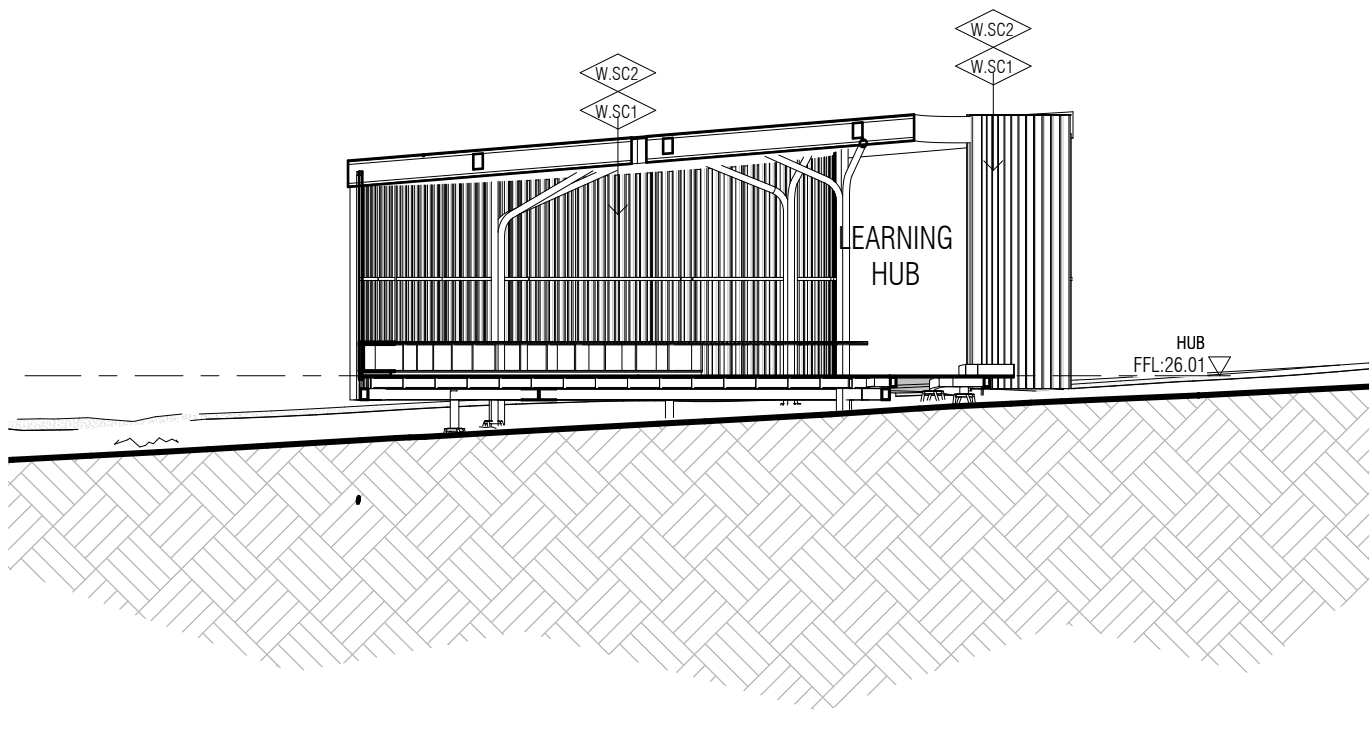

2 SECTION - HUB
DD101 SCALE 1 : 100

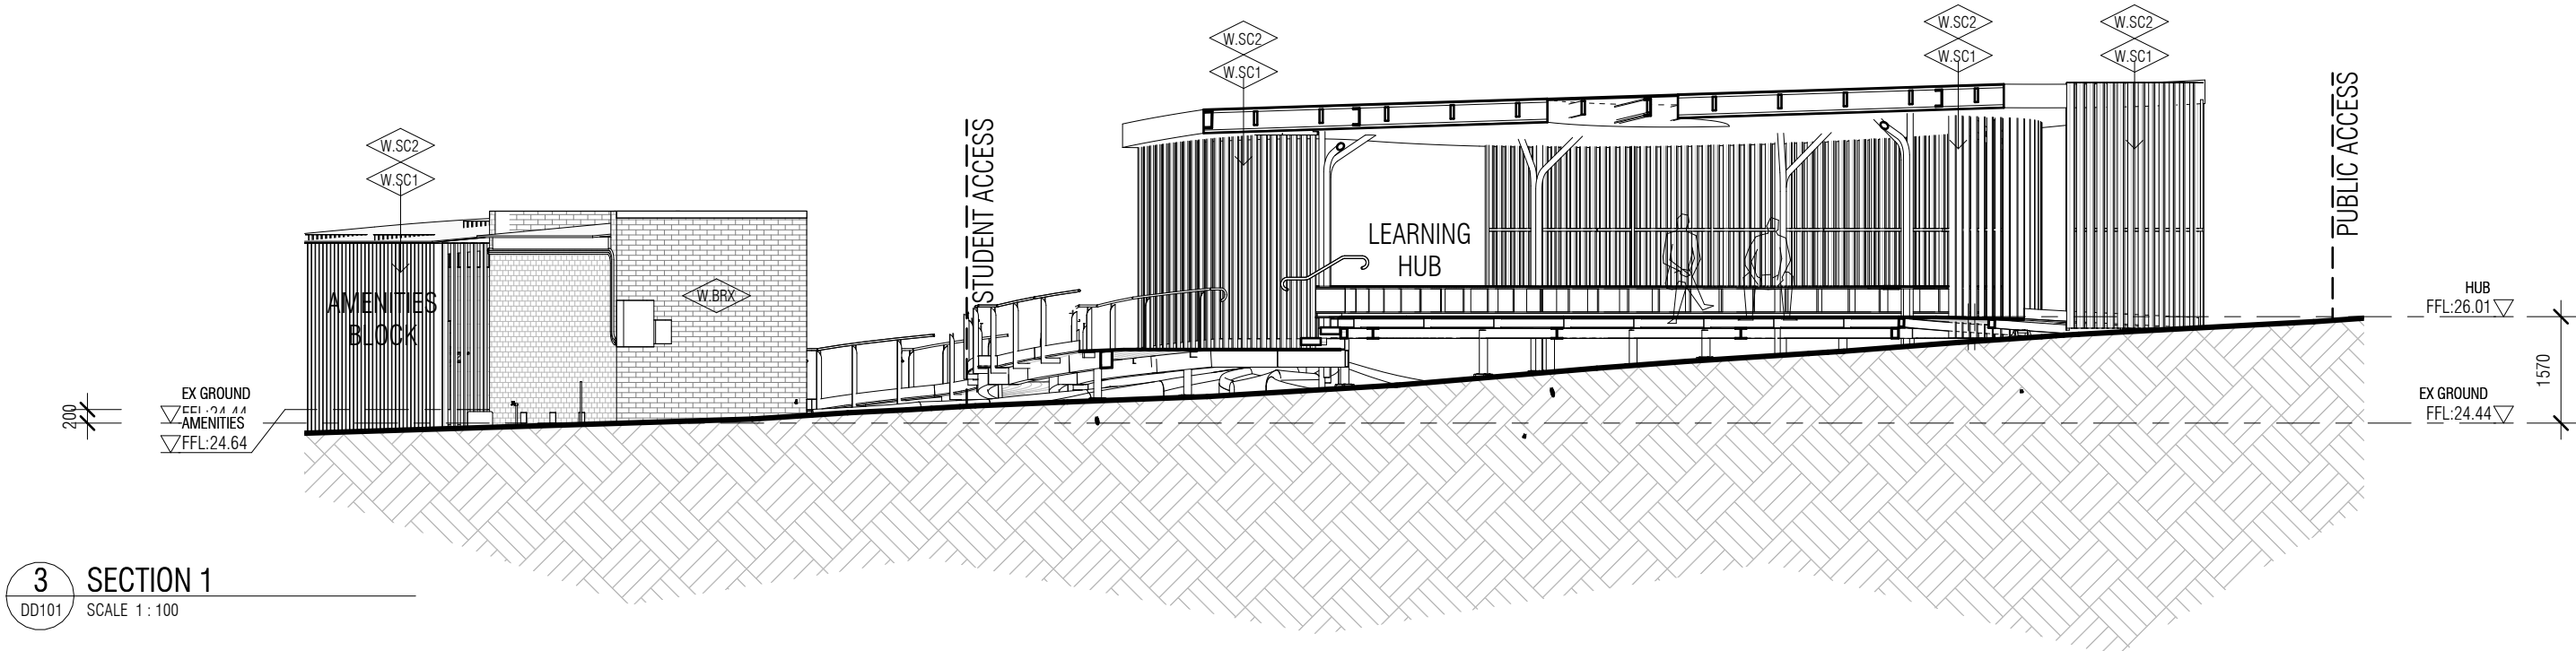

3 SECTION 1
DD101 SCALE 1 : 100

PRELIMINARY			
REV	ISSUE DATE	BY	REASON FOR ISSUE
00	24.09.24	ST	ISSUED TO CLIENT
01	17.10.24	ST	ISSUED TO ENGINEER
02	22.11.24	ST	ISSUED TO DDA
03	5.02.25	ST	ISSUED TO CLIENT

ARCHITECT



SARAH LAKE ARCHITECTS

Level 1 242 Victoria Street
BRUNSWICK VIC 3056
info@sarahlake.com.au
www.sarahlake.com.au

PROJECT DETAILS

PROJECT: AUSTRALIAN DRYLANDS
LEARNING HUB MELBOURNE

CLIENT: RBGV

ALL WORKS TO BE CARRIED OUT TO AUSTRALIAN STANDARDS AND TO COMPLY WITH
THE BUILDING CODE OF AUSTRALIA
ALL DIMENSIONS TO BE CHECKED ON SITE PRIOR TO WORKS COMMENCING

DRAWING

TITLE: SECTIONS
PROPOSED


SCALE: 1 : 100

JOB NUMBER: 2305


DATE: MAY 2023

DRAWN: ST


DRAWING NO: DD302

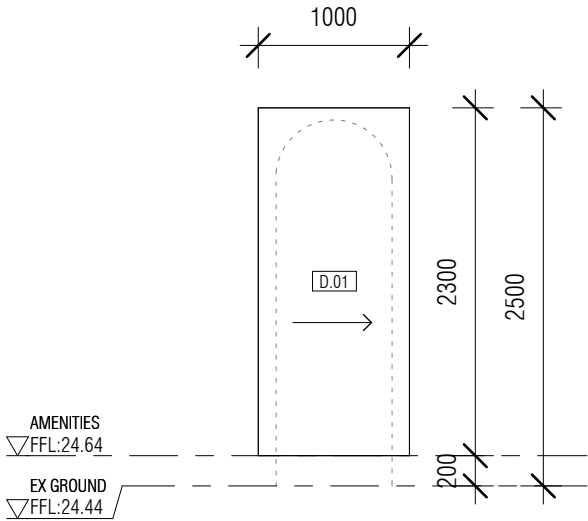


D.01

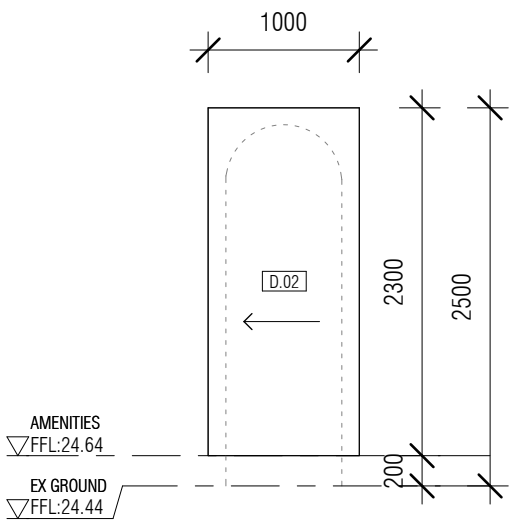

D.02

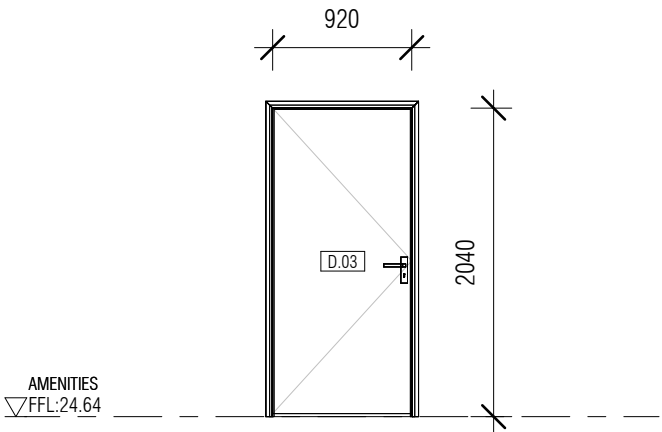

D.03

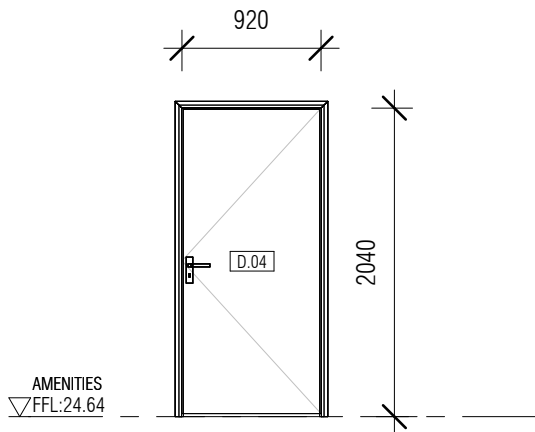

D.04

PRELIMINARY

REV	ISSUE DATE	BY	REASON FOR ISSUE
00	5.02.25	ST	ISSUED TO CLIENT

ARCHITECT



SARAH LAKE ARCHITECTS

Level 1 242 Victoria Street
BRUNSWICK VIC 3056
info@sarahlake.com.au
www.sarahlake.com.au

PROJECT DETAILS

PROJECT: AUSTRALIAN DRYLANDS
LEARNING HUB MELBOURNE

CLIENT: RBGV

 
ALL WORKS TO BE CARRIED OUT TO AUSTRALIAN STANDARDS AND TO COMPLY WITH
THE BUILDING CODE OF AUSTRALIA
ALL DIMENSIONS TO BE CHECKED ON SITE PRIOR TO WORKS COMMENCING

DRAWING


TITLE: DOOR & WINDOW SCHEDULE
PROPOSED

SCALE: 1 : 50
DATE: MAY 2023
JOB NUMBER: 2305
DRAWN: ST


DRAWING NO:



DD401

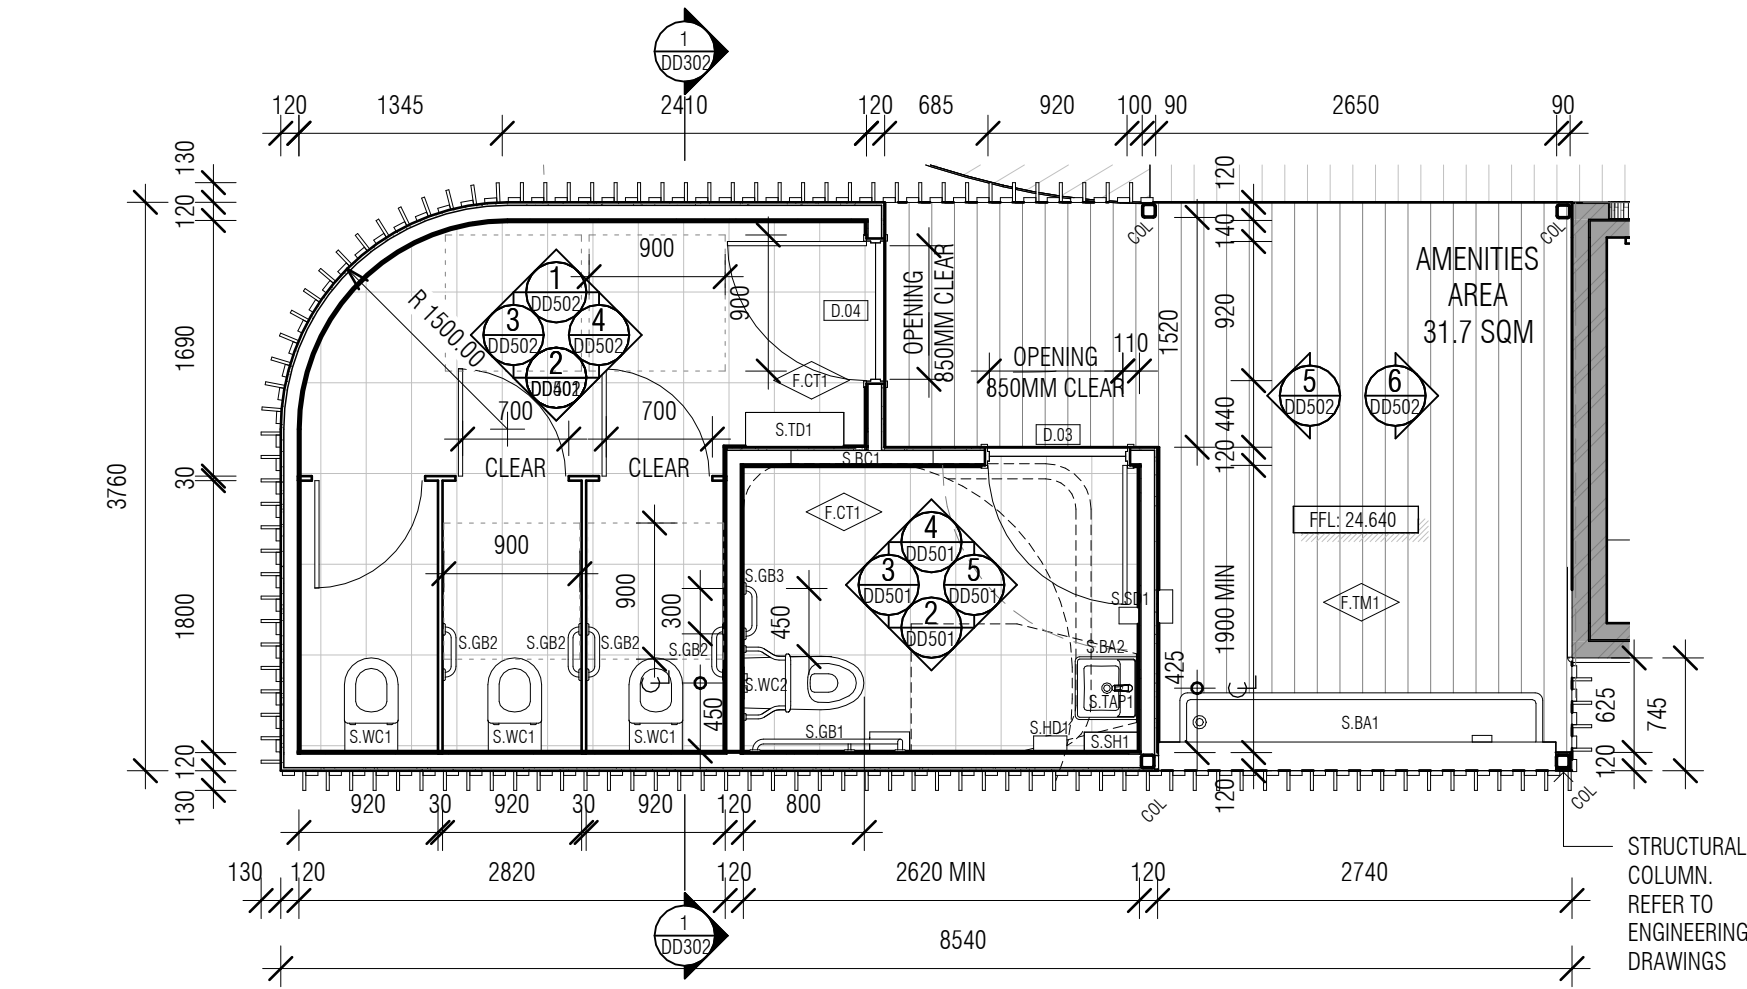

1 AMENITIES PLAN
SCALE 1 : 50

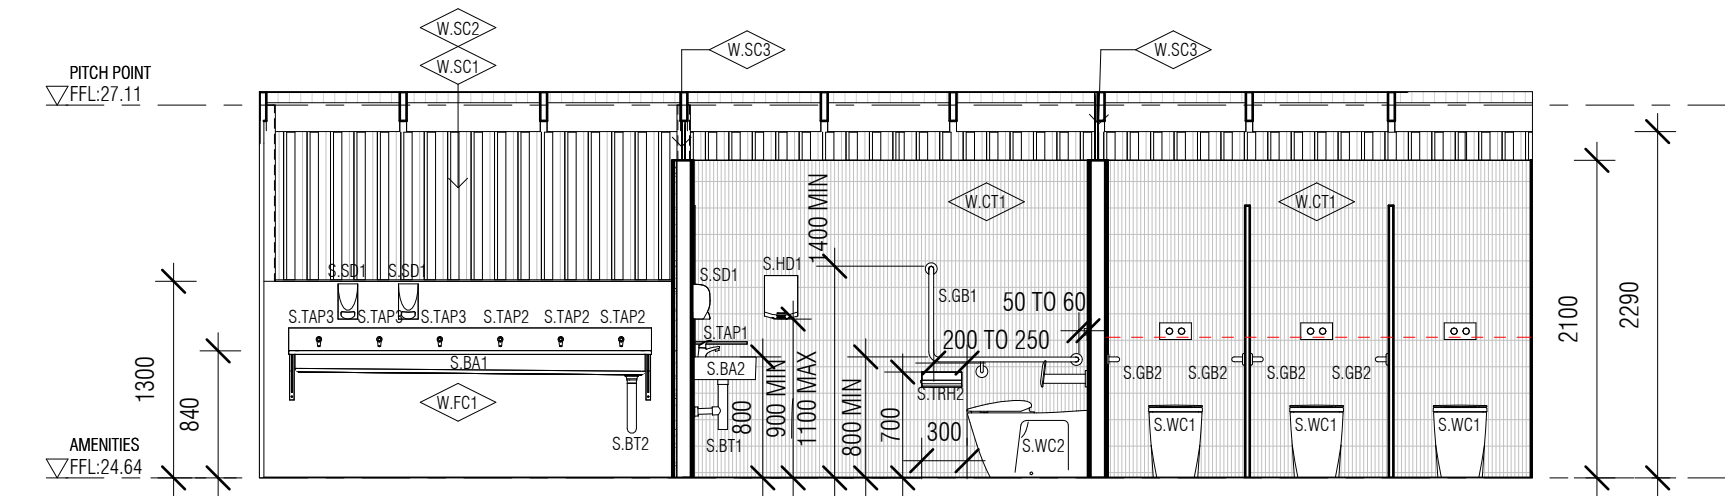

2 ELEVATION - INTERNAL
DD501 SCALE 1 : 50


PRELIMINARY			
REV	ISSUE DATE	BY	REASON FOR ISSUE
00	22.11.24	ST	ISSUED TO DDA
01	5.02.25	ST	ISSUED TO CLIENT

ARCHITECT




SARAH LAKE ARCHITECTS

Level 1 242 Victoria Street
BRUNSWICK VIC 3056
info@sarahlake.com.au
www.sarahlake.com.au

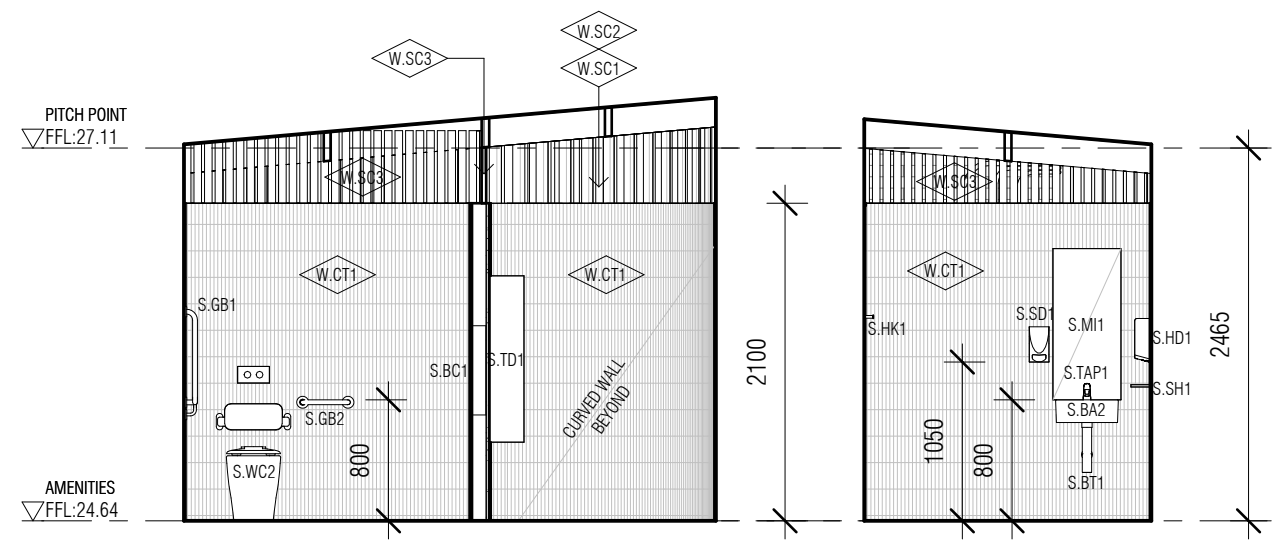

3 ELEVATION - INTERNAL
DD501 SCALE 1 : 50

5 ELEVATION - INTERNAL
DD501 SCALE 1 : 50

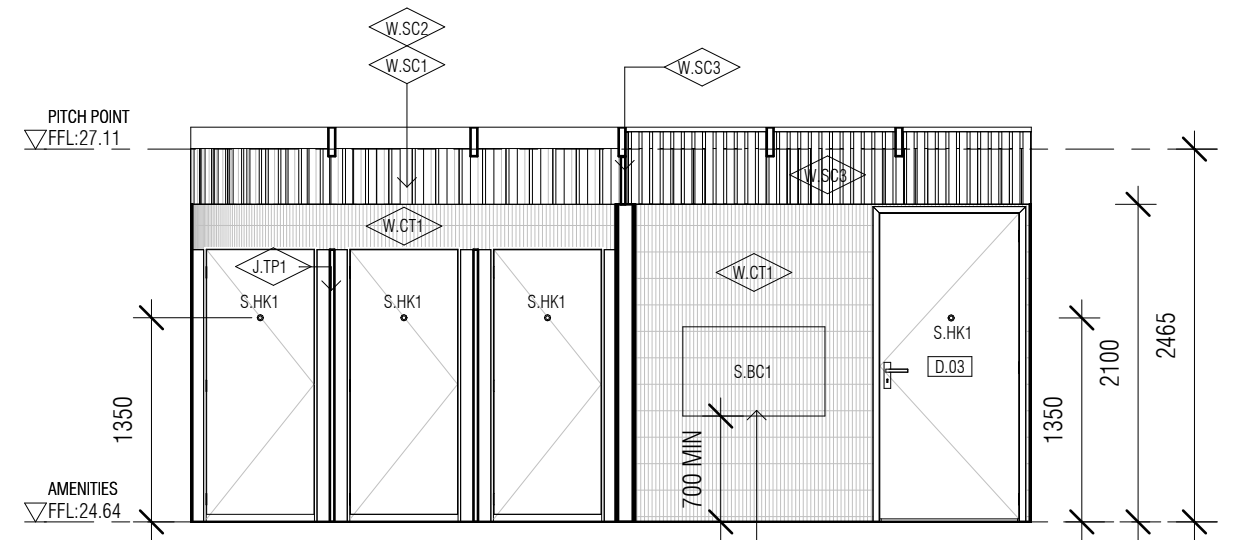

4 ELEVATION - INTERNAL
DD501 SCALE 1 : 50

PROJECT DETAILS

PROJECT: AUSTRALIAN DRYLANDS
LEARNING HUB MELBOURNE

CLIENT: RBGV

ALL WORKS TO BE CARRIED OUT TO AUSTRALIAN STANDARDS AND TO COMPLY WITH
THE BUILDING CODE OF AUSTRALIA
ALL DIMENSIONS TO BE CHECKED ON SITE PRIOR TO WORKS COMMENCING


DRAWING

TITLE: INTERNAL ELEVATIONS
PROPOSED


SCALE: 1 : 50
DATE: MAY 2023

JOB NUMBER: 2305
DRAWN: ST


DRAWING NO: DD501

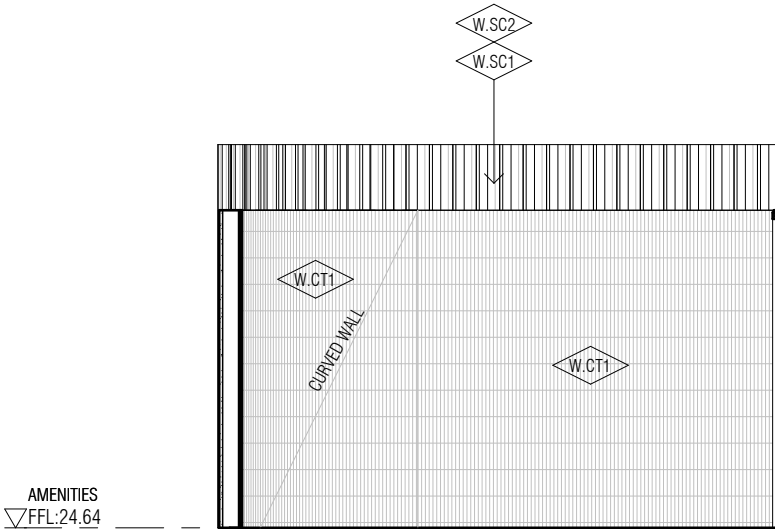


1 ELEVATION - INTERNAL
DD501 SCALE 1 : 50

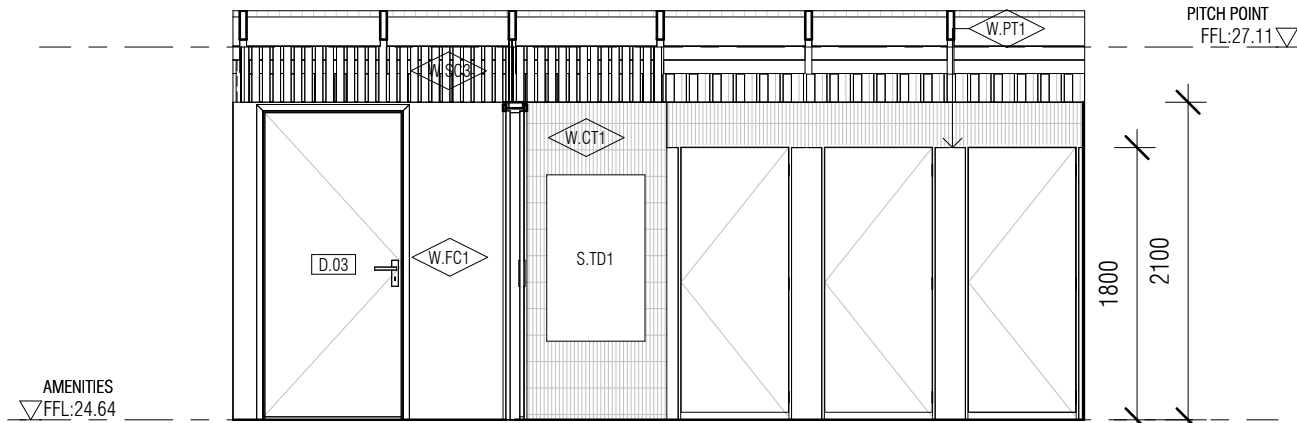


2 ELEVATION - INTERNAL
DD501 SCALE 1 : 50

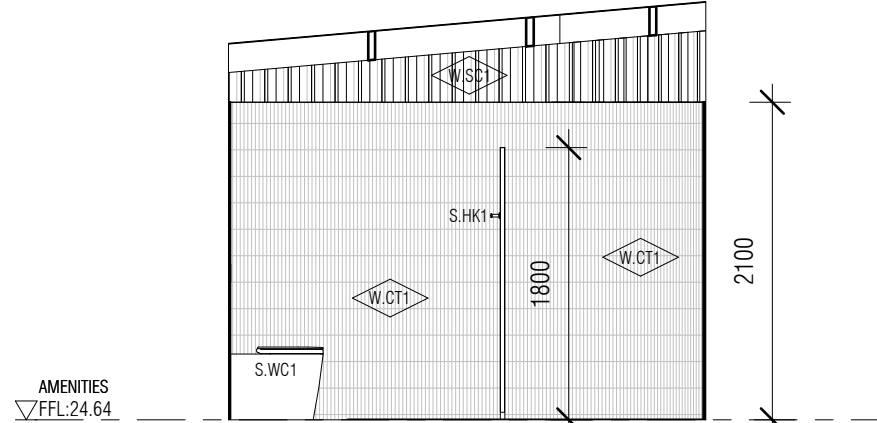


3 ELEVATION - INTERNAL
DD501 SCALE 1 : 50

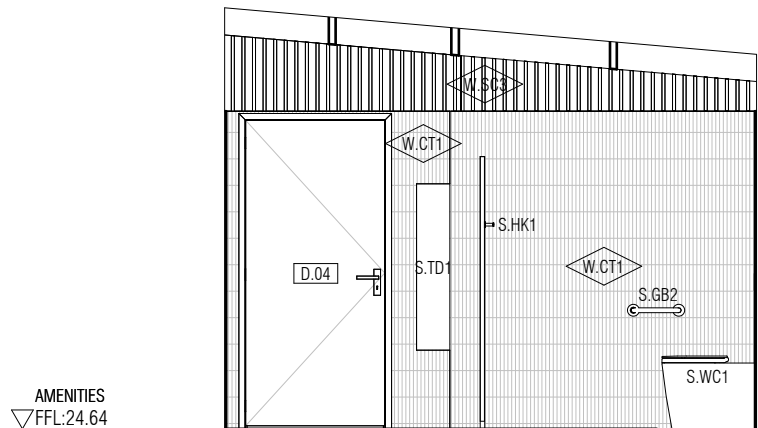

4 ELEVATION - INTERNAL
DD501 SCALE 1 : 50

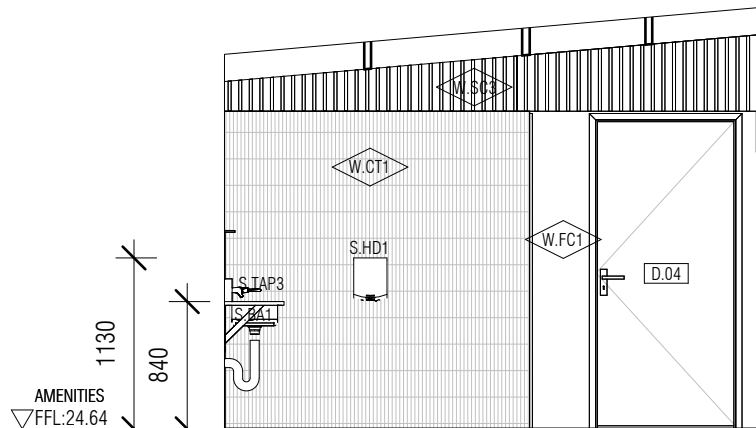

5 ELEVATION - INTERNAL
DD501 SCALE 1 : 50

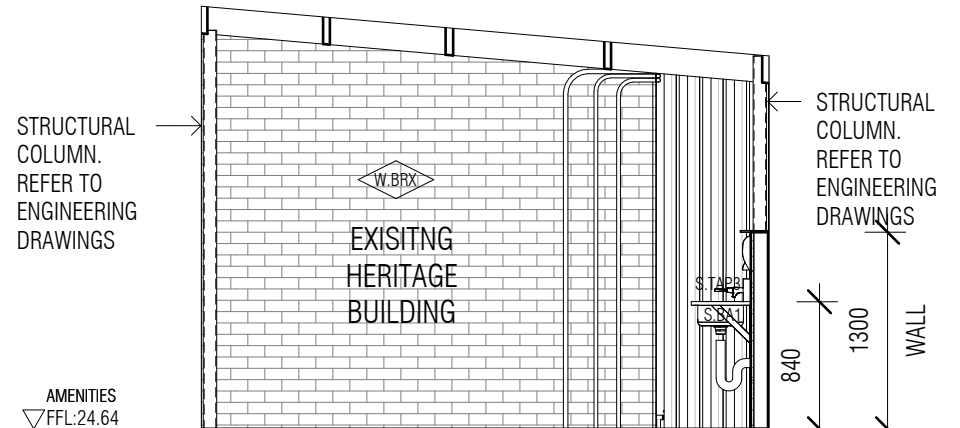

6 ELEVATION - INTERNAL
DD501 SCALE 1 : 50

PRELIMINARY			
REV	ISSUE DATE	BY	REASON FOR ISSUE
00	22.11.24	ST	ISSUED TO DDA
01	5.02.25	ST	ISSUED TO CLIENT

ARCHITECT

SARAH LAKE ARCHITECTS

Level 1 242 Victoria Street
BRUNSWICK VIC 3056
info@sarahlake.com.au
www.sarahlake.com.au

PROJECT DETAILS

PROJECT: **AUSTRALIAN DRYLANDS
LEARNING HUB MELBOURNE**

CLIENT: **RBGV**

ALL WORKS TO BE CARRIED OUT TO AUSTRALIAN STANDARDS AND TO COMPLY WITH
THE BUILDING CODE OF AUSTRALIA
ALL DIMENSIONS TO BE CHECKED ON SITE PRIOR TO WORKS COMMENCING


DRAWING

TITLE: **INTERNAL ELEVATIONS
PROPOSED**

SCALE: **1 : 50** JOB NUMBER: **2305**


DATE: **MAY 2023** DRAWN: **ST**

DRAWING NO: **DD502**

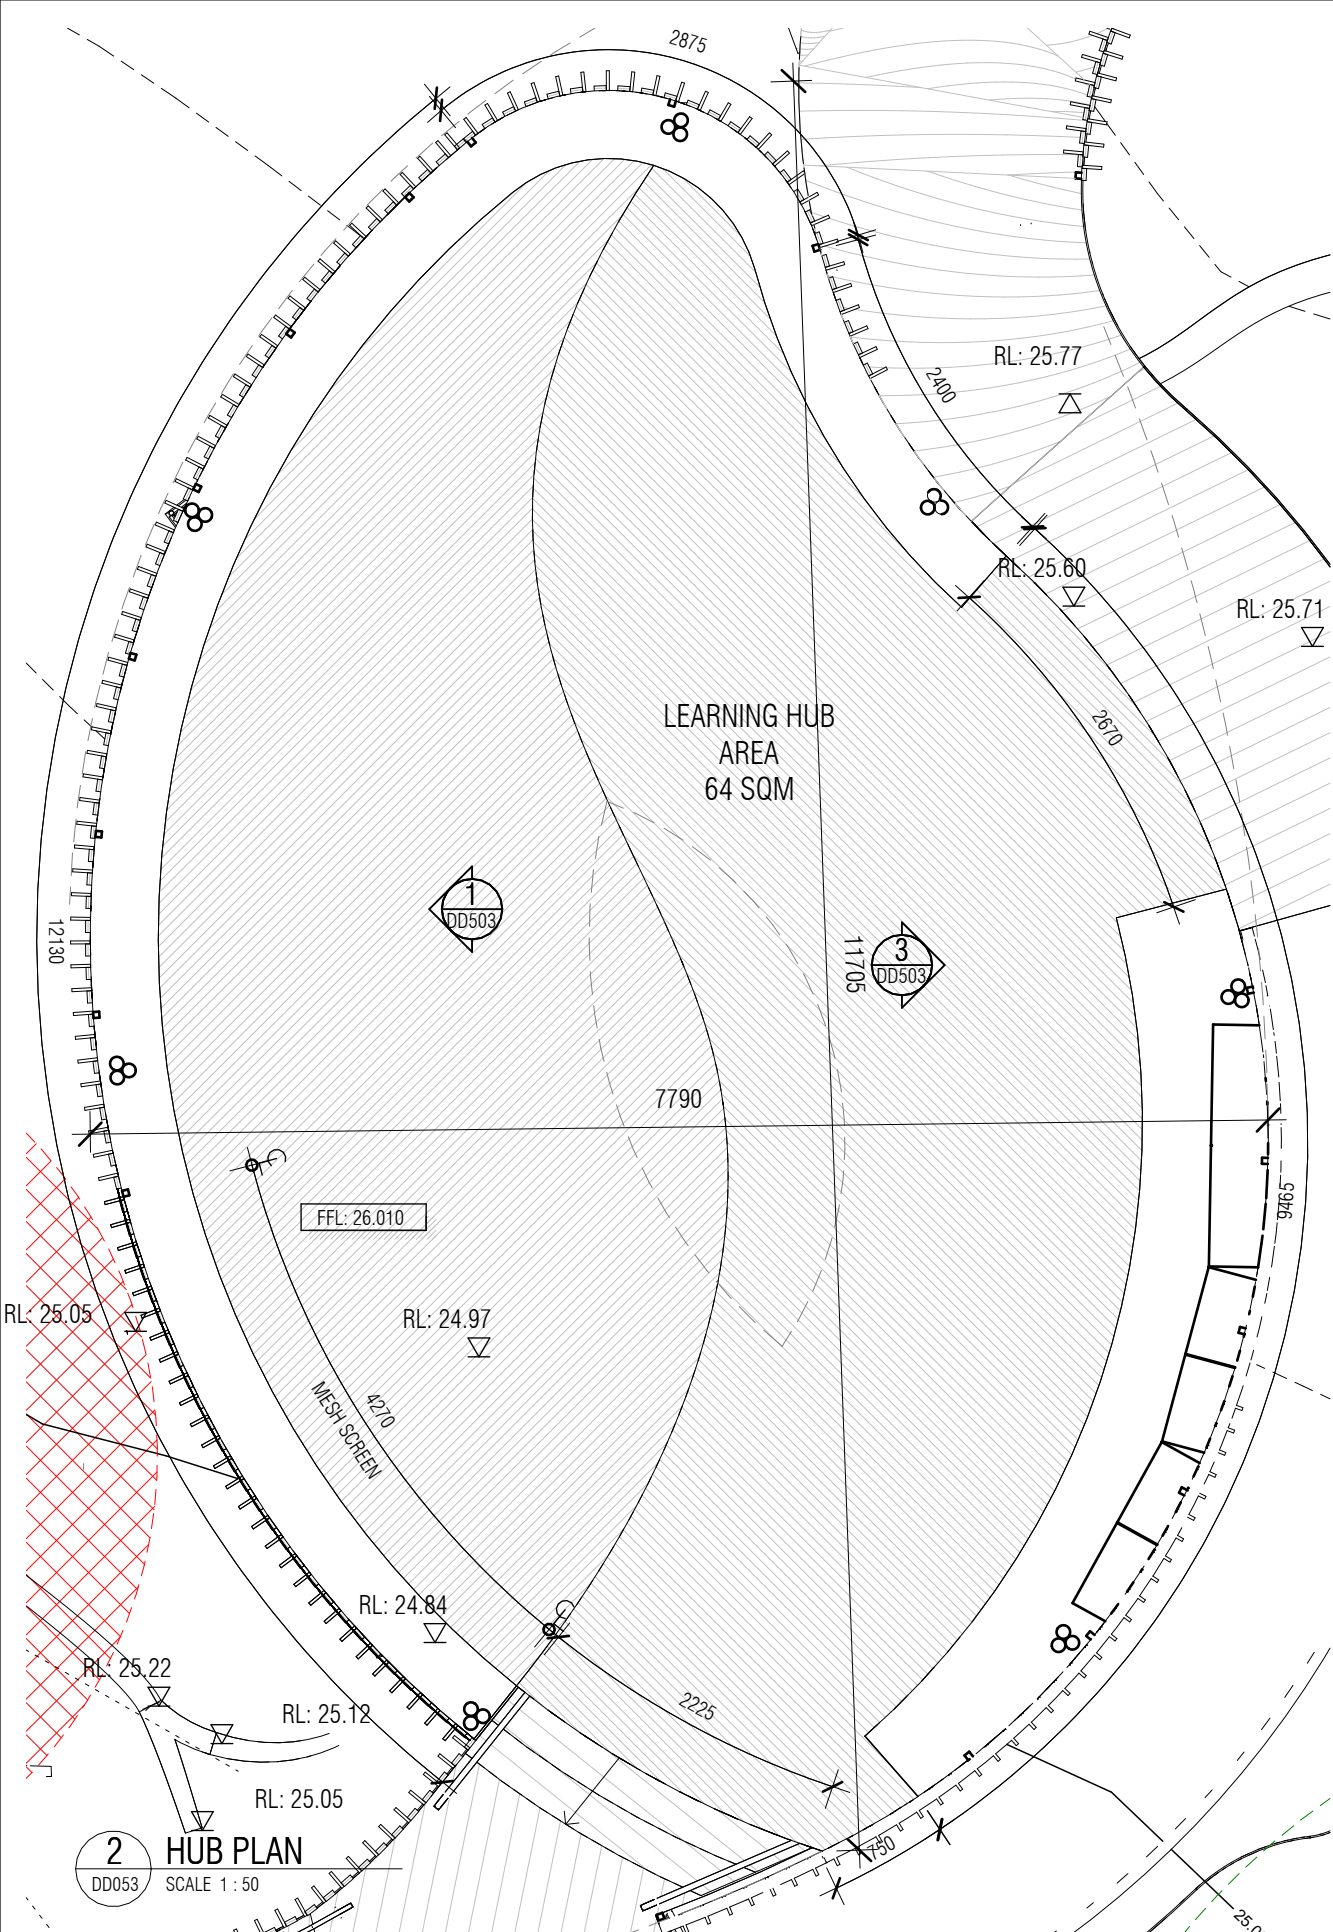


HUB
▽FFL:26.01

1 ELEVATION - INTERNAL
DD102 SCALE 1 : 50

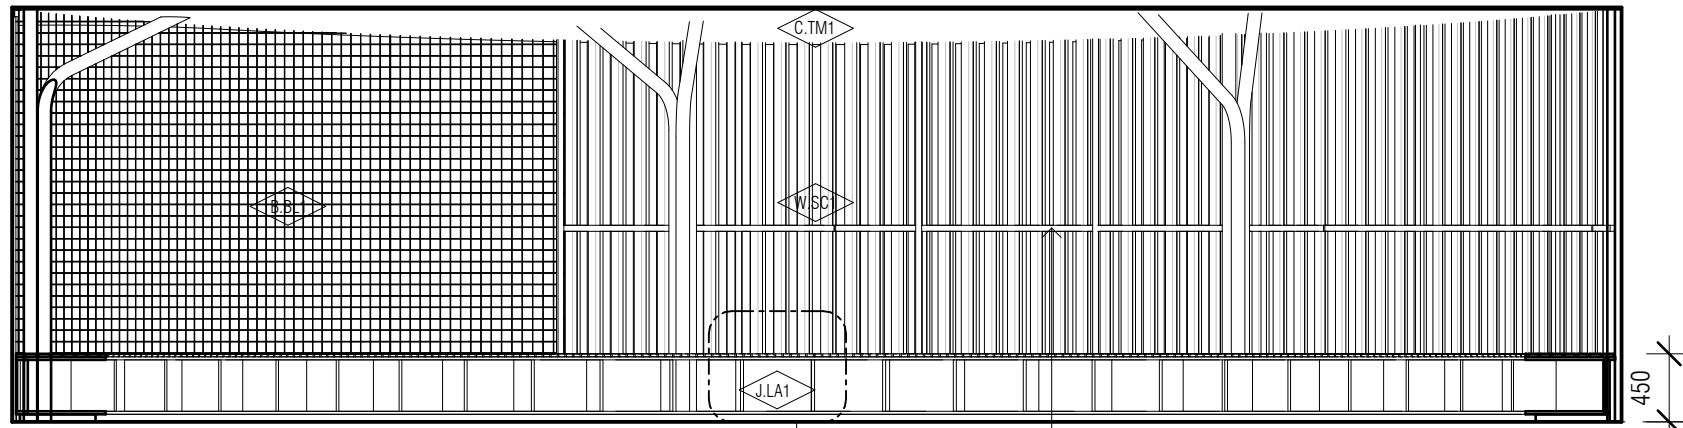


HUB
▽FFL:26.01

3 ELEVATION - INTERNAL
DD102 SCALE 1 : 50

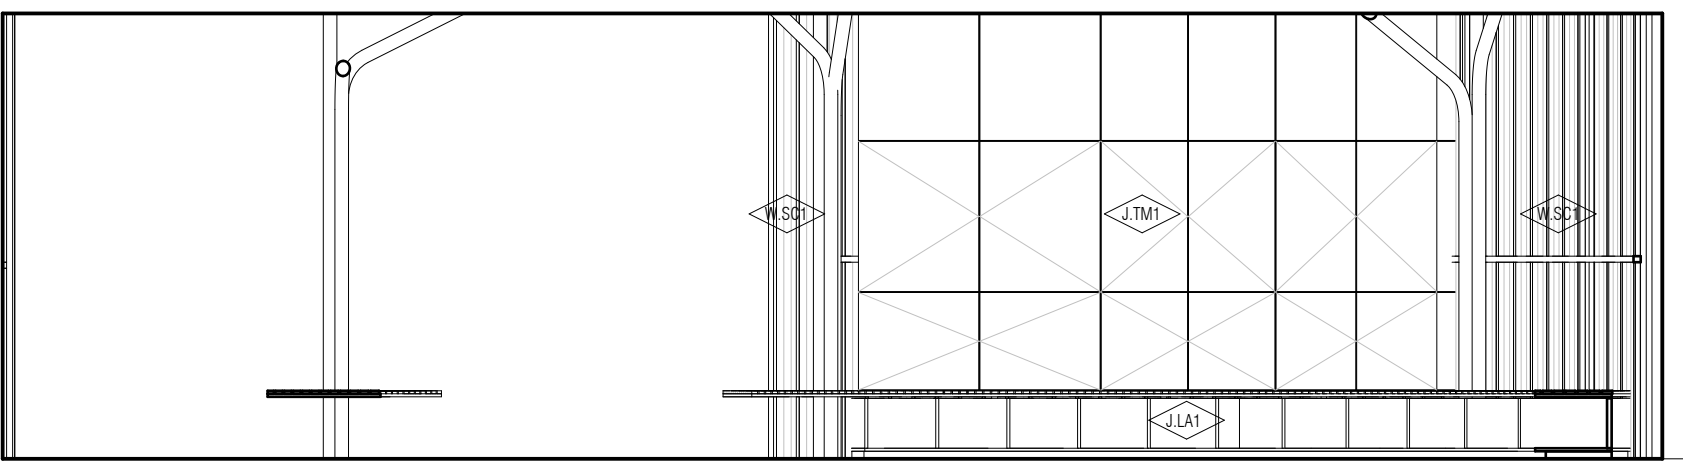

4 DETAIL
DD503 SCALE 1 : 20

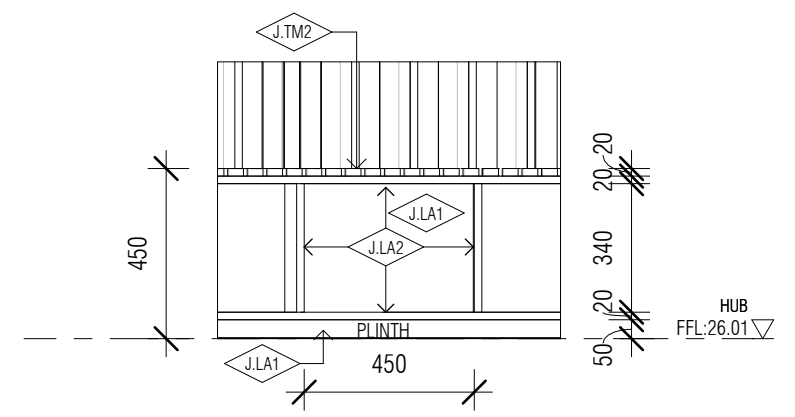

PRELIMINARY			
REV	ISSUE DATE	BY	REASON FOR ISSUE
00	5.02.25	ST	ISSUED TO CLIENT

ARCHITECT

SARAH LAKE ARCHITECTS

Level 1 242 Victoria Street
BRUNSWICK VIC 3056
info@sarahlake.com.au
www.sarahlake.com.au

PROJECT DETAILS

PROJECT: **AUSTRALIAN DRYLANDS LEARNING HUB MELBOURNE**

CLIENT: **RBGV**

ALL WORKS TO BE CARRIED OUT TO AUSTRALIAN STANDARDS AND TO COMPLY WITH THE BUILDING CODE OF AUSTRALIA
ALL DIMENSIONS TO BE CHECKED ON SITE PRIOR TO WORKS COMMENCING

DRAWING

TITLE: **INTERNAL ELEVATIONS PROPOSED**

SCALE: **As indicated** JOB NUMBER: **2305**

DATE: **MAY 2023** DRAWN: **ST**

DRAWING NO: **DD503**