
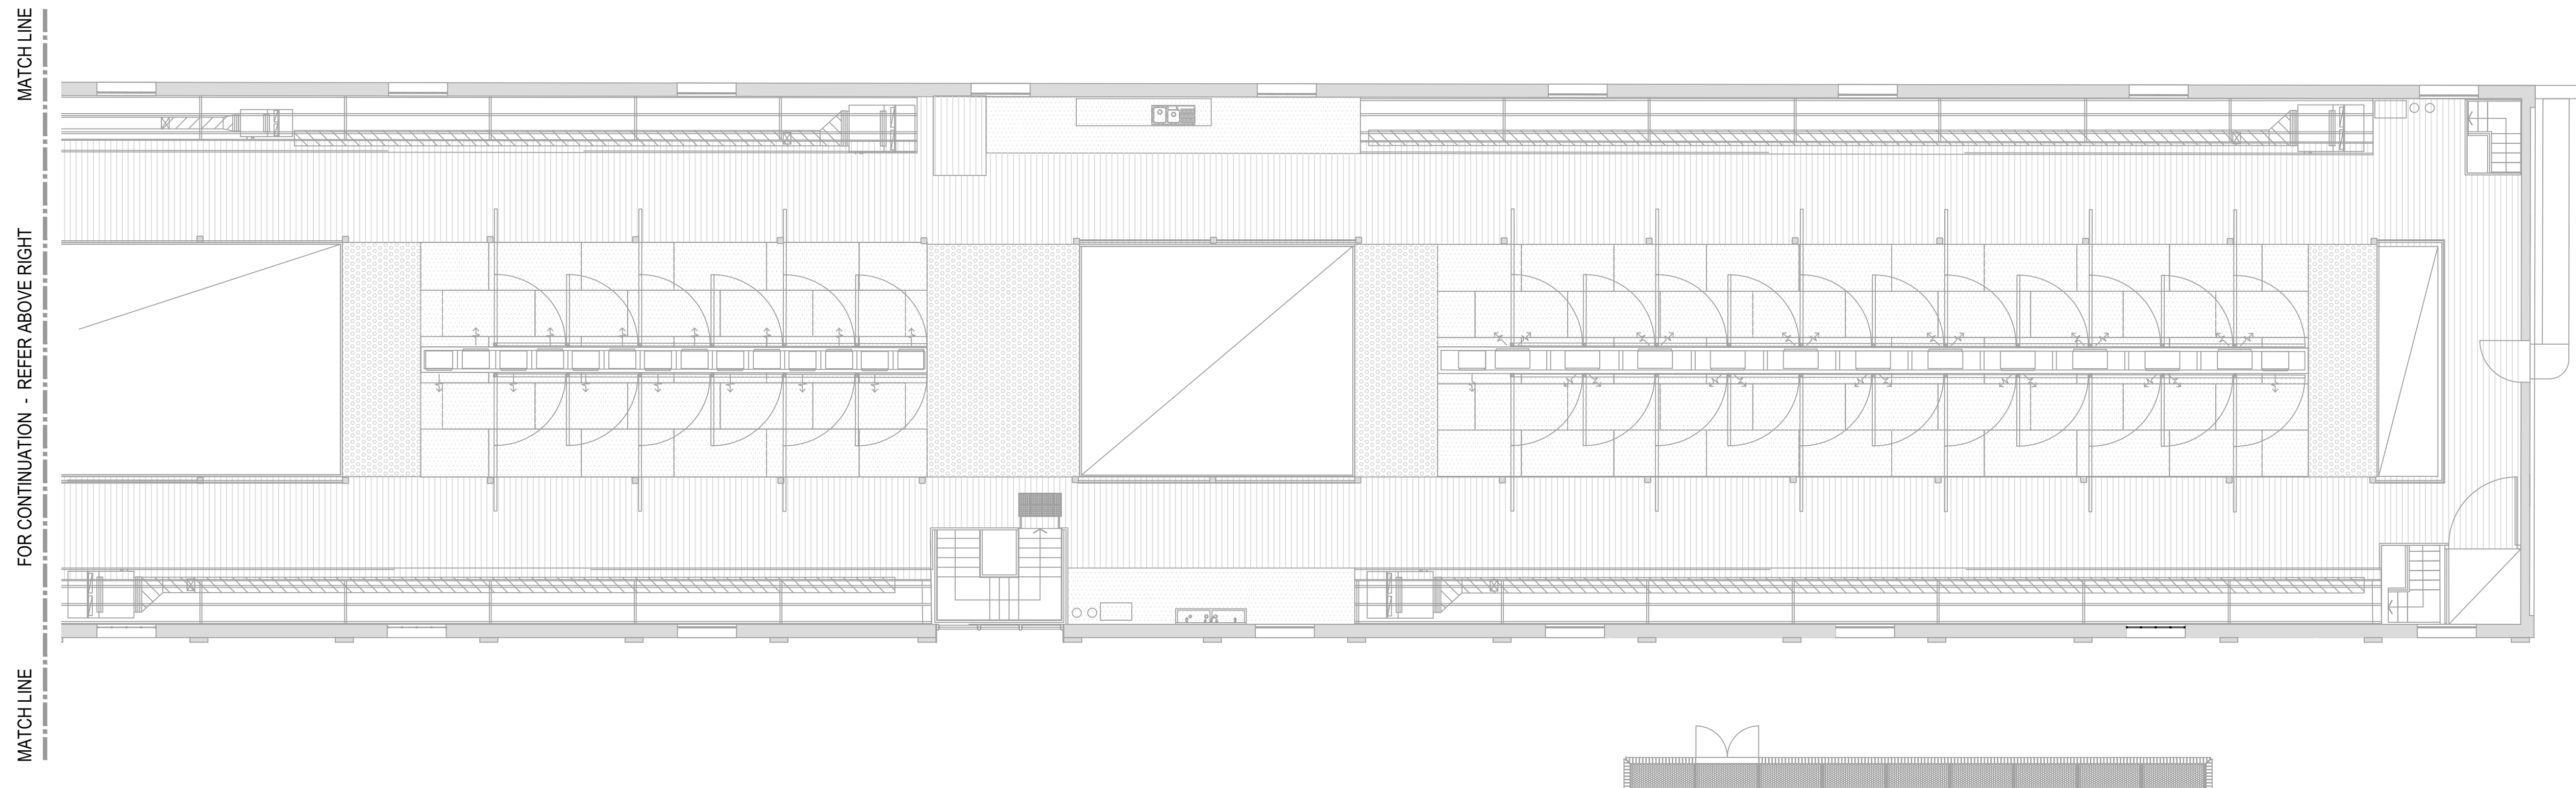


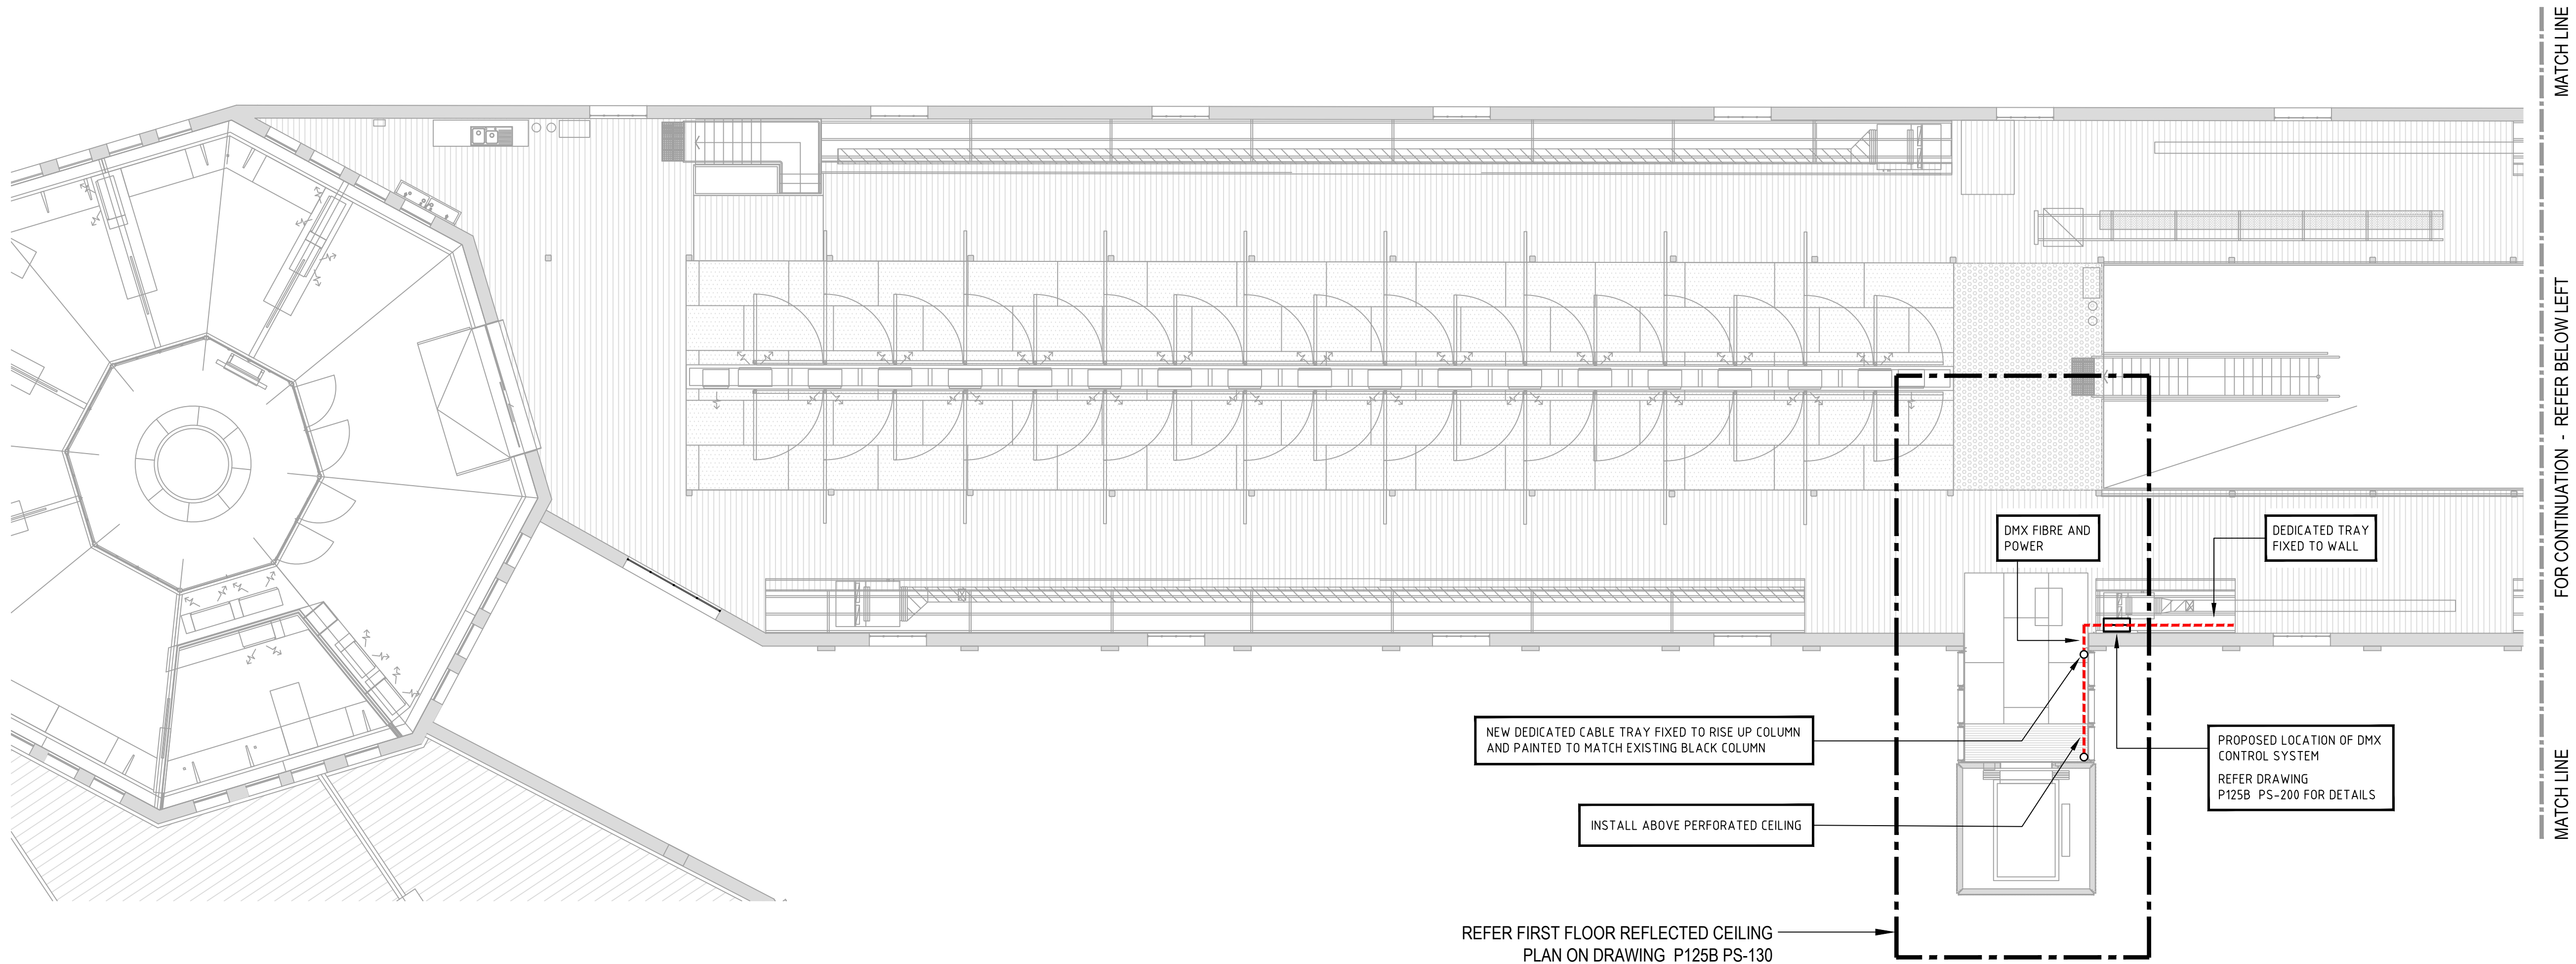

DO NOT SCALE - USE WRITTEN DIMENSIONS ONLY

03	20.12.23	DESIGN DEVELOPMENT	RH
02	11.05.23	DESIGN DEVELOPMENT	RH
01	13.02.23	DESIGN DEVELOPMENT	RH
No	DATE	AMENDMENTS	AUT.

WEB3 CONSULTING ELECTRICAL ENGINEERS
LIGHTING CONSULTANTS
TECHNOLOGY CONSULTANTS
WEBB AUSTRALIA GROUP (AC) PTY LIMITED ACN 071 985 905
LEVEL 9, 738 EDMONDSON STREET, MELBOURNE, VIC 3000, AUSTRALIA
TELEPHONE 03 9658 8893 FACSIMILE 03 9658 8800
EMAIL: info@webb3.com.au
COPYRIGHT © WEBB AUSTRALIA GROUP (AC) PTY LIMITED 2023. ALL RIGHTS RESERVED. THIS DRAWING
MAY NOT BE REPRODUCED OR TRANSMITTED IN ANY FORM OR BY ANY MEANS, ELECTRONIC OR MECHANICAL,
INCLUDING PHOTOCOPYING, RECORDING, OR BY ANY INFORMATION STORAGE AND RETRIEVAL SYSTEM, WITHOUT
THE WRITTEN PERMISSION OF WEBB AUSTRALIA GROUP (AC) PTY LIMITED. THESE DRAWINGS ARE PRELIMINARY AND SHALL BE
USED IN CONJUNCTION WITH ALL CONTRACT DOCUMENTATION. SHOULD ANY AMBIGUITY, ERROR, OMISSION,
DISCREPANCY, INCONSISTENCY OR CONTRADICTION ARISE, THE USER SHALL REFER TO THE CONTRACT DOCUMENTATION AND THE
CONTRACT ADMINISTRATOR IN WRITING.

CONSULTANT'S DRAWING APPROVAL

PASSED	APPROVED
--------	----------

CITY OF MELBOURNE
CITY DESIGN STUDIO
LEVEL 6 / 240 LT COLLINS STREET
MELBOURNE VIC 3000
TELEPHONE: (03) 9658 8893
FACSIMILE: (03) 9658 8840

CLIENT
CITY OF MELBOURNE

PROJECT
DODDS STREET
ELECTRICAL WORKS
THE STBALES BUILDING - ARTWORK K

DRAWING
FIRST FLOOR


STATUS
DESIGN DEVELOPMENT

PASSED / REVIEWED	APPROVED / AUTH. FOR USE
-------------------	--------------------------


NORTH POINT 	DESIGN RH	DRAWN AP
	A1 1:100	A3 1:200
DATE PLOTTED 20.12.23		

PROJ. NO. P125B	DWG. NO. PS-110	REV. 03
--------------------	--------------------	------------


© COPYRIGHT 2023 CITY OF MELBOURNE

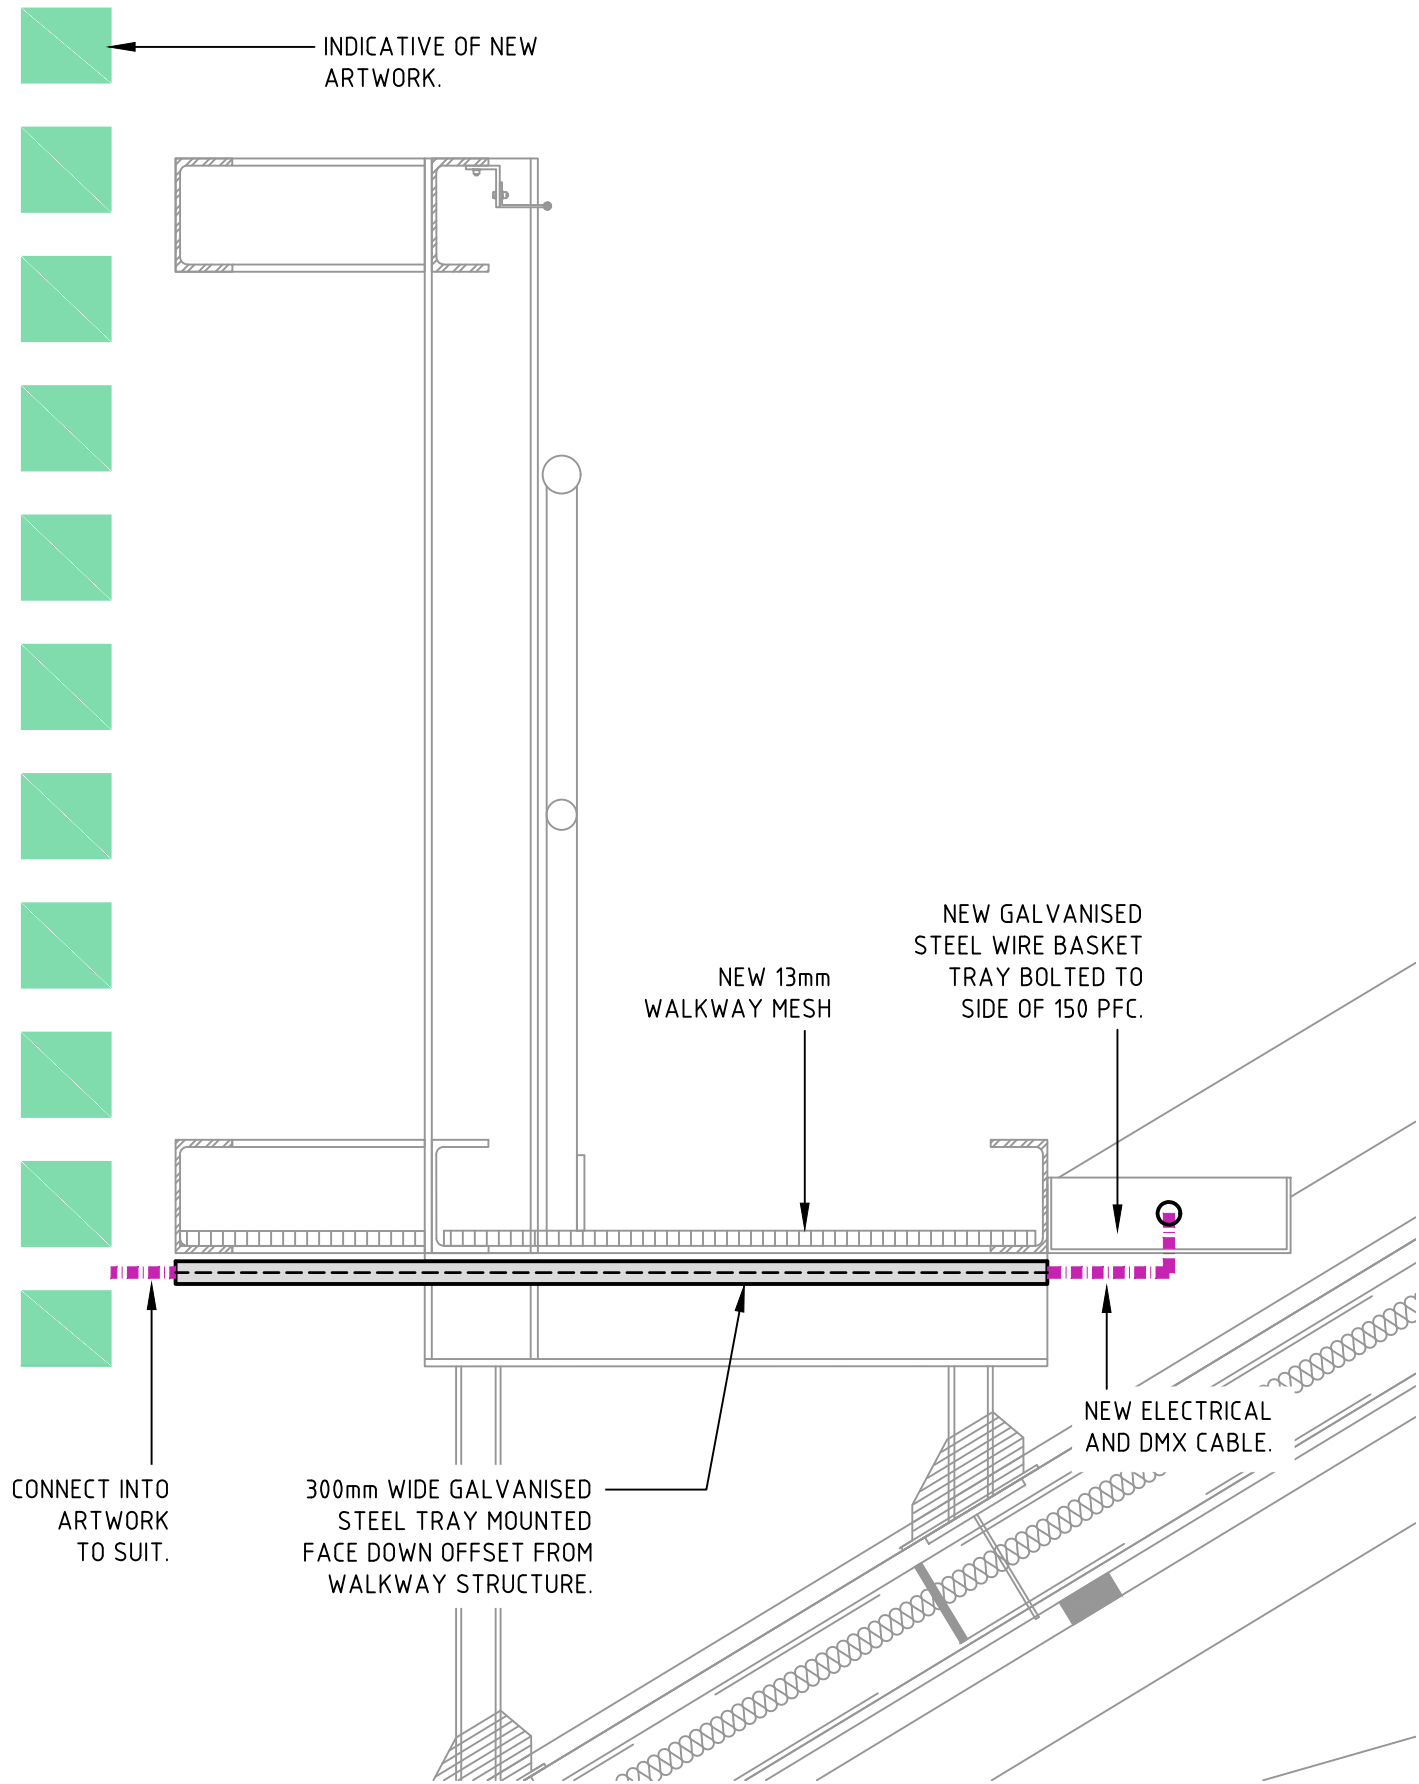


WALKWAY SECTION DETAIL
SCALE 1:10 @ A1

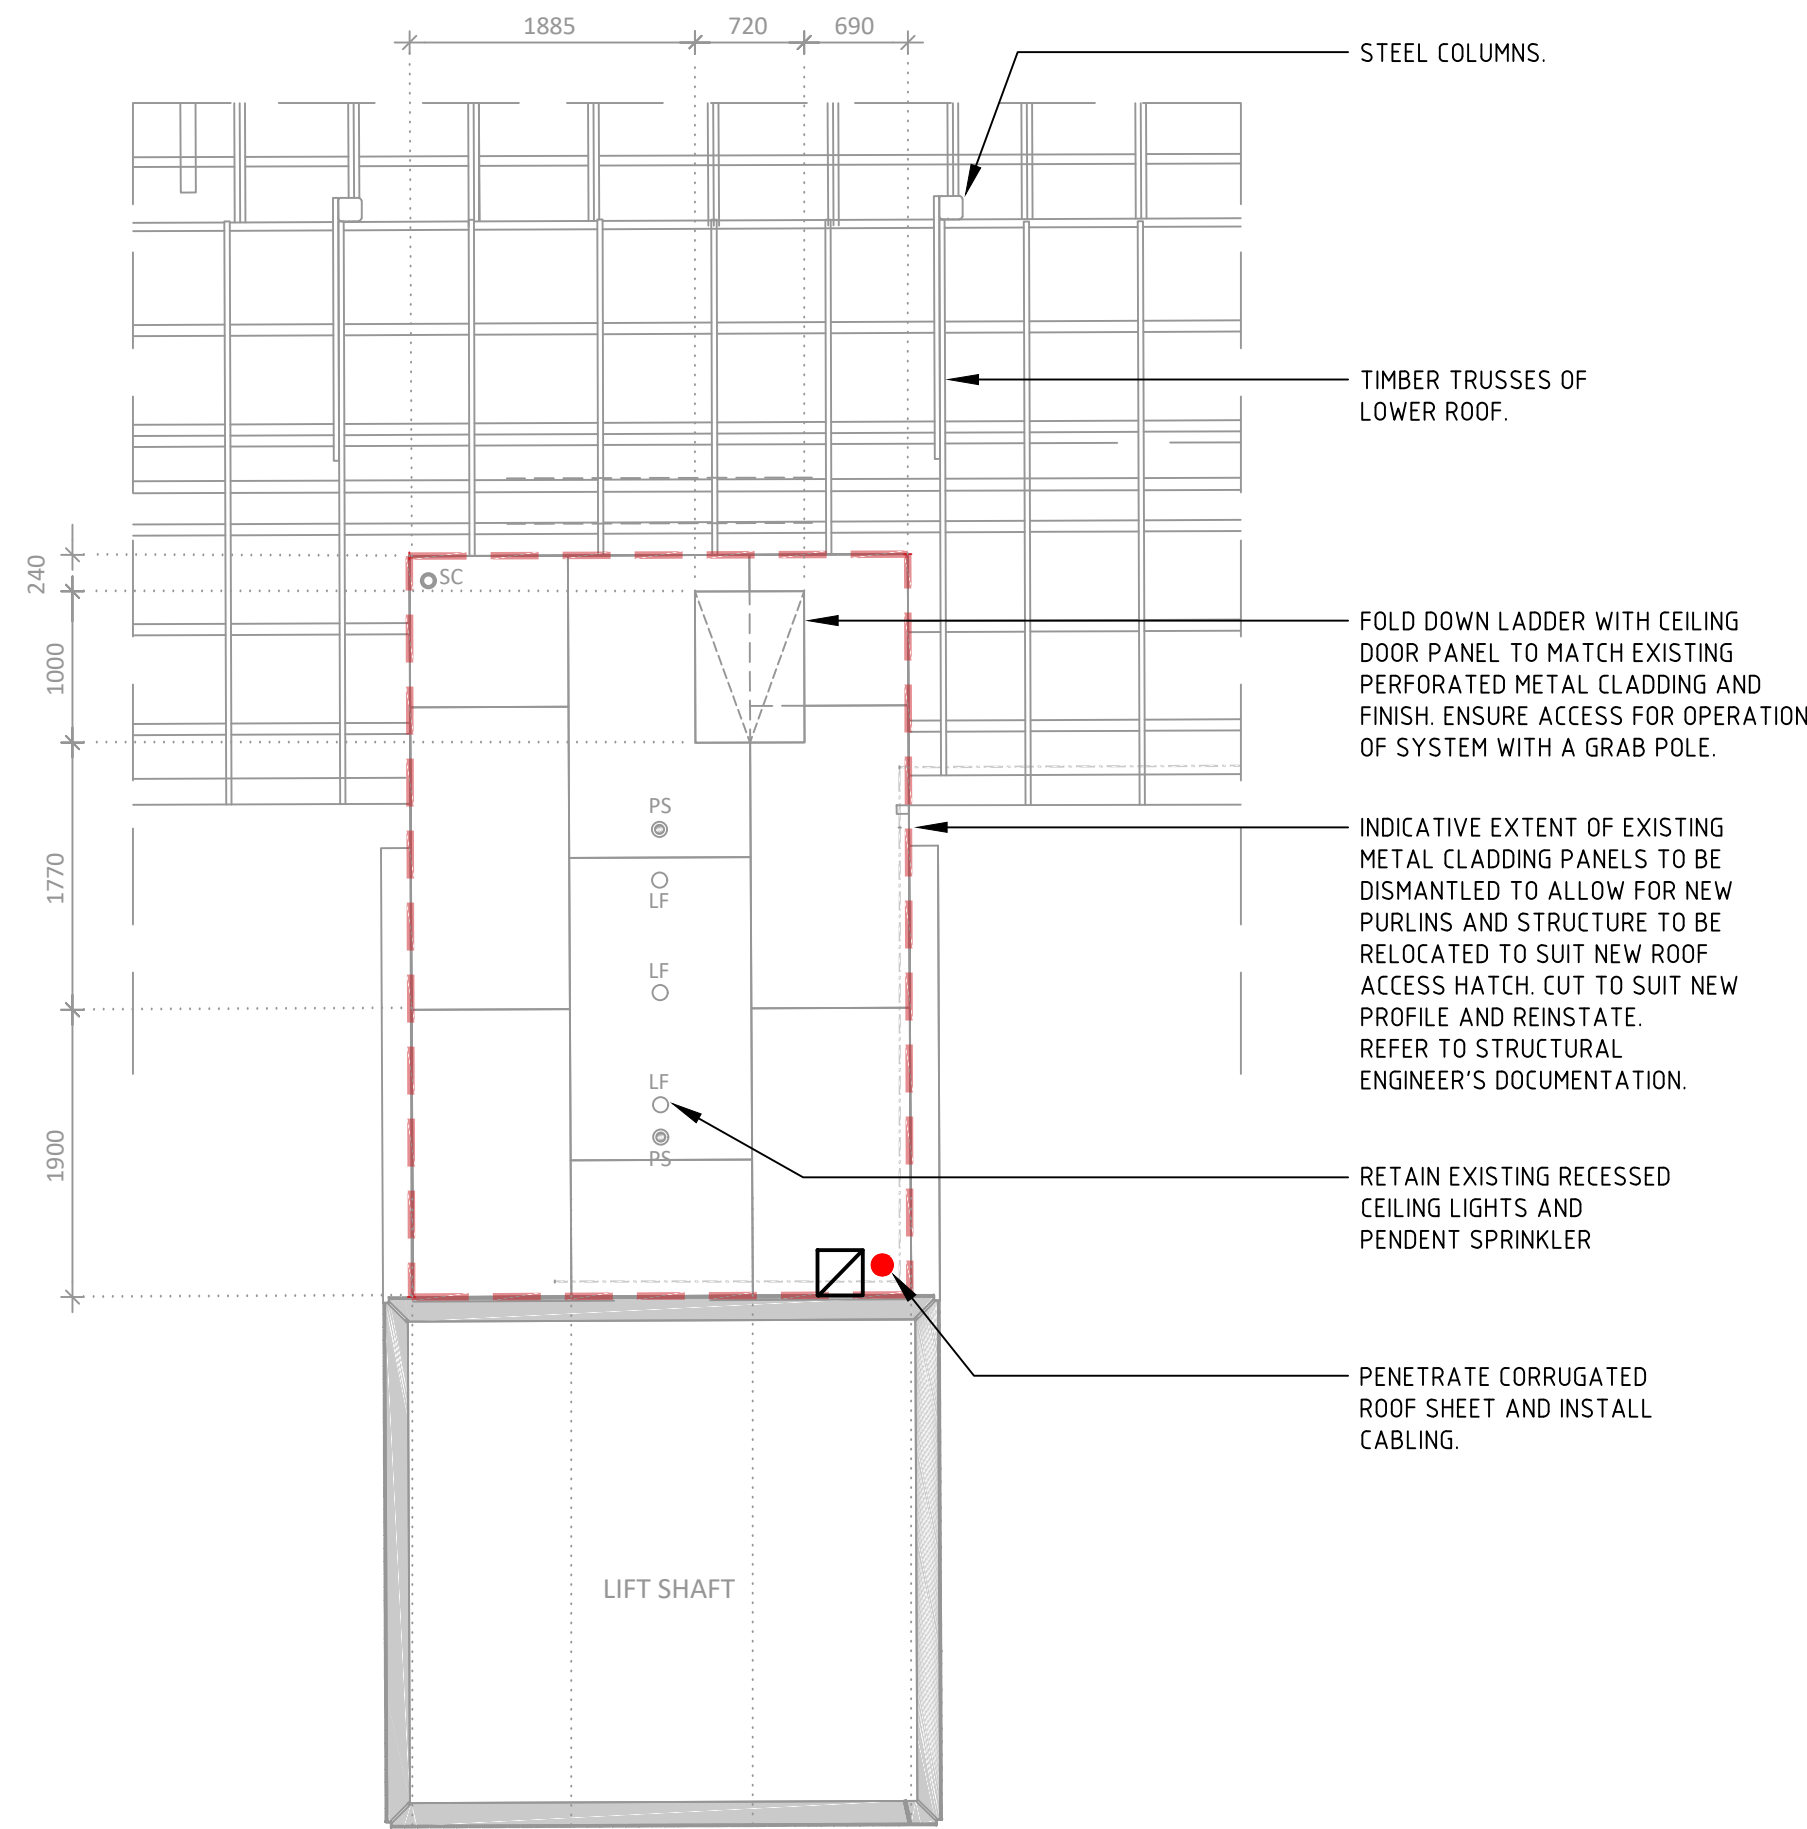

FIRST FLOOR REFLECTED CEILING PLAN
SCALE 1:50 @ A1

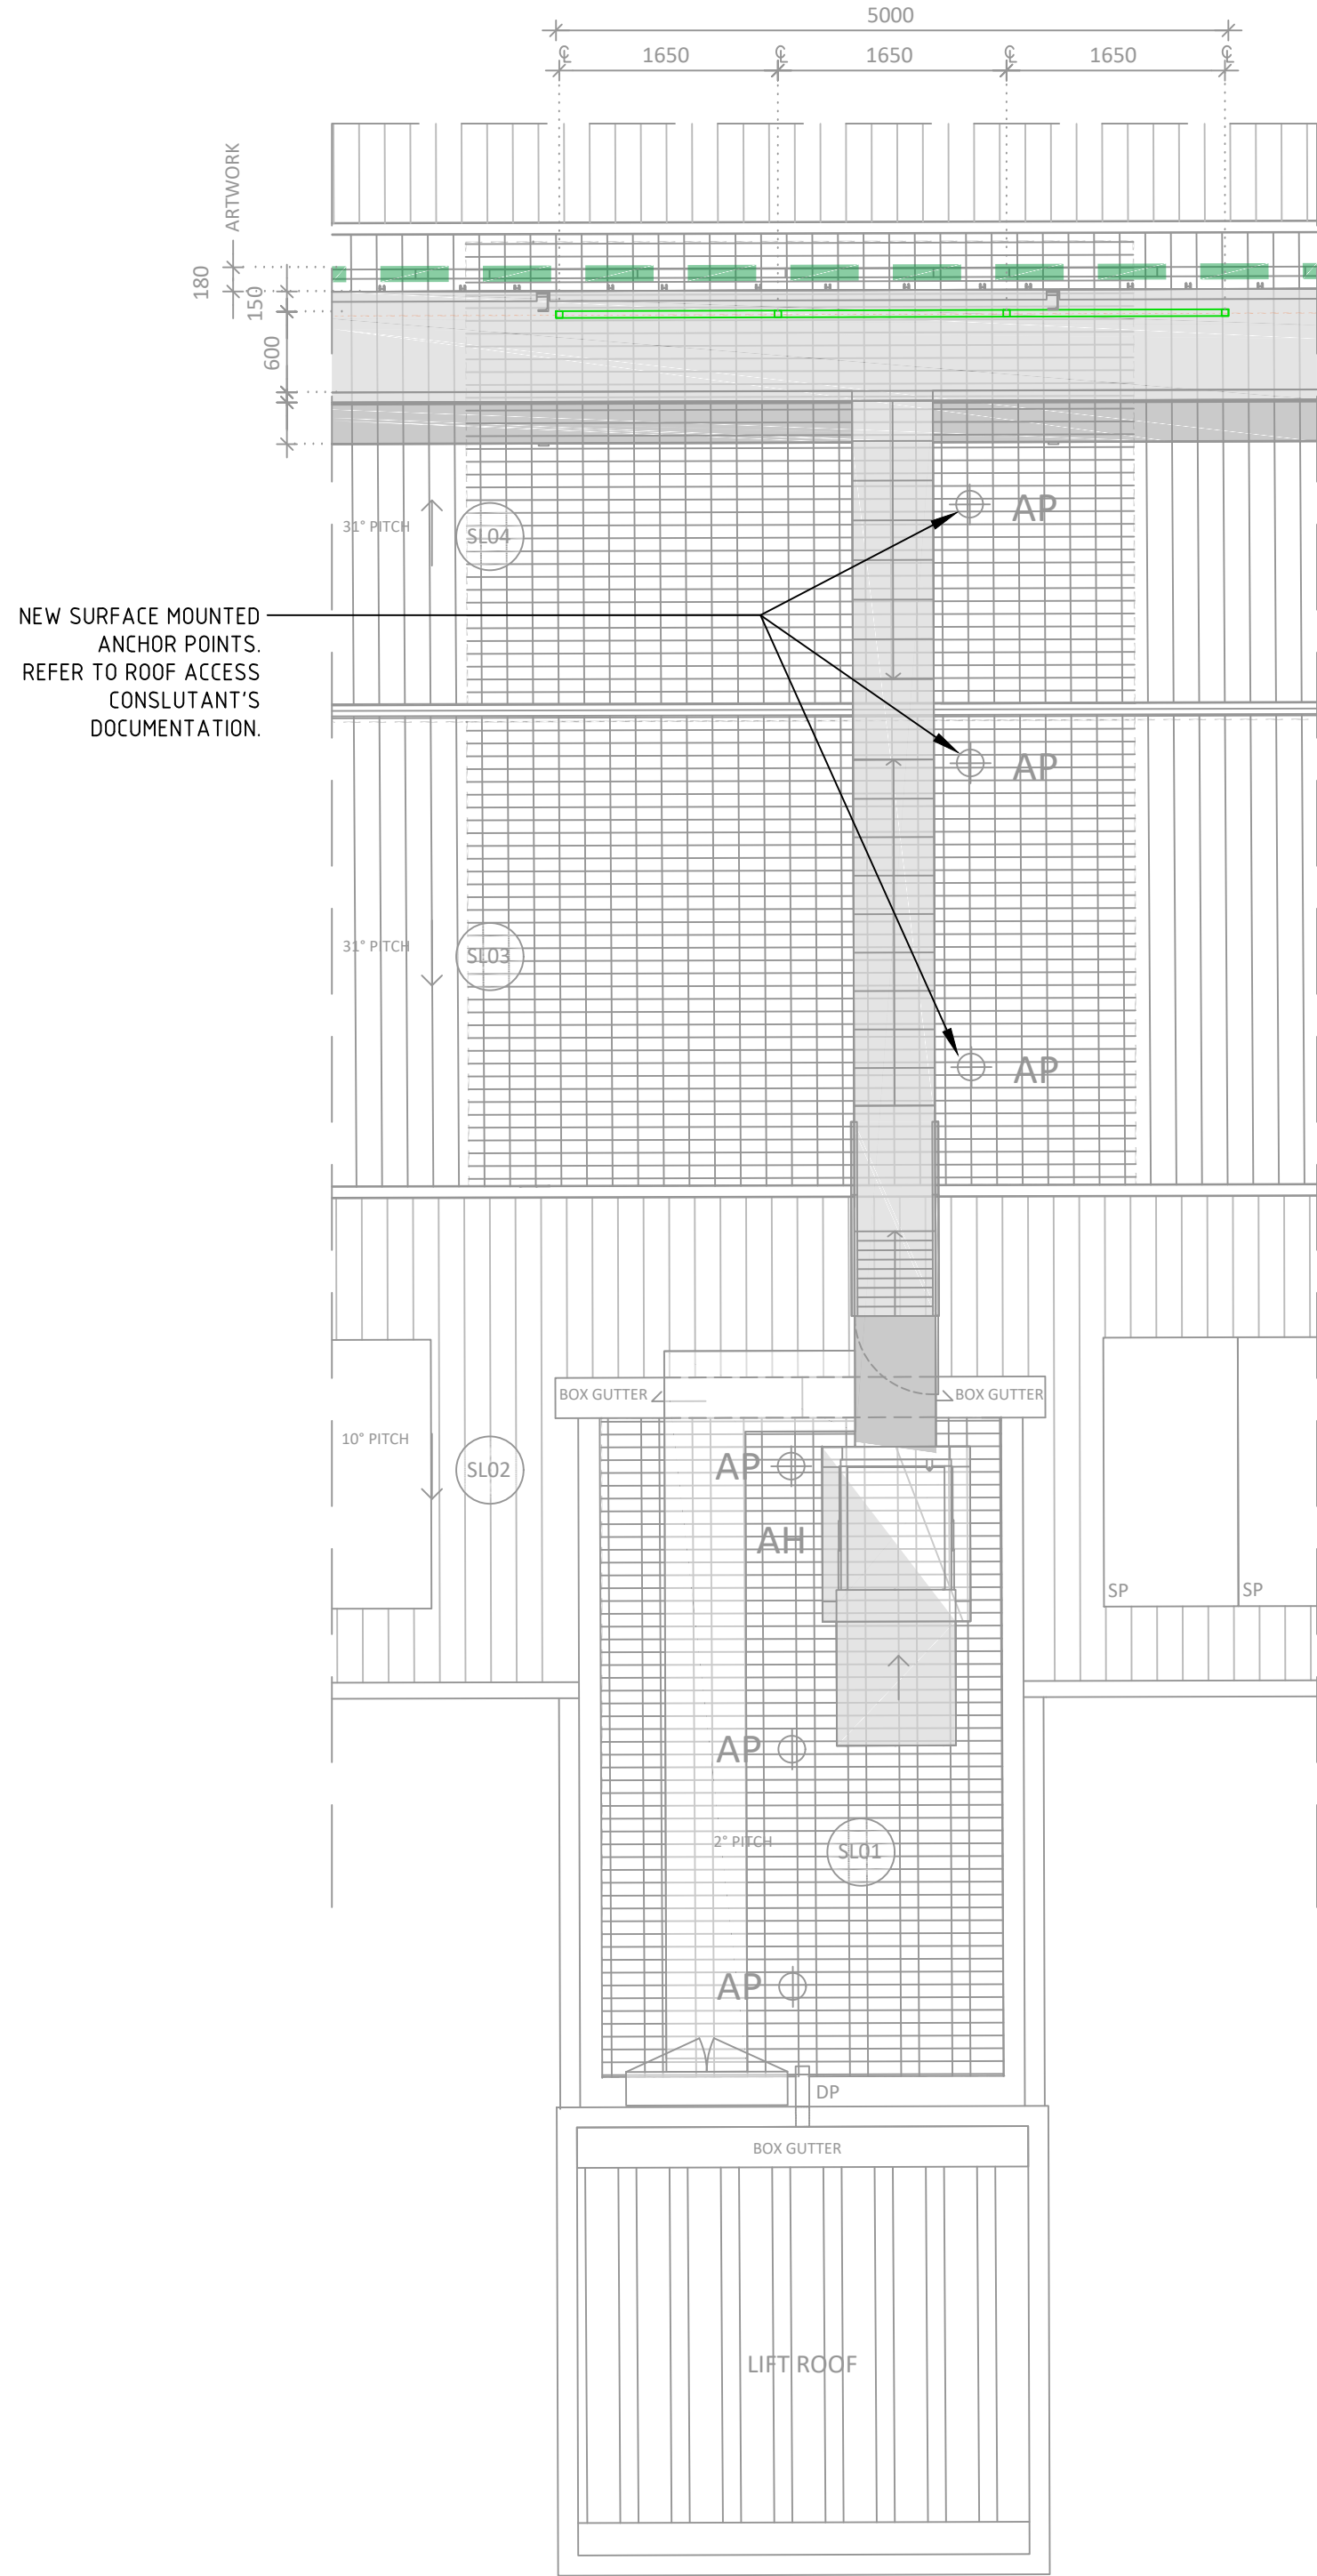

ROOF PLAN - ROOF ACCESS
SCALE 1:50 @ A1

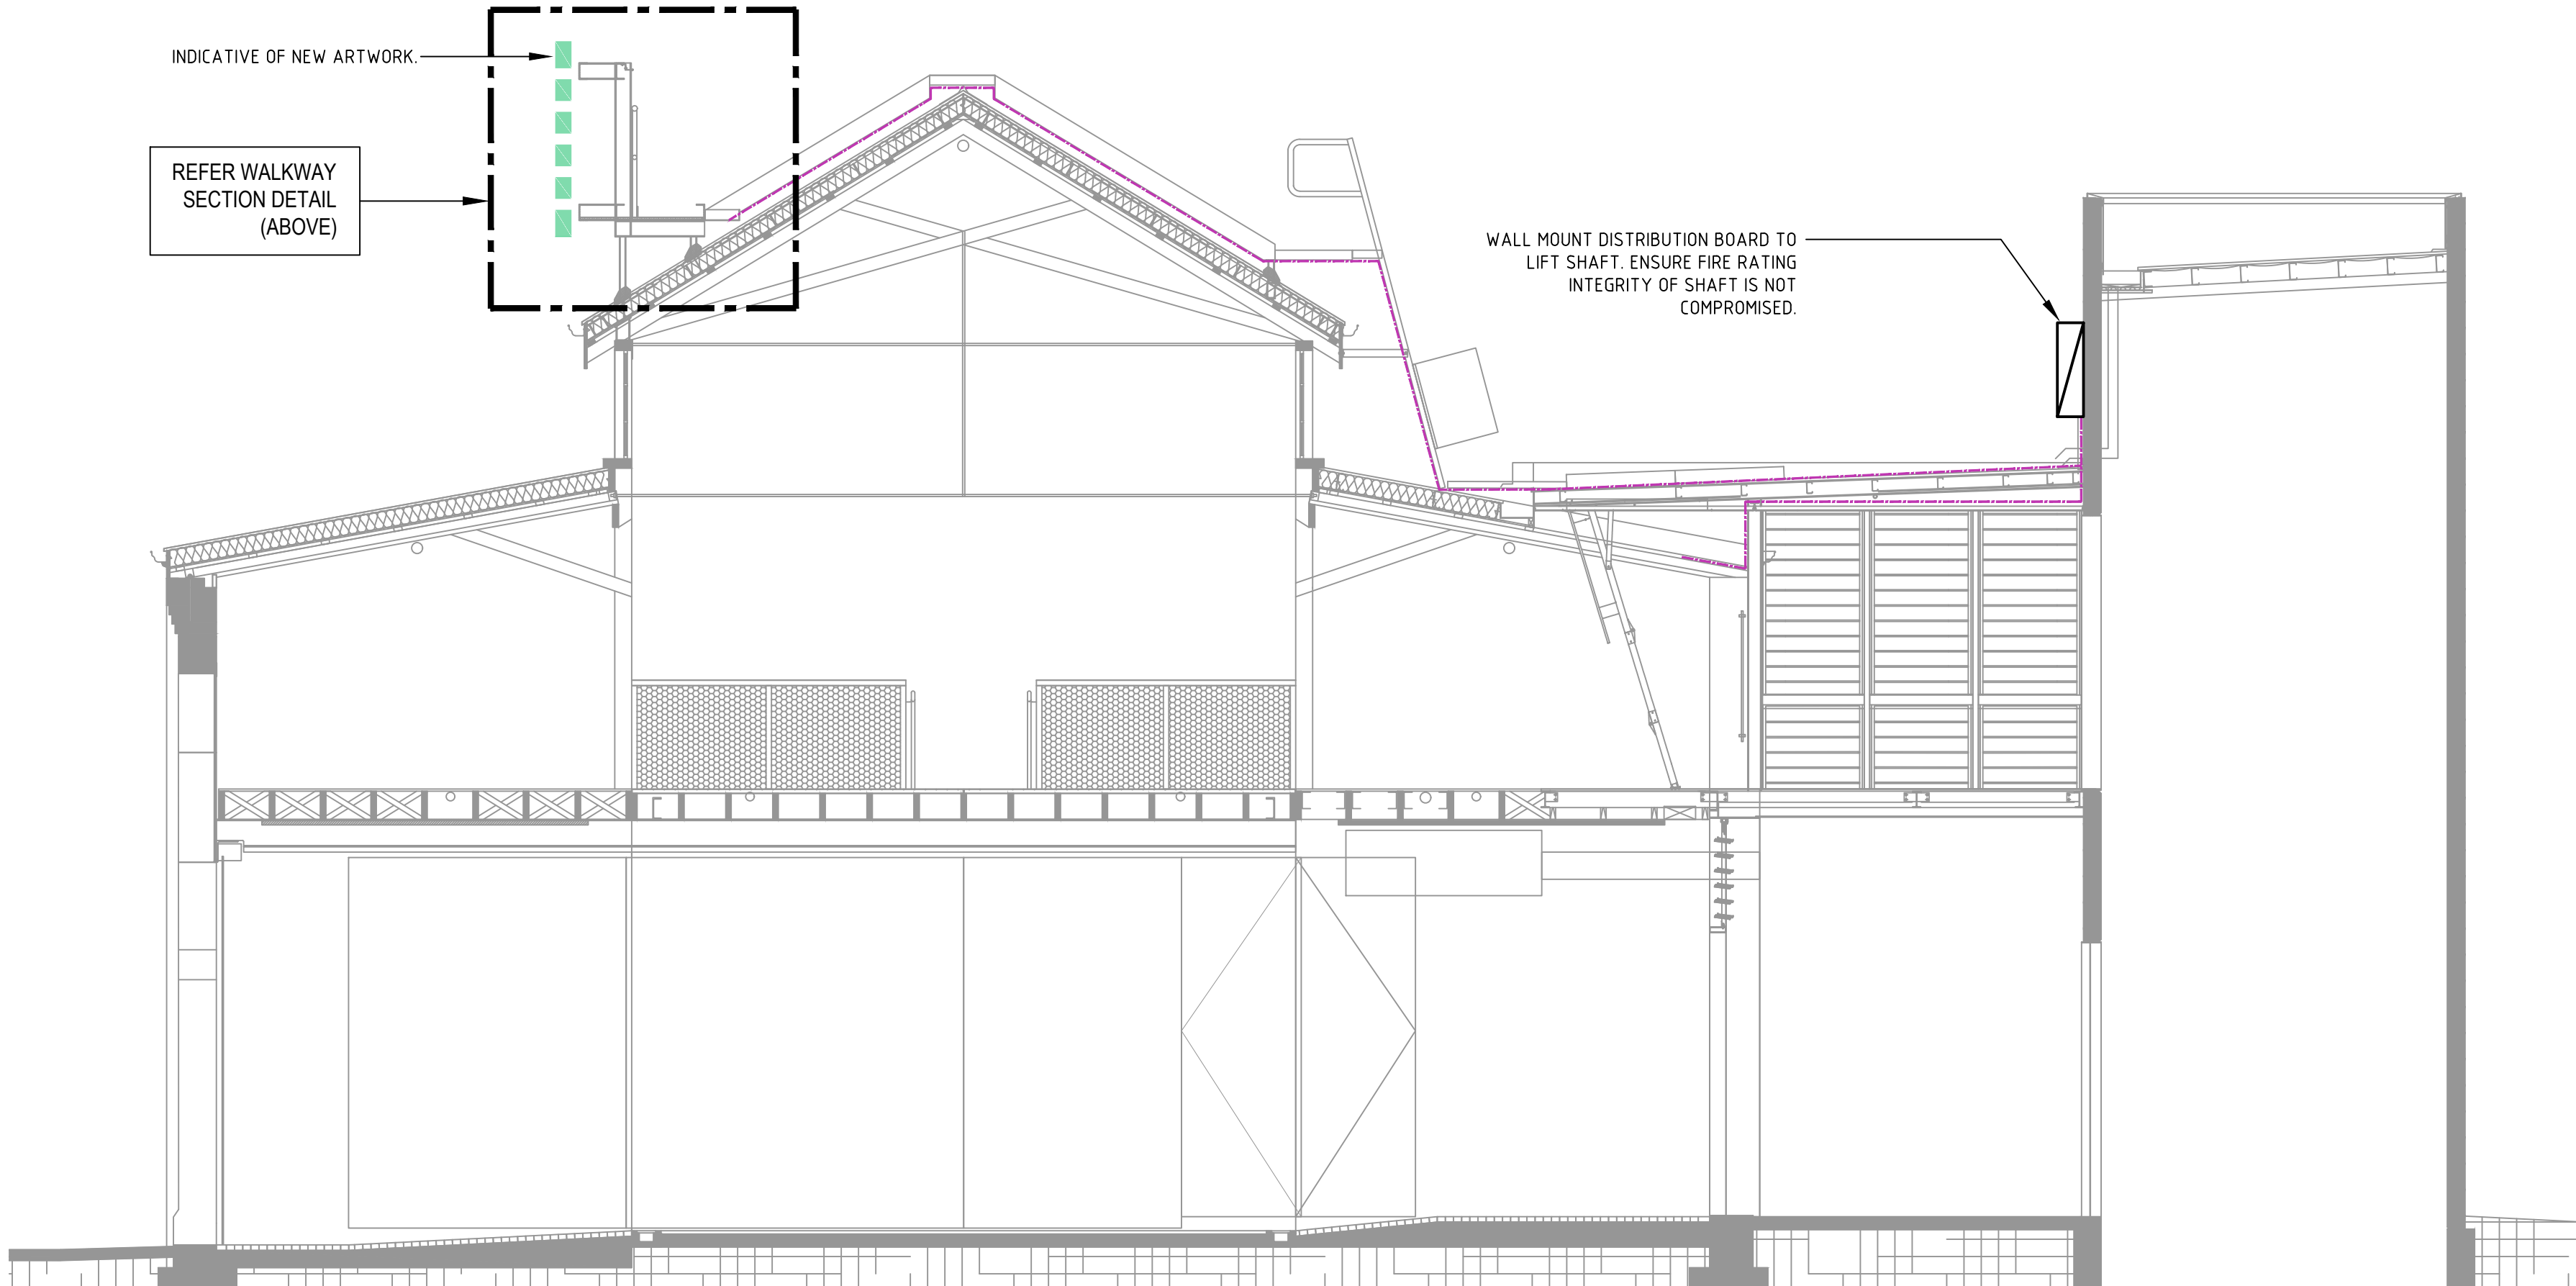

SECTION
SCALE 1:50 @ A1

DO NOT SCALE - USE WRITTEN DIMENSIONS ONLY

03	20.12.23	DESIGN DEVELOPMENT	RH
02	11.05.23	DESIGN DEVELOPMENT	RH
01	13.02.23	DESIGN DEVELOPMENT	RH
No	DATE	AMENDMENTS	AUT.

WEB3 CONSULTING ELECTRICAL ENGINEERS
LIGHTING CONSULTANTS
TECHNOLOGY CONSULTANTS
WEBB AUSTRALIA GROUP (AC) PTY LIMITED ACN 071 885 305
LEVEL 9, 738 CONVENT STREET, MELBOURNE, VIC 3000, AUSTRALIA
TELEPHONE: (03) 9658 8893 FACSIMILE: (03) 9658 8880
EMAIL: melbourn@webb3.com.au

COPYRIGHT © WEBB AUSTRALIA GROUP (AC) PTY LTD. ALL RIGHTS RESERVED. THIS DRAWING, AND ANY INFORMATION OR INFORMATION CONTAINED HEREIN, IS THE PROPERTY OF WEBB AUSTRALIA GROUP (AC) PTY LTD. IT IS TO BE USED ONLY FOR THE PROJECT AND SHALL BE RETURNED TO WEBB AUSTRALIA GROUP (AC) PTY LTD. UPON COMPLETION OF THE PROJECT. NO PART OF THIS DRAWING IS TO BE REPRODUCED OR TRANSMITTED IN ANY FORM OR BY ANY MEANS, WITHOUT THE WRITTEN PERMISSION OF WEBB AUSTRALIA GROUP (AC) PTY LTD. THIS DRAWING AND ANY INFORMATION CONTAINED HEREIN, IS THE PROPERTY OF WEBB AUSTRALIA GROUP (AC) PTY LTD. IT IS TO BE USED ONLY FOR THE PROJECT AND SHALL BE RETURNED TO WEBB AUSTRALIA GROUP (AC) PTY LTD. UPON COMPLETION OF THE PROJECT. NO PART OF THIS DRAWING IS TO BE REPRODUCED OR TRANSMITTED IN ANY FORM OR BY ANY MEANS, WITHOUT THE WRITTEN PERMISSION OF WEBB AUSTRALIA GROUP (AC) PTY LTD.

CONSULTANT'S DRAWING APPROVAL

PASSED APPROVED



CITY DESIGN STUDIO

LEVEL 6 / 240 LT COLLINS STREET
MELBOURNE VIC 3000
TELEPHONE: (03) 9658 8893
FACSIMILE: (03) 9658 8840

CLIENT
CITY OF MELBOURNE

PROJECT
DODDS STREET
ELECTRICAL WORKS
THE STABLES BUILDING - ARTWORK K

DRAWING
DETAIL PLANS AND SECTIONS

STATUS
DESIGN DEVELOPMENT

PASSED / REVIEWED APPROVED / AUTH. FOR USE


NORTH POINT
DESIGN RH
DRAWN AP
A1 AS SHOWN
A3 AS SHOWN

DATE PLOTTED
20.12.23

PROJ. NO. P125B
DWG. NO. PS-130
REV. 03

© COPYRIGHT 2023 CITY OF MELBOURNE

MAIN SWITCHBOARD

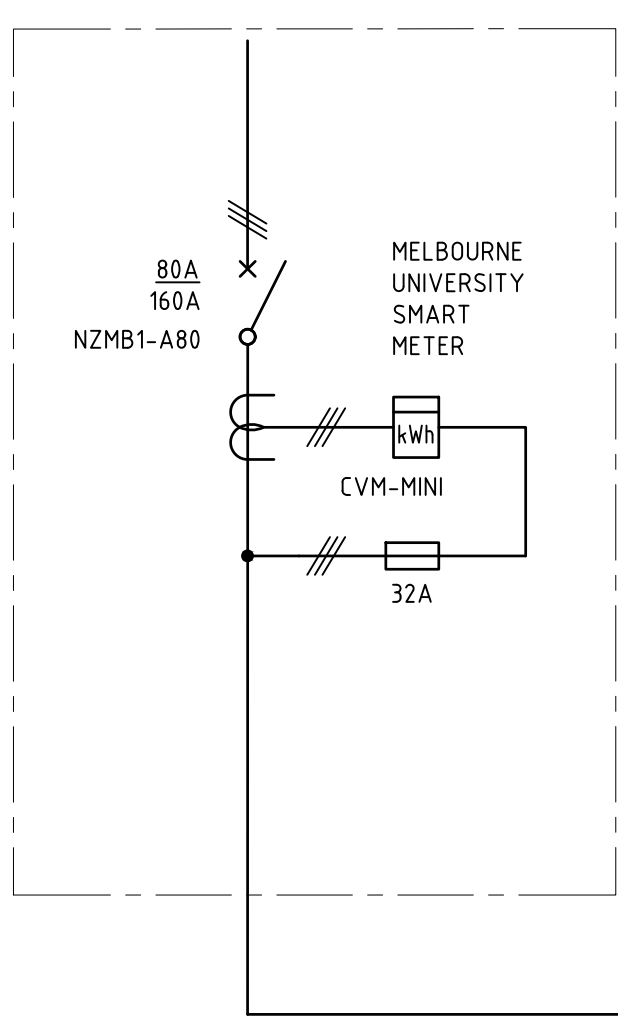

25mm² XLPE 4x 1C
+ 16mm² EARTH.

160A
NON-AUTO
ISOLATOR

20A

16A

16A

SPARE
SPACES

15 No.
16A RCBs
TOTAL

4mm² 2C+E
PVC/PVC

SUPPLY TO
DMX CONTROLLER
(FIRST FLOOR)

4mm² 2C+E

CIRCUIT
N1


4mm² 2C+E

CIRCUIT
N24

TO
JUNCTION BOX

NOTE:

THREE PHASE REQUESTED FOR EACH LETTER
HOWEVER, NO MORE THAN 8A AT 240V (SINGLE PHASE SUITABLE).
ALSO, MEAN WELL TRANSFORMERS SHOWN ARE SINGLE PHASE.

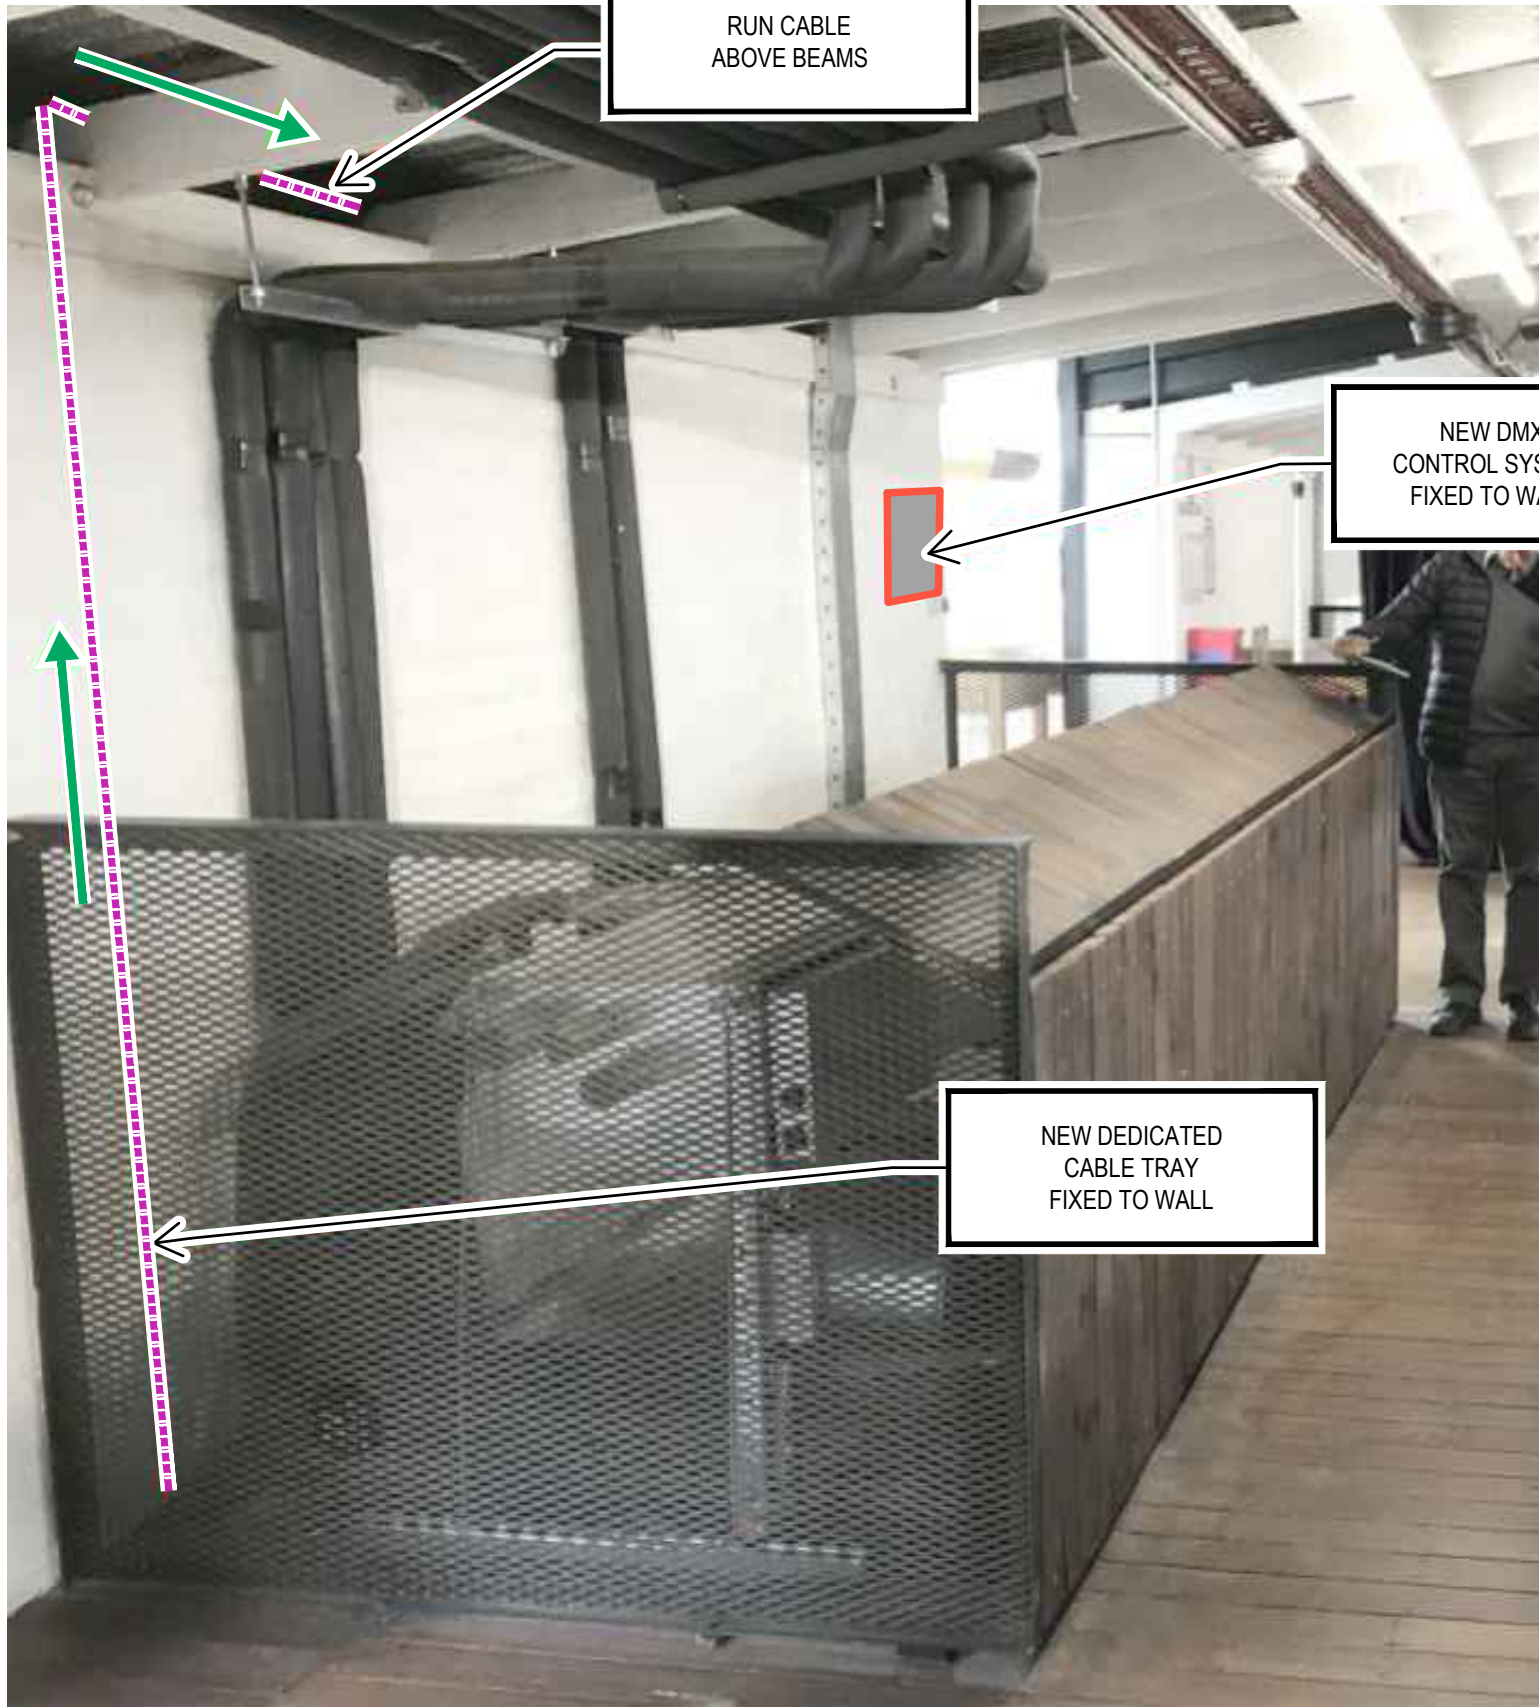

FIRST FLOOR - CABLE ROUTE AND DMX CONTROL SYSTEM


ROOF ARTWORK DISTRIBUTION BOARD - DB / ARTWORK
SINGLE LINE DIAGRAM

TYPE: "CONCEPT PREMIER" IP66 WITH RAIN HOOD.

- IMPACT PROTECTION RATING: IP66
- FINISH: DARK GREY
- 48 POLE
- CLO01 KEYED DOOR SWING HANDLE
- DIMENSIONS: 864mm (HEIGHT) x 600mm (WIDTH) x 240mm (DEPTH)
- WEIGHT: APPROXIMATELY 70kgs
- MOUNT TO LIFT RISER 400mm OFF GROUND




EXISTING MAIN SWITCHBOARD
SPARE COMPARTMENT
"EATON" BOARD

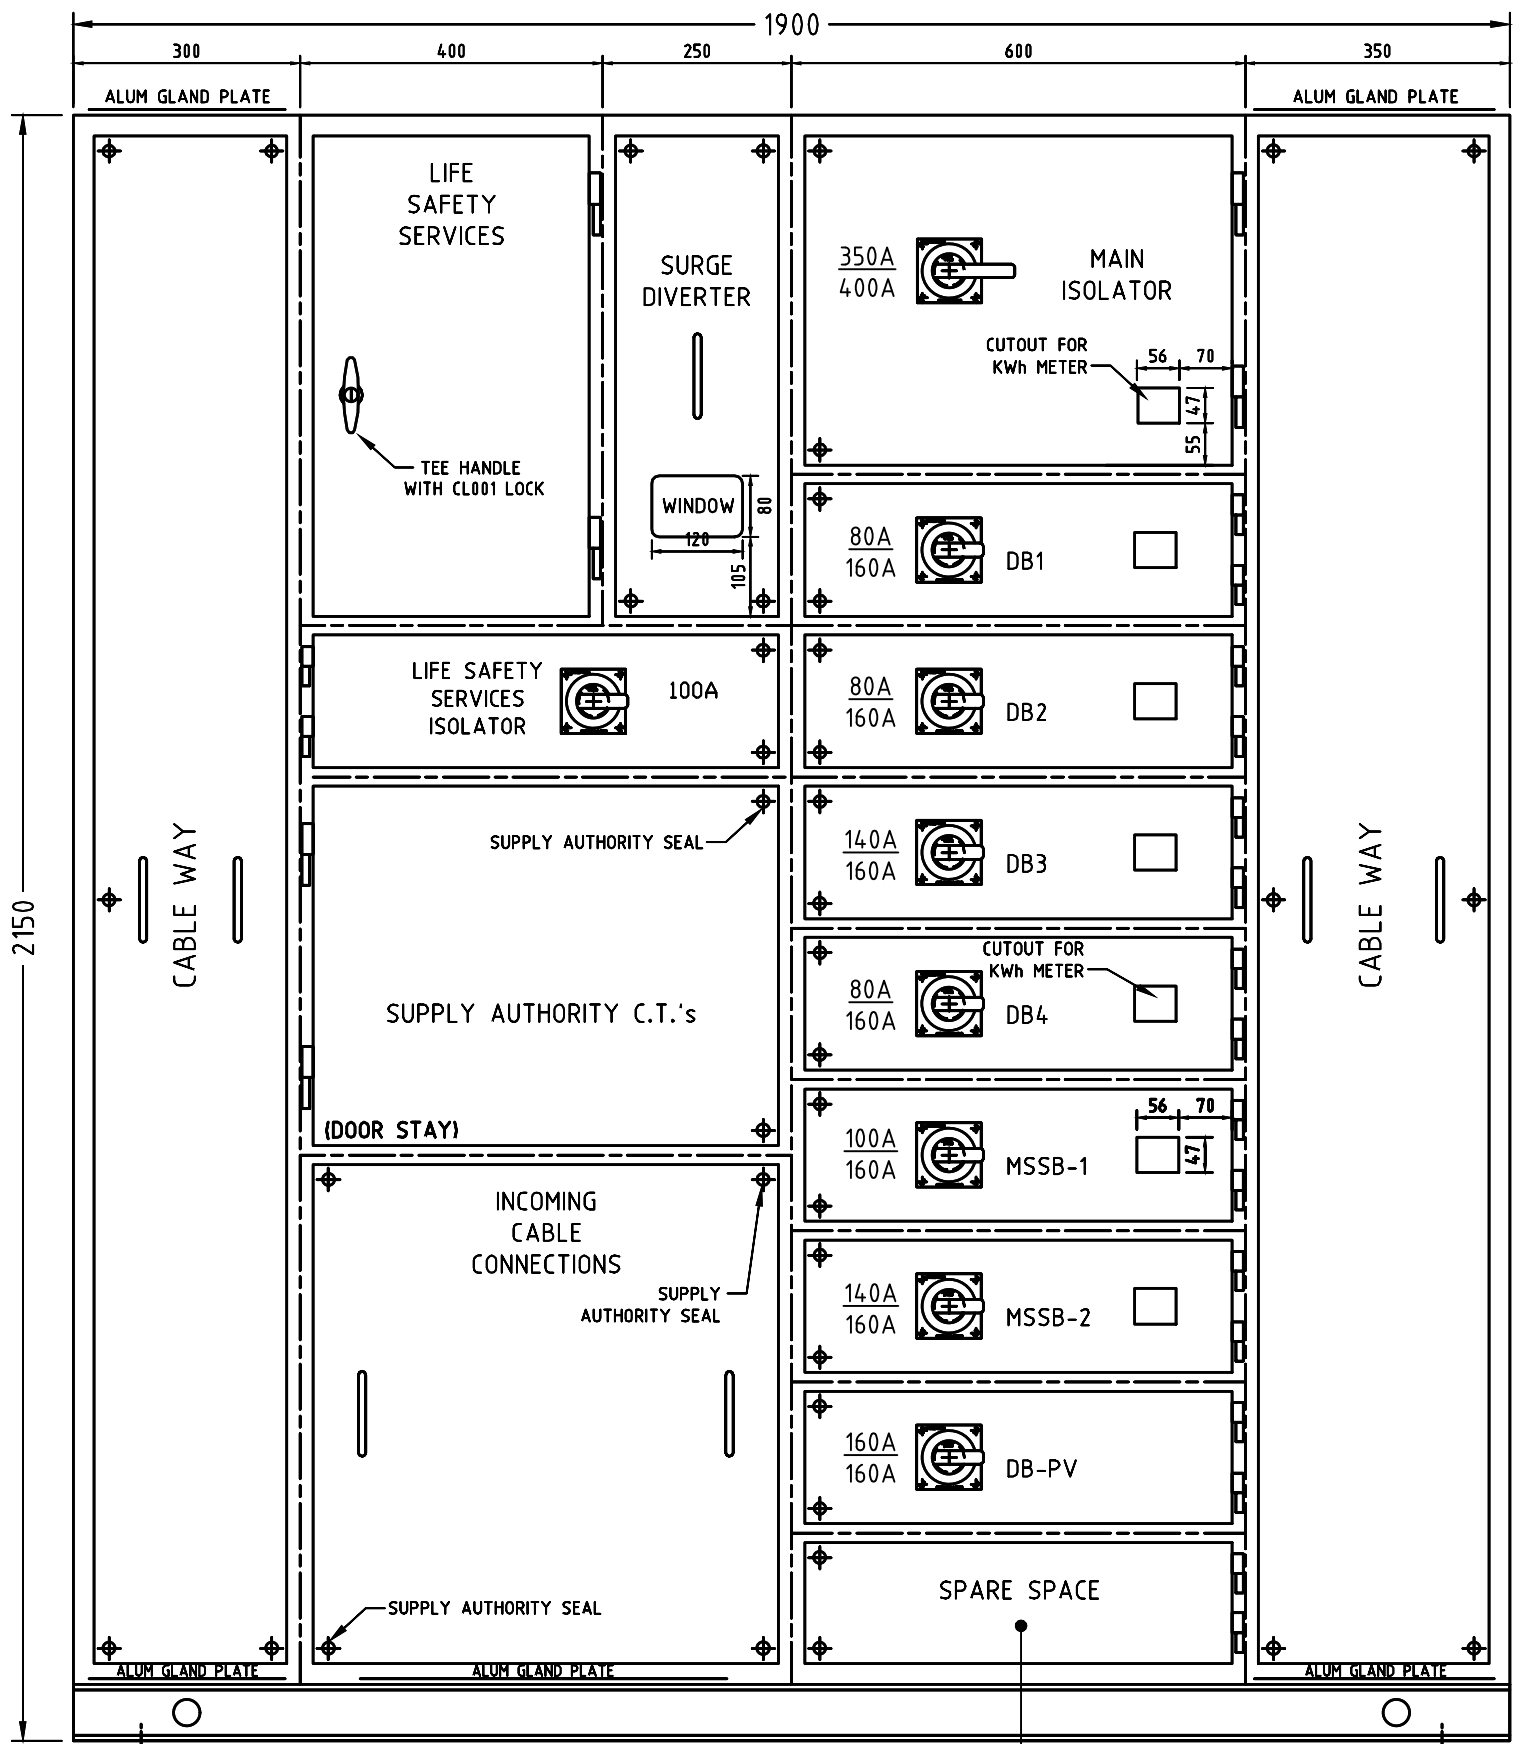

EXISTING MAIN SWITCHBOARD
GENERAL ARRANGEMENT

SCALE 1:10

DO NOT SCALE - USE WRITTEN DIMENSIONS ONLY			
03	20.12.23	DESIGN DEVELOPMENT	RH
02	11.05.23	DESIGN DEVELOPMENT	RH
01	13.02.23	DESIGN DEVELOPMENT	RH
No	DATE	AMENDMENTS	AUT.

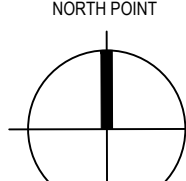WEB3 CONSULTING ELECTRICAL ENGINEERS LIGHTING CONSULTANTS TECHNOLOGY CONSULTANTS WEBB AUSTRALIA GROUP (A/C) PTY LIMITED ACN 071 885 305 LEVEL 9 / 738 CONVENT STREET, MELBOURNE, VIC 3000, AUSTRALIA TELEPHONE: (03) 9658 0000 FACSIMILE: (03) 9658 0000 EMAIL: melb@webb3.com.au COPYRIGHT © WEBB AUSTRALIA GROUP (A/C) PTY LIMITED ACN 071 885 305. ALL RIGHTS RESERVED. THIS DRAWING MAY NOT BE REPRODUCED OR TRANSMITTED IN ANY FORM OR BY ANY MEANS, ELECTRONIC OR MECHANICAL, WITHOUT THE WRITTEN PERMISSION OF WEBB AUSTRALIA GROUP (A/C) PTY LIMITED. THESE DRAWINGS ARE PRELIMINARY AND SHALL BE READ IN CONJUNCTION WITH ALL CONTRACT DOCUMENTATION, SUCH AS ANY AMENDMENTS, ORDER, VARIATION, DISCREPANCY, NON-COMPLIANCE OR OTHER AS AID TO BE USED IN THE DOCUMENTS, AND SHALL BE VALIDITY THE CONTRACT ADMINISTRATION IN WRITING.		
CONSULTANT'S DRAWING APPROVAL		
PASSED	APPROVED	
CITY OF MELBOURNE CITY DESIGN STUDIO LEVEL 6 / 240 LT COLLINS STREET MELBOURNE VIC 3000 TELEPHONE: (03) 9658 8893 FACSIMILE: (03) 9658 8840		
CLIENT CITY OF MELBOURNE		
PROJECT DODDS STREET ELECTRICAL WORKS THE STABLES BUILDING - ARTWORK K		
DRAWING SCHEMATIC DIAGRAMS AND DETAILS		
STATUS DESIGN DEVELOPMENT		
PASSED / REVIEWED	APPROVED / AUTH. FOR USE	
NORTH POINT  DESIGN RH AS SHOWN DRAWN AP A3 AS SHOWN DATE PLOTTED 20.12.23		
PROJ. NO P125B	DWG. NO PS-200	REV. 03
© COPYRIGHT 2023 CITY OF MELBOURNE		