


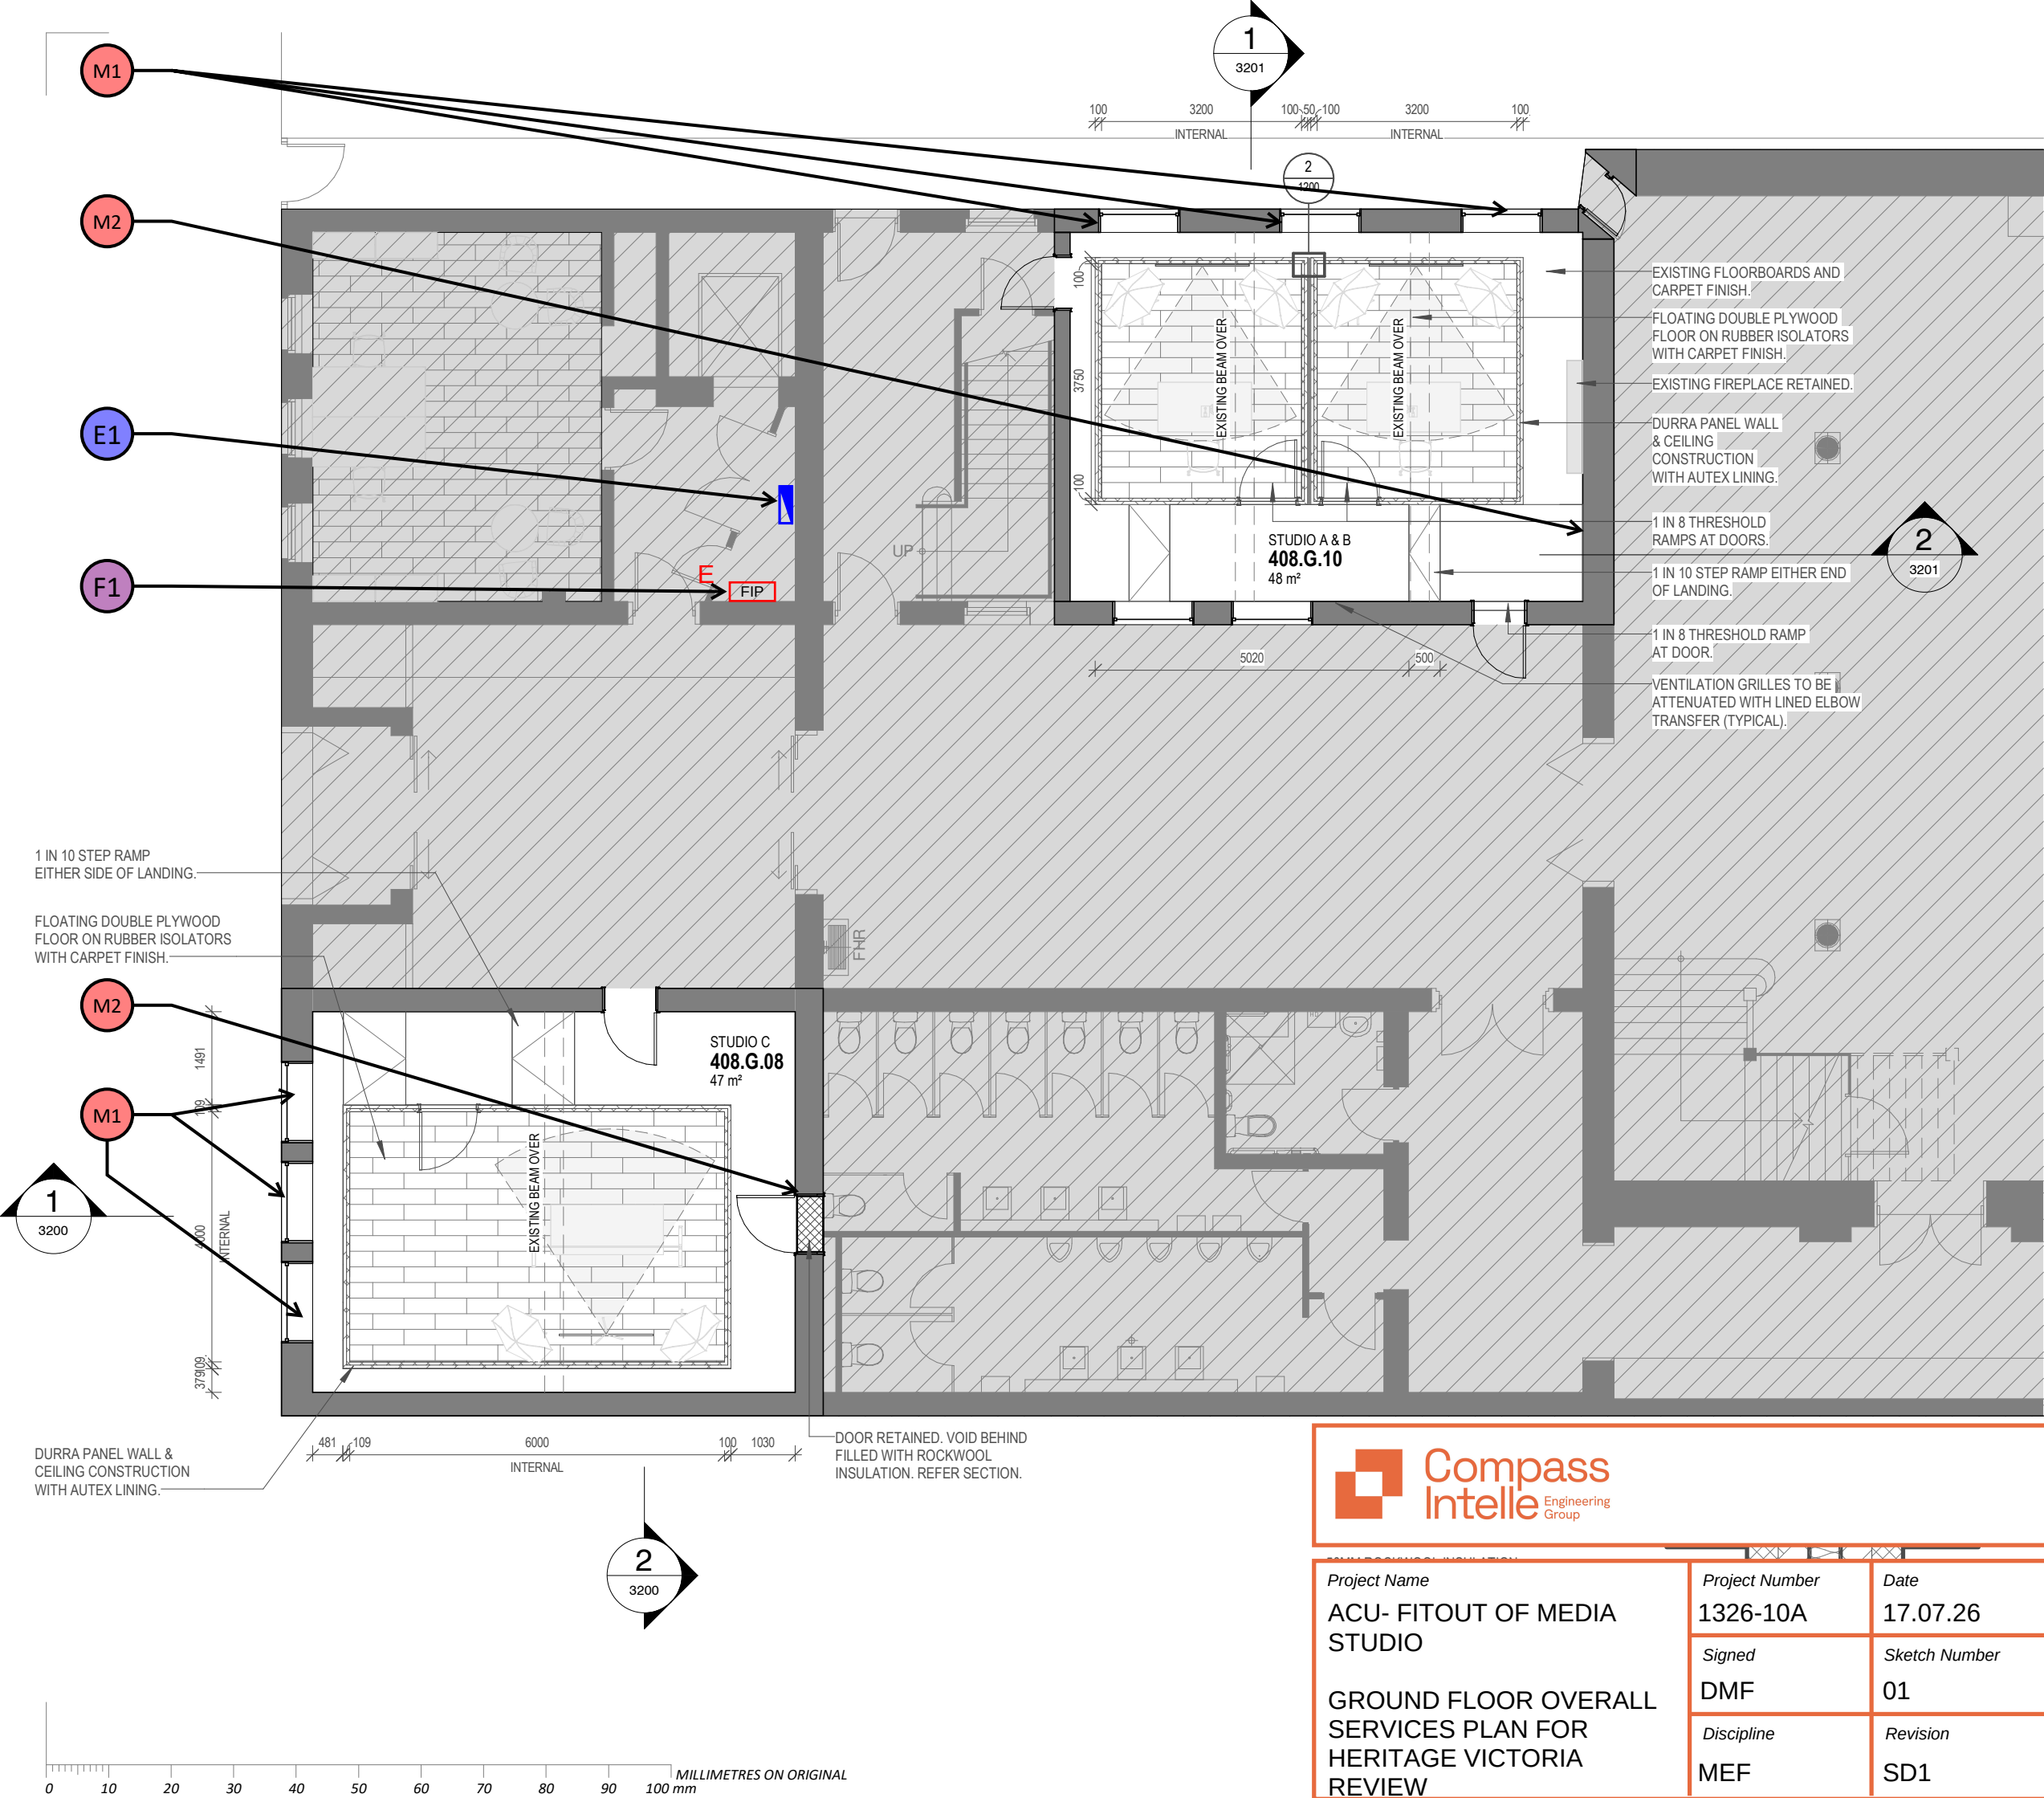

- ELECTRICAL SERVICES**
- E1. NEW ELECTRICAL LOAD CENTRE C/W COMPLIANT RCBO CIRCUIT BREAKERS ABOVE EXISTING SWITCHBOARD TO SERVE EMERGENCY LIGHTING. ALL CABLING TO RETICULATE FROM SWITCHBOARD AND ABOVE EXISTING SUSPENDED CEILING TO THE RESPECTIVE SCOPE OF WORK AREAS.
- FIRE SERVICES**
- F1. EXISTING FIRE INDICATOR PANELS TO BE RETAINED. ANY NEW EWIS SPEAKERS AND SMOKE DETECTORS SHALL WIRED FROM NEAREST EXISTING LOOP WITHIN ADJACENT ROOM CEILING.
- MECHANICAL SERVICES**
- M1. VENTILLATION FOR THE RESPECTIVE ROOM SHALL BE VIA EXTERNAL WINDOWS
- M2. EXISTING WALL MOUNTED AIR CONDITIONING UNIT PROPOSED TO BE RETAINED AND REUSED FOR ROOM COOLING AND HEATING.
- GENERAL NOTES**
1. EXACT ROUTING OF SERVICES TO THE RESPECTIVE STUDIOS TO BE CONFIRMED ON SITE BY CONTRACTORS.
2. IT IS ASSUMED THAT ACCESS TO CEILING VOID IS AVAILABLE FOR NON-DESTRUCTIVE SERVICES RETICULATION,
3. THIS SKETCH IS FOR THE PURPOSE OF HERITAGE VICTORIA REVIEW ONLY. THIS IS NOT A COMPLETE BUILDING SERVICES DESIGN DOCUMENTATION.

Kyriacou

LEVEL 5 / 406 COLLINS ST VIC 3000 AUS
t/ 61 3 9642 2249
e/ info@karch.com.au w/ www.karch.com.au
ABN 77 113 567 829 2

CLIENT
AUSTRALIAN CATHOLIC UNIVERSITY

115 VICTORIA PARADE, FITZROY, VIC 3065

ACU MELBOURNE - MEDIA STUDIO
INTERIOR RENOVATION

20-22 BRUNSWICK STREET, FITZROY, VIC 3065

TITLE
PROPOSED GROUND FLOOR PLAN

DESIGN DEVELOPMENT

DRAWN SH SCALE As indicated

REVIEWED AS DATE


DRAWING NO. REV.

ACU-MEL-DWG-AR-1200


1200 PROPOSED GROUND FLOOR PLAN.pdf |




Project Name	Project Number	Date
ACU- FITOUT OF MEDIA STUDIO	1326-10A	17.07.26
	Signed	Sketch Number
GROUND FLOOR OVERALL SERVICES PLAN FOR HERITAGE VICTORIA REVIEW	DMF	01
	Discipline	Revision
	MEF	SD1

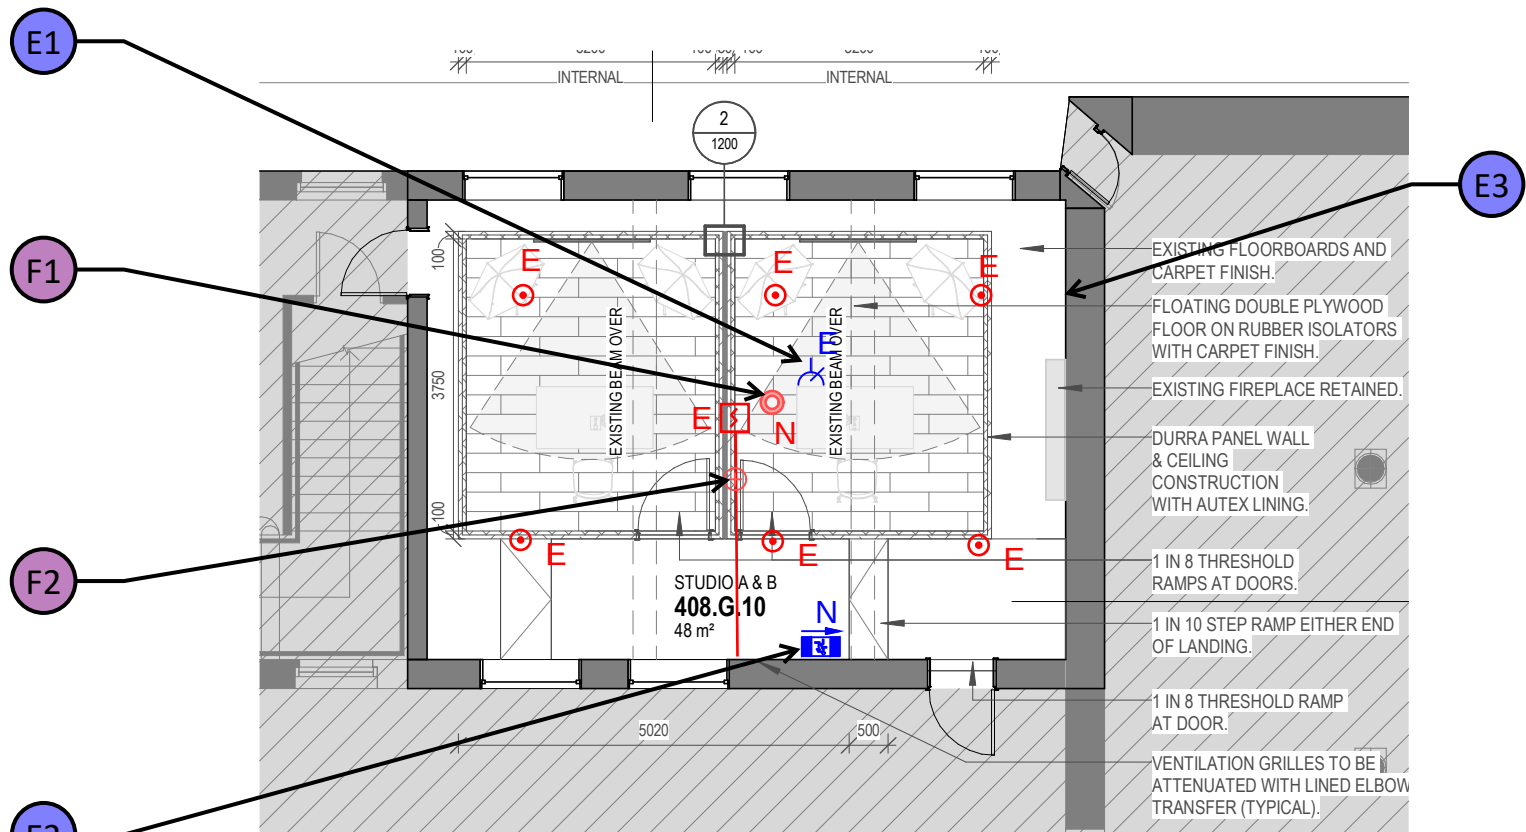

PROPOSED SERVICES LAYOUT
N.T.S.

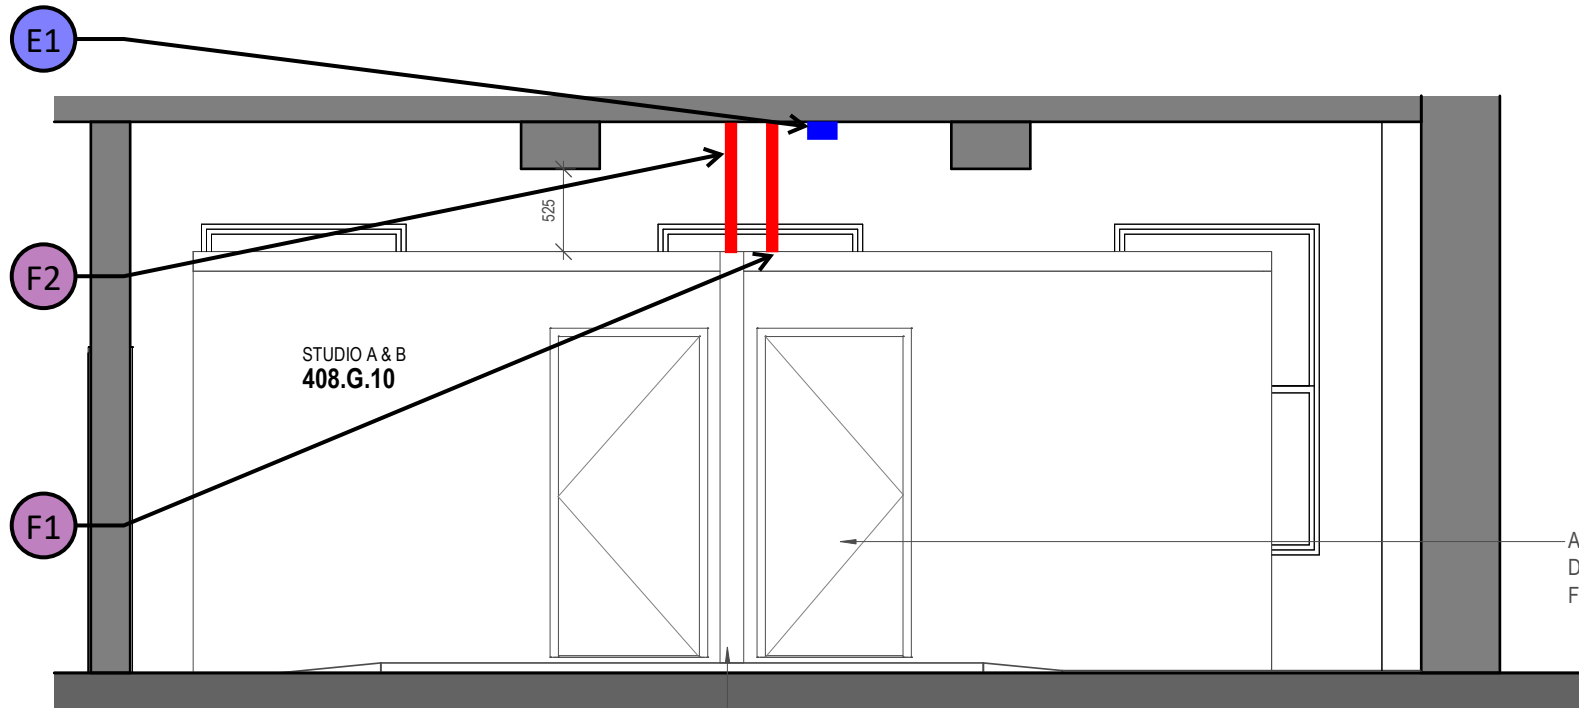

SOUTHERN ELEVATION
N.T.S.

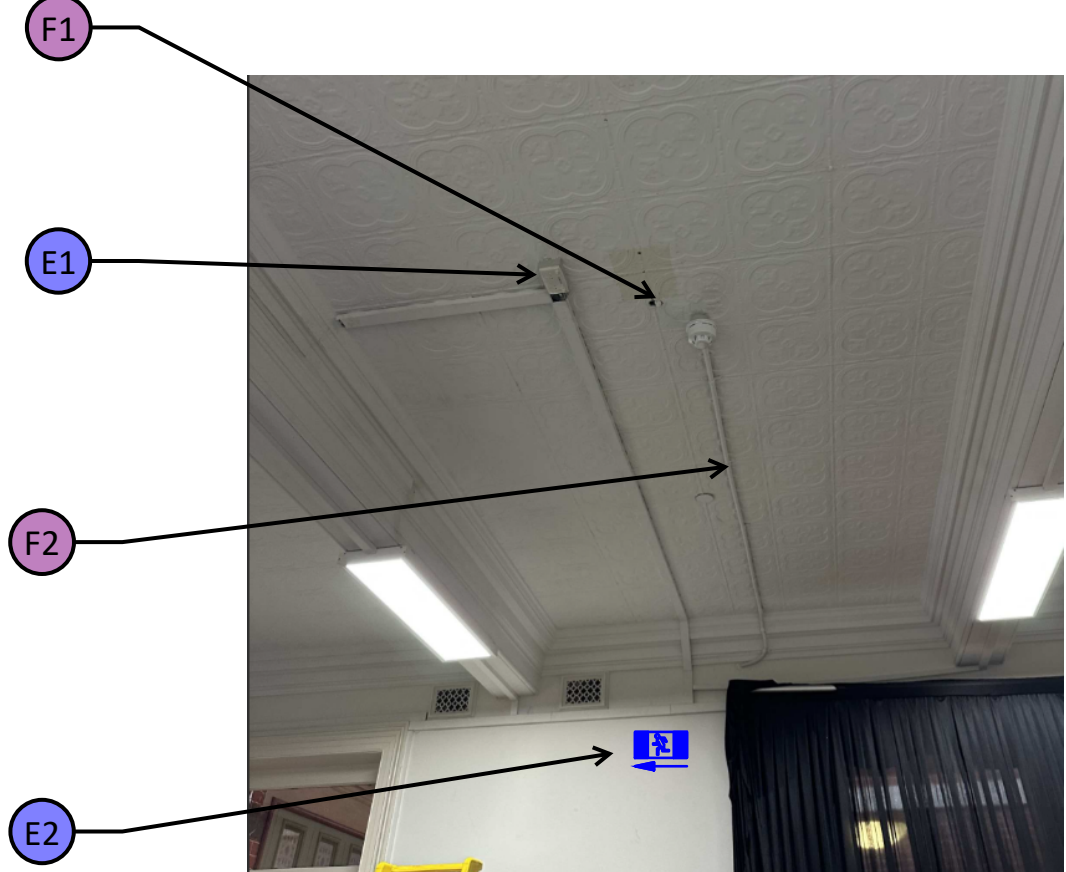

PHOTO

ELECTRICAL SERVICES

- E1. EXISTING CEILING MOUNTED DOUBLE GENERAL POWER OUTLETS TO BE RETAINED TO SUPPLY POWER TO THE PROPOSED PODS
- E2. NEW WALL MOUNTED SURFACE MOUNTED EXIT SIGNS. CABLE TO EXIT SIGN TO BE RETICULATED VIA EXISTING SURFACE MOUNTED DUCTING. EXIT SIGN SHALL BE MAXIMUM 2M AWAY FROM THE EXIT DOOR AND MAXIMUM 2M AWAY FROM RAMP AT THE LOWEST SIDE TO COMPLY WITH AS2293.1
- E3. EXISTING WALL MOUNTED ACCESS POINT TO BE RETAINED.

FIRE SERVICES

- F1. 32MM DIAMETER PIPEWORK FROM ABOVE CEILING TO THE PODS FOR SPRINKLER RETICULATION. EXISTING CEILING HOLE TO BE UTILISED FOR RETICULATION.
- F2. EXISTING SURFACE MOUNTED CONDUITS TO BE MODIFIED TO ACCOMMODATE A VERTICAL 25MM DIA METER VERTICAL CONDUIT FROM CEILING TO PODS FOR EWIS/SMOKE DETECTOR CABLE RETICULATION

		
Project Name ACU- FITOUT OF MEDIA STUDIO STUDIO A & B SERVICES SKETCH FOR HERITAGE VICTORIA REVIEW	Project Number 1326-10A	Date 17.07.26
	Signed DMF	Sketch Number 02
	Discipline ELEC/FIRE	Revision SD1



ELECTRICAL SERVICES

FIRE SERVICES

F2. NEW 25MM DIAMETER CONDUIT FROM CEILING TO PODS FOR THE PODS EWIS AND SMOKE DETECTORS CABLING. EXISTING CEILING HOLE TO BE UTILISED FOR RETICULATION.

Project Name ACU- FITOUT OF MEDIA STUDIO STUDIO C SERVICES SKETCH FOR HERITAGE VICTORIA REVIEW	Project Number	Date
	1326-10A	17.07.26
	Signed	Sketch Number
	DMF	03
	Discipline	Revision
	ELEC/FIRE	SD1